







| | | | | | | | | | |
|--|--|----|----|-----|----|-----|--|-------------|-----------------|
| OWNER:  شرکت سست موبلی آوند ایرپاکن (سهامی خاص) | BUSHEHR PETROCHEMICAL COMPANY MEG PLANT | | | | | | EPC CONTRACTOR:  Chagalesh-Enerchimi-Steam Joint Venture BUPC-MEG PLANT PROJECT | | |
| MC :  شرکت سست موبلی آوند ایرپاکن (سهامی خاص) | LOOP DIAGRAM FOR NITROGEN GAS BOOSTER | | | | | |  | | |
| Owner Document Number: 17811-30A | | | | | | | Project | Area | Phase |
| | BU | 20 | VD | 303 | IN | DIG | 0036 | Rev.: 02 | Page 1 of 35 |

LOOP DIAGRAM FOR NITROGEN GAS BOOSTER

| | | |
|--|---|---|
|  شرکت سست موبلی آوند ایرپاکن (سهامی خاص) |  Chagalesh-Enerchimi-Steam Joint Venture BUPC-MEG PLANT PROJECT | BUSHEHR PETROCHEMICAL COMPANY MEG PLANT |
| Document Review | | |
| Issue Purpose: | AFC | |
| Result Code: AP,AN,CM,RE,NC | AP | |
| Next Status : IFC,IFA,IFI,AFC,AB | - | |
| Responsible Department | MECHANICAL | |
| Commented Date | Sep/18/2022 | |
| Approval or review hereunder shall not be construed to relieve Vendor / Subcontractor of his responsibilities and liability under the contract. | | |

| | | | | | | |
|------|------------|---------------------------|----------|---------|----------|----------|
| | | | | | | |
| 02 | 05/09/2022 | Approved for Construction | RT | KP | JR | |
| 01 | 15/07/2022 | For approval | MG | RB | KP | |
| 00 | 18/10/2021 | For approval | HT | KP | JR | |
| Rev. | Date | Purpose of Issue | Prepared | Checked | Approved | AC Code |
| | | | | | Class: 1 | Phase: P |



Airpack B.V.

4301 RN Zierikzee
The Netherlands

PHONE: (31) (0) 111 - 415455

FAX: (31) (0) 111 - 413338

E-MAIL : AIRPACK@AIRPACK.NL

WEBPAGE : WWW.AIRPACK.NL

| | | | | |
|-----------------------|---|--------------------------------------|--------------|------|
| Client | : | Bushehr Petrochemical Company (BUPC) | | |
| Equipment location | : | Iran, Onshore | | |
| Client reference | : | Bushehr MEG Plant Project | | |
| Client dwg. no. | : | BU-20-VD-303-IN-DIG-0043 | | |
| Airpack reference | : | 17811-30A | | |
| Airpack dwg. no. | : | 17811-05 | | |
| Generation date | : | 06-Nov-20 | | |
| E & I manager | : | RBE | Revision no. | : 02 |
| Last modifications | : | 24-Aug-22 | | |
| Last modifications by | : | RTR | | |




| | |
|--|--------------------------|
| CLIENT DWG NO. | BU-20-VD-303-IN-DIG-0043 |
| EQUIPMENT NO. | 20-C-1002 |
| EQUIPMENT LOCATION | Iran, Onshore |
| THIS DRAWING IS OWNED BY AIRPACK, AND SHALL NOT BE PRINTED OR COPIED IN ANY OTHER WAY THAN WITH AIRPACKS PERMISSION! | |


| | |
|-------------------------------------|--------------------------------------|
| SUBJECT Title page / cover sheet | |
| ADAPTED TO P&ID REVISION | 06 |
| CLIENT | Bushehr Petrochemical Company (BUPC) |
| CLIENT REF. | Bushehr MEG Plant Project |
| AIRPACK REF. | 17811-30A |

| | | |
|------------------------|----------|--------------|
| DRAWN BY | RTR | = |
| CHECKED BY | RBE | + |
| LAST MODIFICATION DATE | | CURRENT PAGE |
| AIRPACK DWG NO. | 17811-05 | |
| REVISION | 02 | |
| TOTAL PAGE AMOUNT | 1 | |


Internal targets

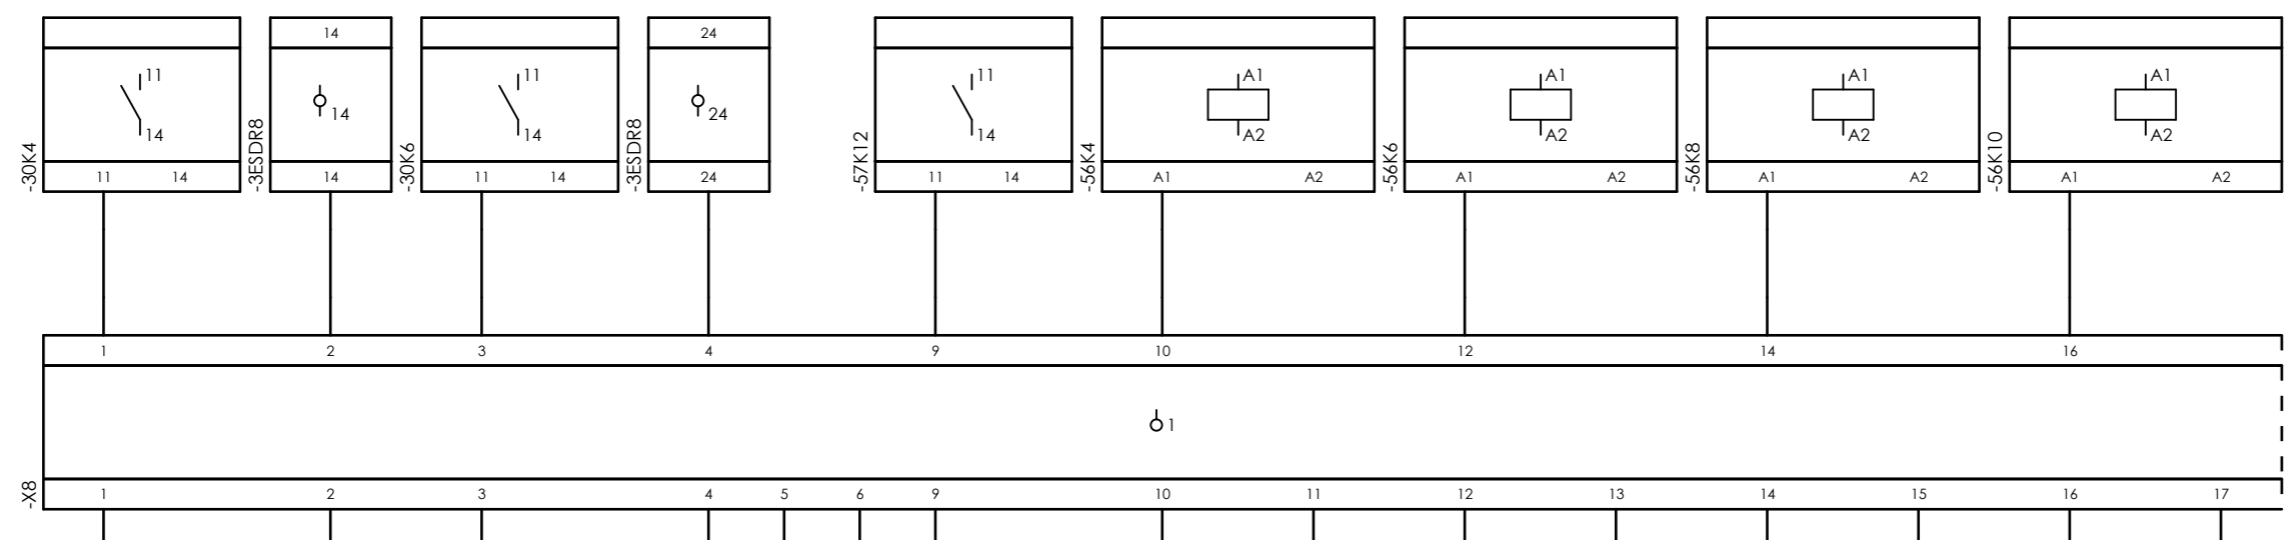

=20-C-1002+UCP-C1002-01-DB_COMA

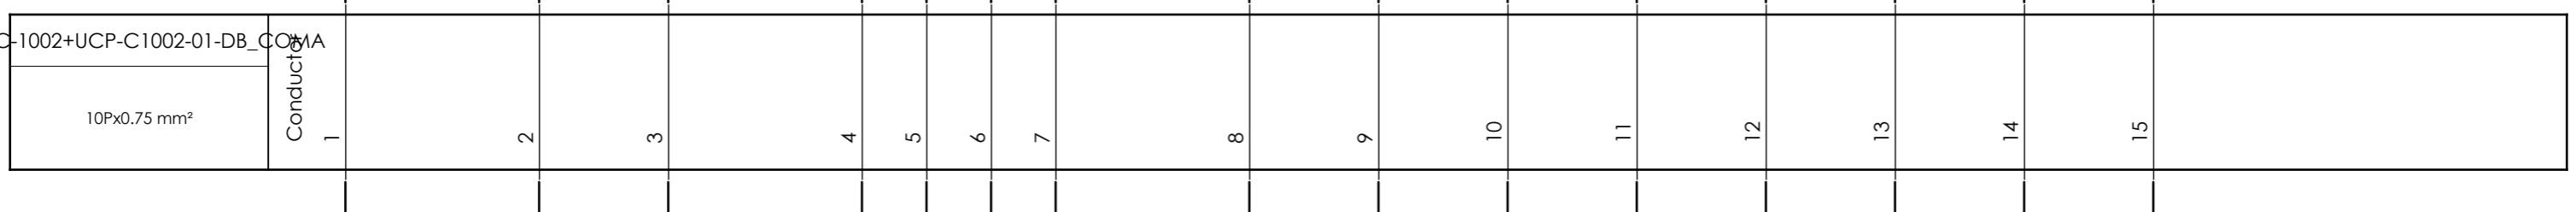

External targets

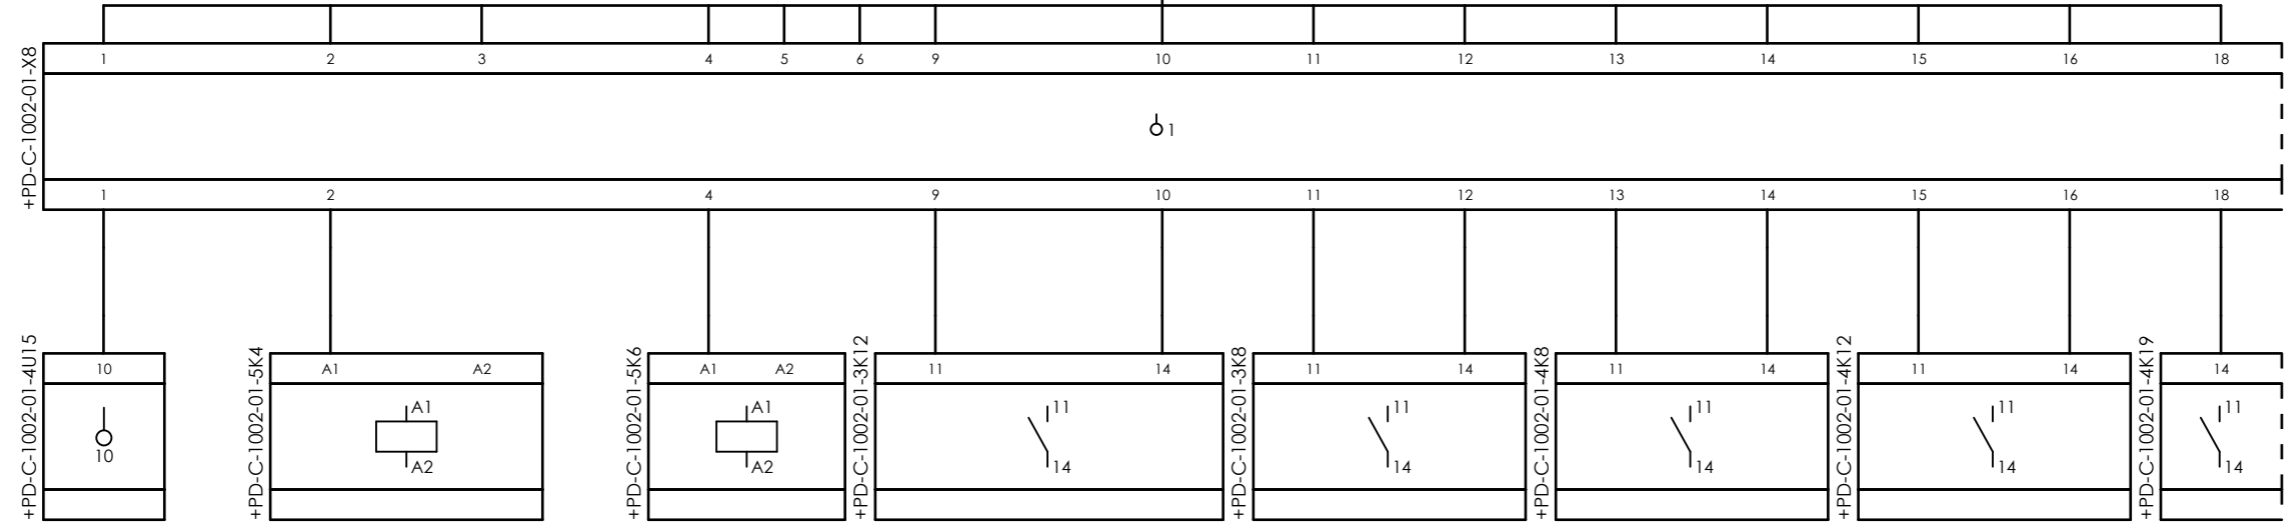


CLIENT DWG NO. BU-20-VD-303-IN-DIG-0043
 EQUIPMENT NO. 20-C-1002
 EQUIPMENT LOCATION Iran, Onshore
 THIS DRAWING IS OWNED BY AIRPACK, AND SHALL NOT BE PRINTED OR COPIED IN ANY OTHER WAY THAN WITH AIRPACKS PERMISSION!

SUBJECT Cable-connection diagram =20-C-1002+UCP-C1002-01-DB_COMA
 ADAPTED TO P&ID REVISION 06
 CLIENT Bushehr Petrochemical Company (BUPC)
 CLIENT REF. Bushehr MEG Plant Project
 AIRPACK REF. 17811-30A

DRAWN BY RTR
 CHECKED BY RBE
 LAST MODIFICATION DATE
 AIRPACK DWG NO. 17811-05
 REVISION 02
 TOTAL PAGE AMOUNT 2

=
 +
 CURRENT PAGE
 2


Internal targets

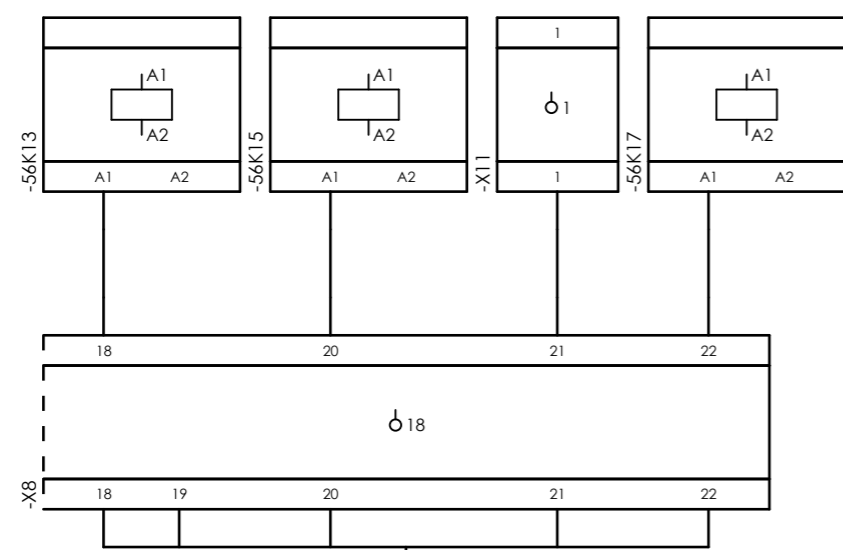

=20-C-1002+UCP-C1002-01-DB_COMA




External targets

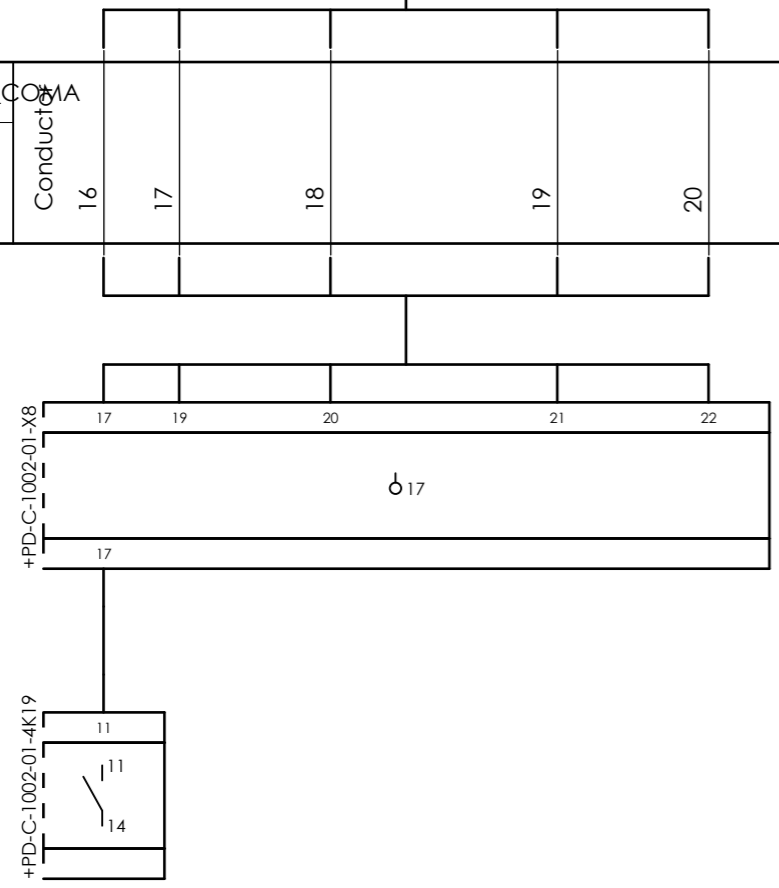

| | |
|--|--------------------------|
| CLIENT DWG NO. | BU-20-VD-303-IN-DIG-0043 |
| EQUIPMENT NO. | 20-C-1002 |
| EQUIPMENT LOCATION | Iran, Onshore |
| THIS DRAWING IS OWNED BY AIRPACK, AND SHALL NOT BE PRINTED OR COPIED IN ANY OTHER WAY THAN WITH AIRPACKS PERMISSION! | |


| | | | | | | | |
|--|--------------------------------------|------------------------|--|----------|--|--------------|--|
| SUBJECT | | DRAWN BY | | RTR | | = | |
| Cable-connection diagram =20-C-1002+UCP-C1002-01-DB_COMA | | CHECKED BY | | RBE | | + | |
| ADAPTED TO P&ID REVISION | 06 | LAST MODIFICATION DATE | | | | CURRENT PAGE | |
| CLIENT | Bushehr Petrochemical Company (BUPC) | AIRPACK DWG NO. | | 17811-05 | | | |
| CLIENT REF. | Bushehr MEG Plant Project | REVISION | | 02 | | | |
| AIRPACK REF. | 17811-30A | TOTAL PAGE AMOUNT | | 3 | | | |

Internal targets


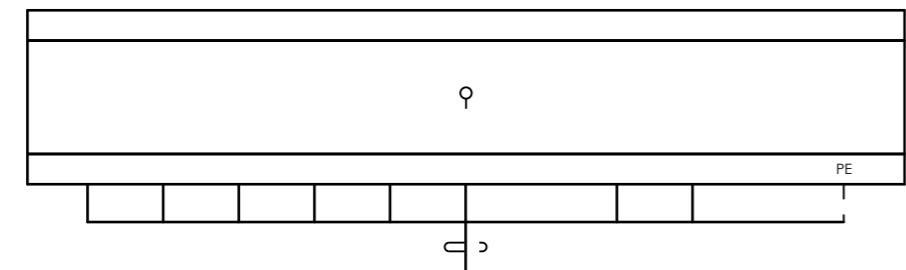


=20-C-1002+UCP-C1002-01-ESD

5Px0.75 mm² mm²

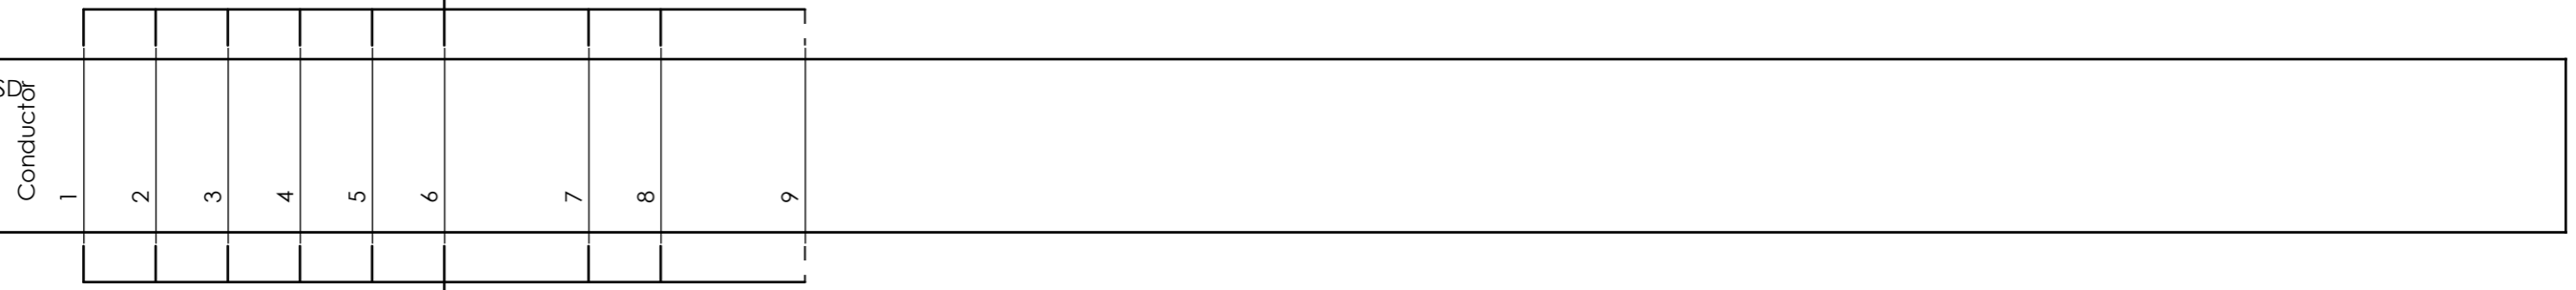

External targets

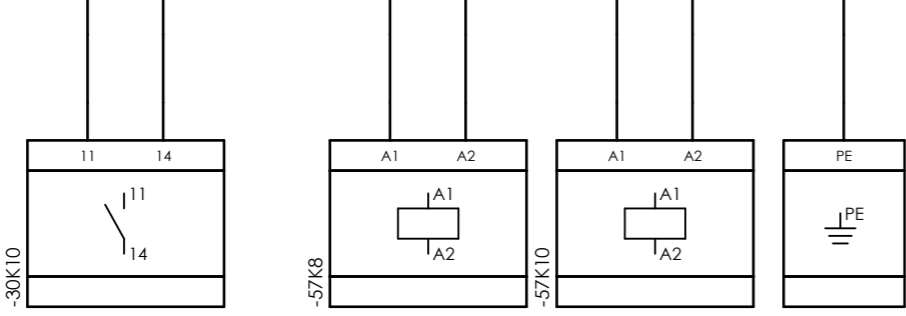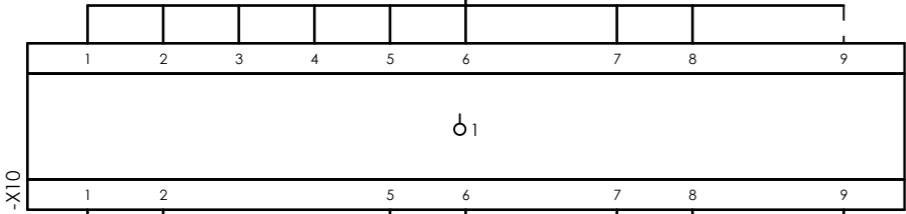






CLIENT DWG NO. BU-20-VD-303-IN-DIG-0043
 EQUIPMENT NO. 20-C-1002
 EQUIPMENT LOCATION Iran, Onshore
 THIS DRAWING IS OWNED BY AIRPACK, AND SHALL NOT BE PRINTED OR COPIED IN ANY OTHER WAY THAN WITH AIRPACKS PERMISSION!

SUBJECT Cable-connection diagram =20-C-1002+UCP-C1002-01-ESD
 ADAPTED TO P&ID REVISION 06
 CLIENT Bushehr Petrochemical Company (BUPC)
 CLIENT REF. Bushehr MEG Plant Project
 AIRPACK REF. 17811-30A

DRAWN BY RTR
 CHECKED BY RBE
 LAST MODIFICATION DATE
 AIRPACK DWG NO. 17811-05
 REVISION 02
 TOTAL PAGE AMOUNT 4

=
 +
 CURRENT PAGE

Internal targets

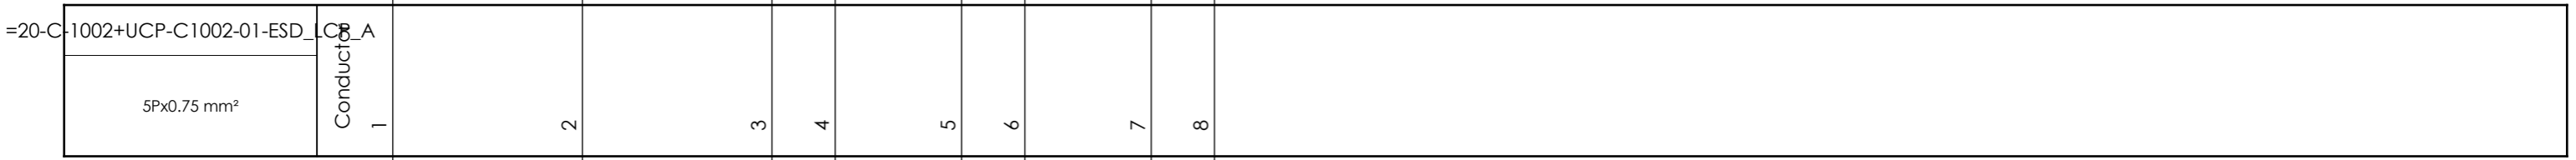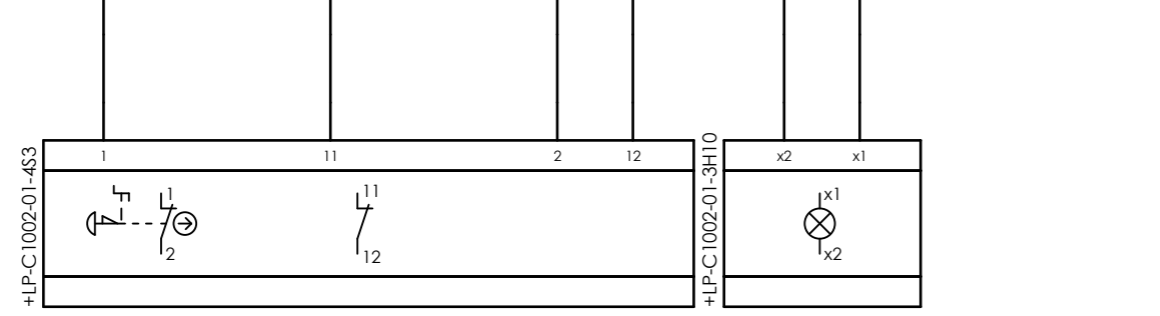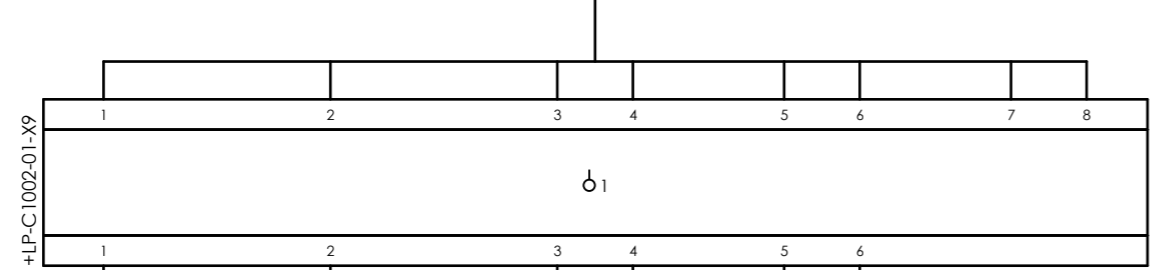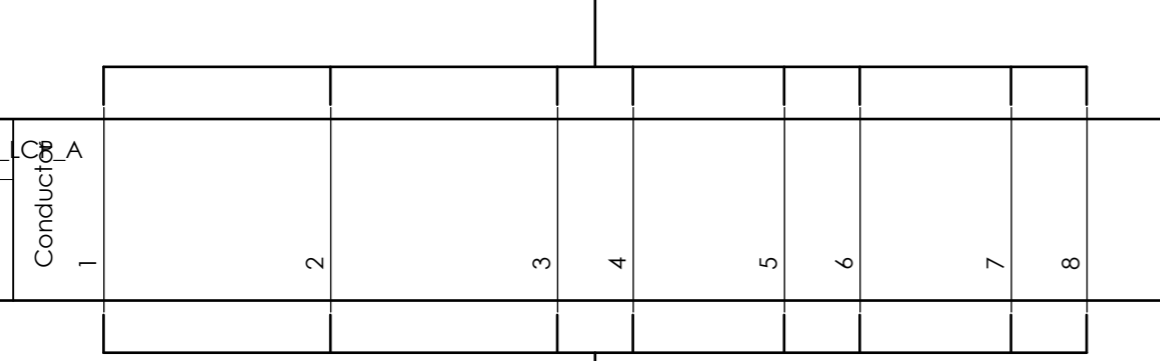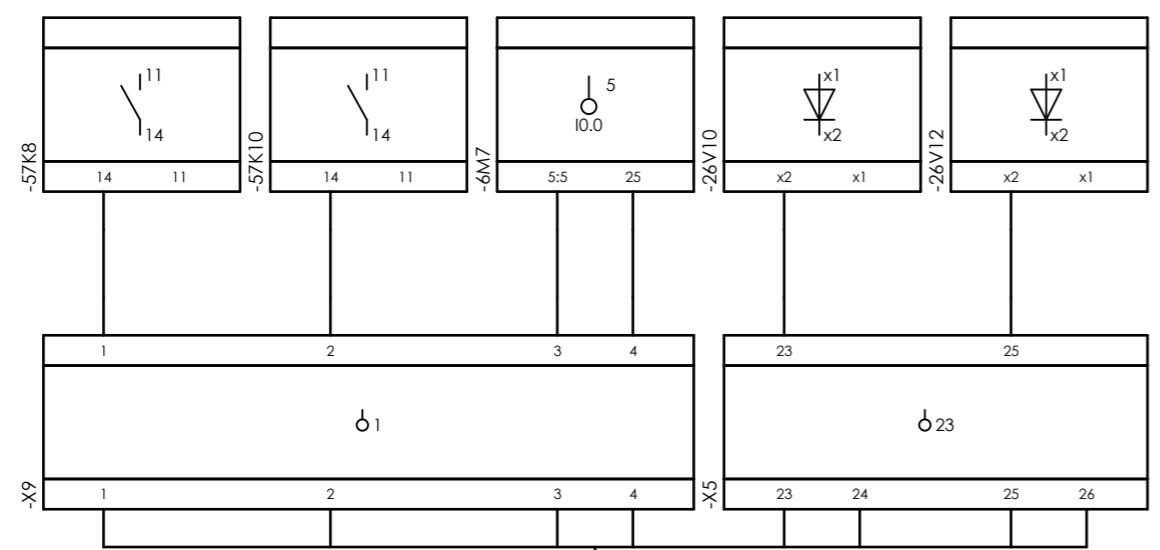




External targets





| | | | | | | |
|--|--------------------------|--|--------------------------------------|------------------------|----------|--------------|
| CLIENT DWG NO. | BU-20-VD-303-IN-DIG-0043 | SUBJECT | | DRAWN BY | RTR | = |
| EQUIPMENT NO. | 20-C-1002 | Cable-connection diagram =20-C-1002+UCP-C1002-01-ESD_LCP_A | | CHECKED BY | RBE | + |
| EQUIPMENT LOCATION | Iran, Onshore | ADAPTED TO P&ID REVISION | 06 | LAST MODIFICATION DATE | | CURRENT PAGE |
| THIS DRAWING IS OWNED BY AIRPACK, AND SHALL NOT BE PRINTED OR COPIED IN ANY OTHER WAY THAN WITH AIRPACKS PERMISSION! | | CLIENT | Bushehr Petrochemical Company (BUPC) | AIRPACK DWG NO. | 17811-05 | |
| | | CLIENT REF. | Bushehr MEG Plant Project | REVISION | 02 | |
| | | AIRPACK REF. | 17811-30A | TOTAL PAGE AMOUNT | 5 | |

| | | |
|------------------------|----------|--------------|
| DRAWN BY | RTR | = |
| CHECKED BY | RBE | + |
| LAST MODIFICATION DATE | | CURRENT PAGE |
| AIRPACK DWG NO. | 17811-05 | |
| REVISION | 02 | |
| TOTAL PAGE AMOUNT | 5 | |

Internal targets

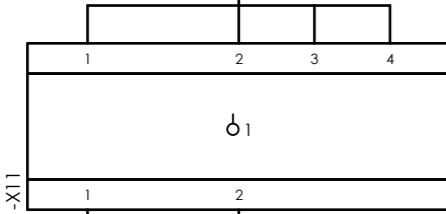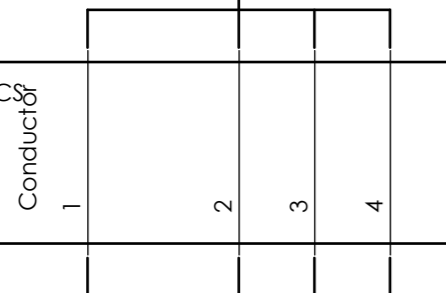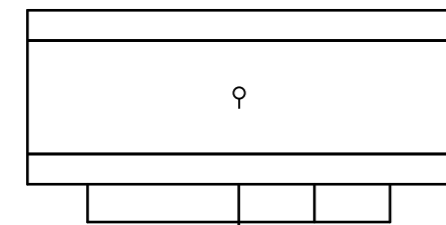

External targets

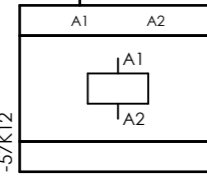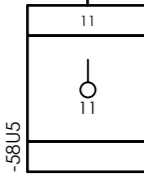

=20-C-1002+UCP-C1002-01-FCS
4Px1 mm² mm²
Conductors

-X11

-58U5

-57K12




| | |
|--|--------------------------|
| CLIENT DWG NO. | BU-20-VD-303-IN-DIG-0043 |
| EQUIPMENT NO. | 20-C-1002 |
| EQUIPMENT LOCATION | Iran, Onshore |
| THIS DRAWING IS OWNED BY AIRPACK, AND SHALL NOT BE PRINTED OR COPIED IN ANY OTHER WAY THAN WITH AIRPACKS PERMISSION! | |


| | | | |
|--------------------------|---------------------------|--|--------------------------------------|
| SUBJECT | | Cable-connection diagram =20-C-1002+UCP-C1002-01-FCS | |
| ADAPTED TO P&ID REVISION | 06 | CLIENT | Bushehr Petrochemical Company (BUPC) |
| CLIENT REF. | Bushehr MEG Plant Project | AIRPACK REF. | 17811-30A |

| | | |
|------------------------|----------|--------------|
| DRAWN BY | RTR | = |
| CHECKED BY | RBE | + |
| LAST MODIFICATION DATE | | CURRENT PAGE |
| AIRPACK DWG NO. | 17811-05 | |
| REVISION | 02 | |
| TOTAL PAGE AMOUNT | 6 | |

Internal targets

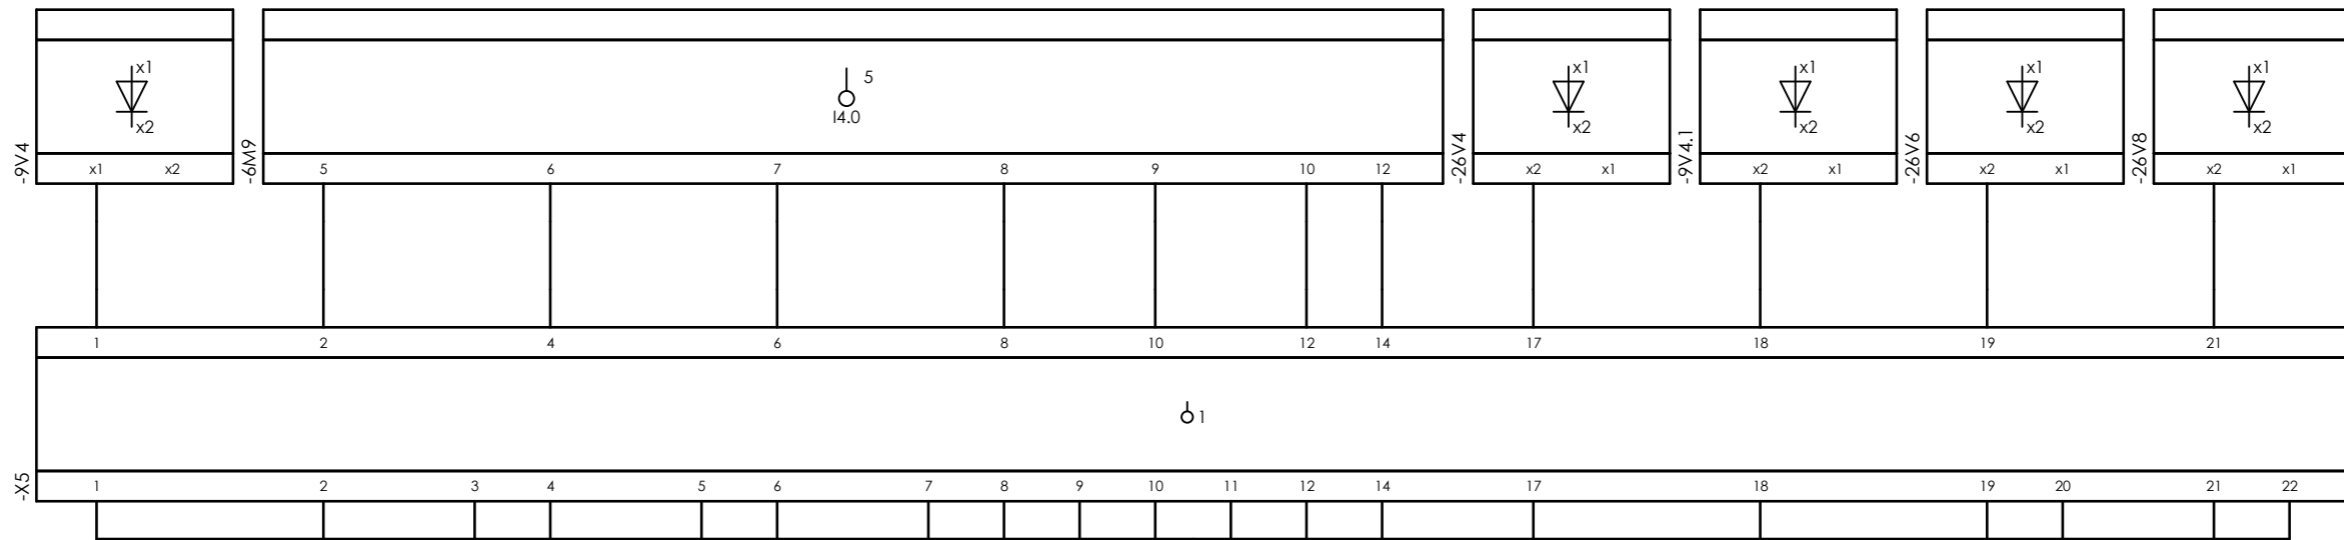

External targets

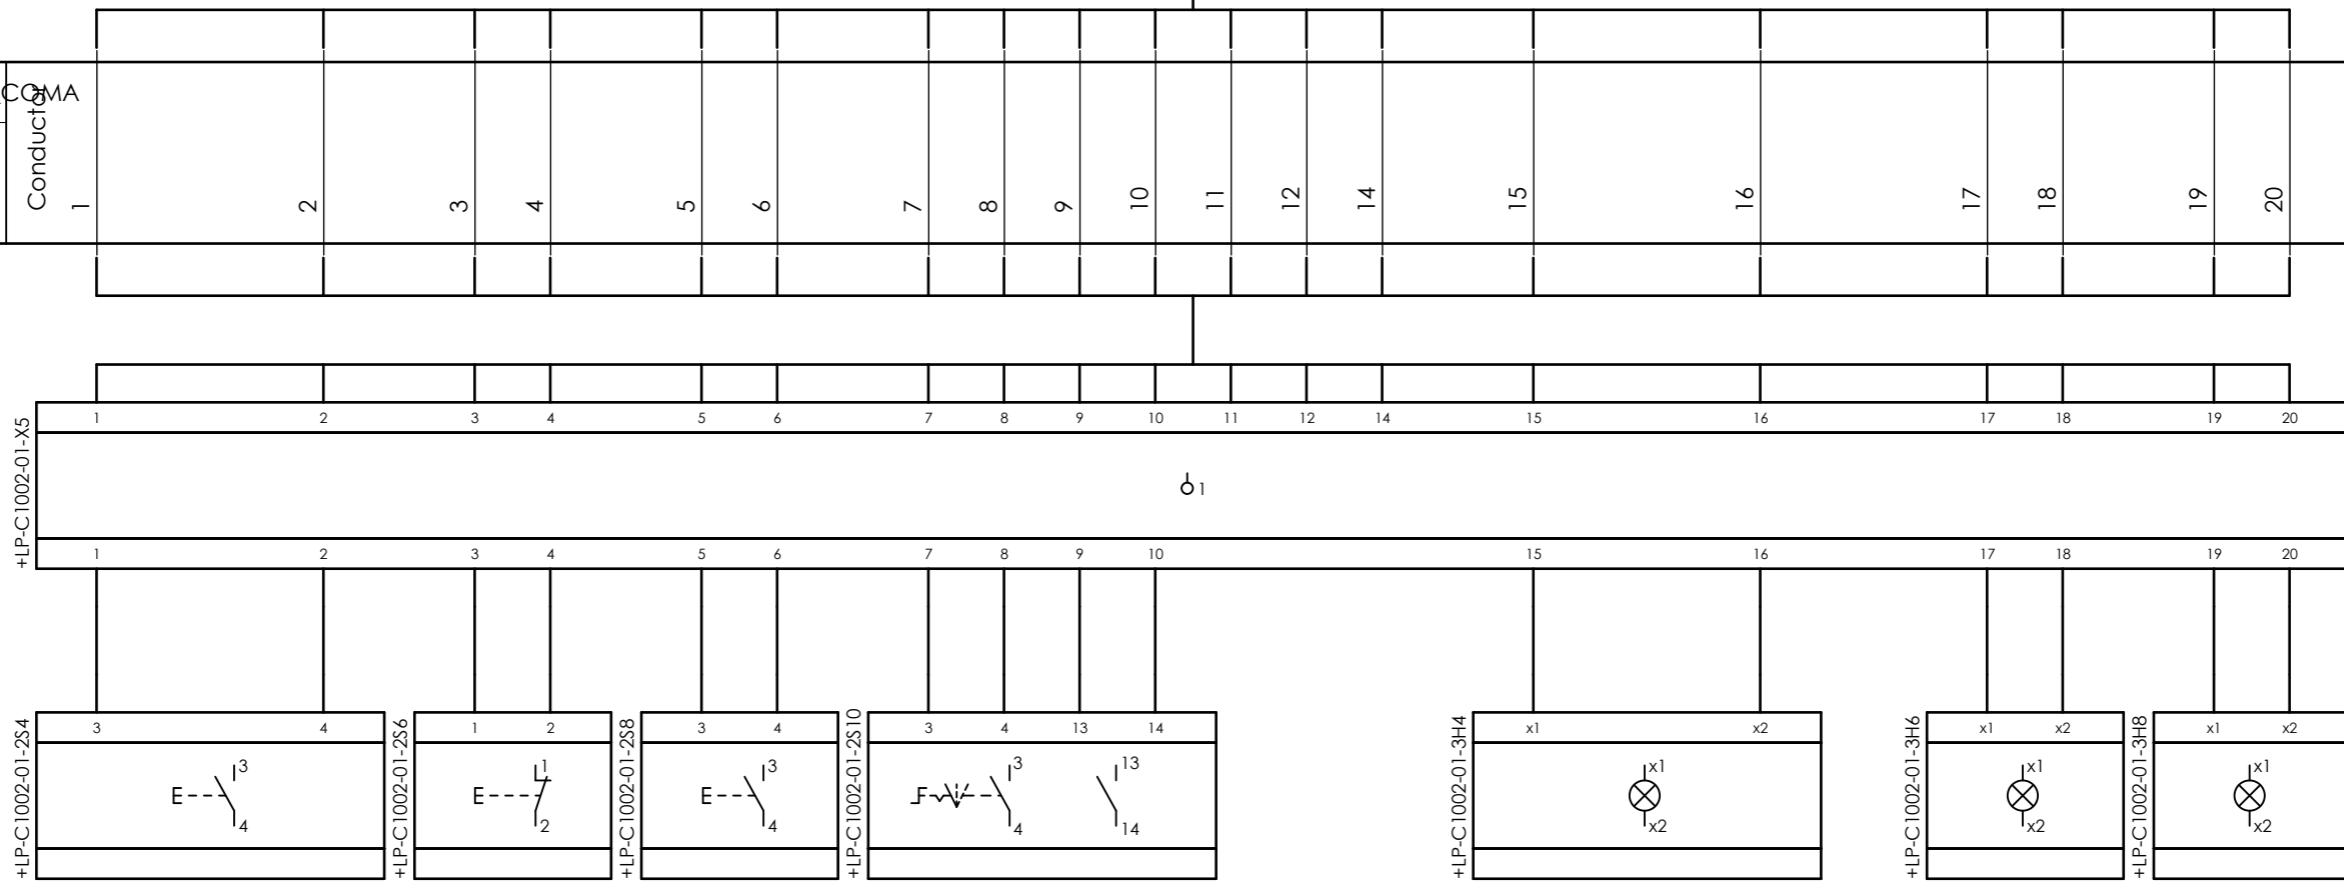


CLIENT DWG NO. BU-20-VD-303-IN-DIG-0043
 EQUIPMENT NO. 20-C-1002
 EQUIPMENT LOCATION Iran, Onshore
 THIS DRAWING IS OWNED BY AIRPACK, AND SHALL NOT BE PRINTED OR COPIED IN ANY OTHER WAY THAN WITH AIRPACKS PERMISSION!

SUBJECT Cable-connection diagram =20-C-1002+UCP-C1002-01-LCP_COMA
 ADAPTED TO P&ID REVISION 06
 CLIENT Bushehr Petrochemical Company (BUPC)
 CLIENT REF. Bushehr MEG Plant Project
 AIRPACK REF. 17811-30A


DRAWN BY RTR
 CHECKED BY RBE
 LAST MODIFICATION DATE
 AIRPACK DWG NO. 17811-05
 REVISION 02
 TOTAL PAGE AMOUNT 7

=
 +
 CURRENT PAGE
 7


Internal targets

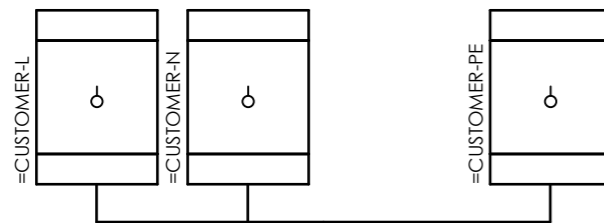

=20-C-1002+UCP-C1002-01-PS_06
3x2.5 sqmm

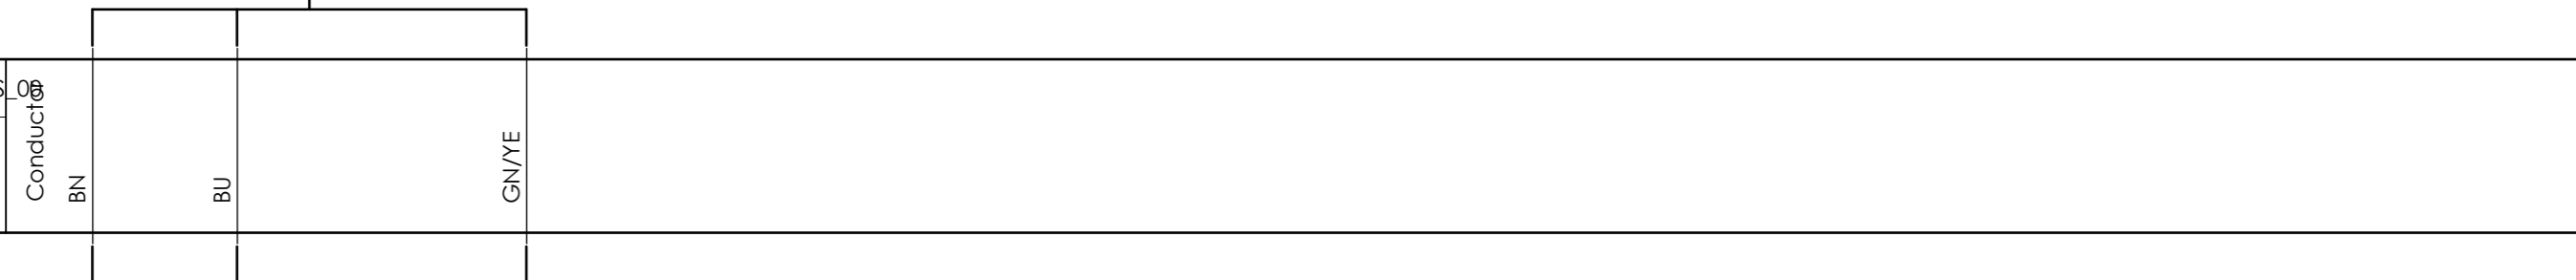


External targets

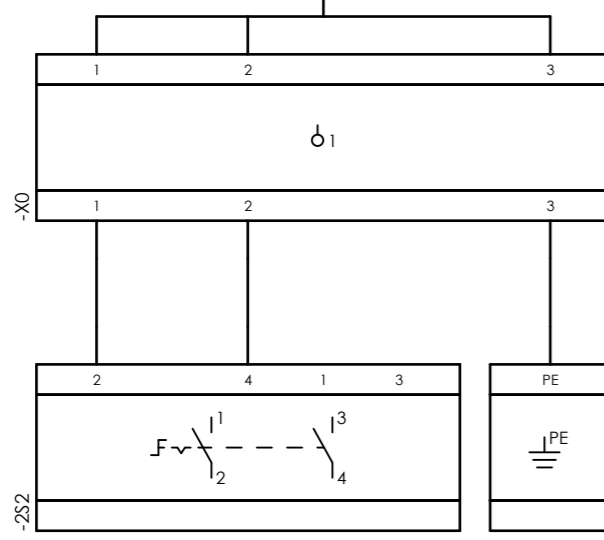


| | |
|--|--------------------------|
| CLIENT DWG NO. | BU-20-VD-303-IN-DIG-0043 |
| EQUIPMENT NO. | 20-C-1002 |
| EQUIPMENT LOCATION | Iran, Onshore |
| THIS DRAWING IS OWNED BY AIRPACK, AND SHALL NOT BE PRINTED OR COPIED IN ANY OTHER WAY THAN WITH AIRPACKS PERMISSION! | |

| | | | | |
|--|--------------------------------------|------------------------|----------|--------------|
| SUBJECT | | DRAWN BY | RTR | = |
| Cable-connection diagram =20-C-1002+UCP-C1002-01-PS_00 | | CHECKED BY | RBE | + |
| ADAPTED TO P&ID REVISION | 06 | LAST MODIFICATION DATE | | CURRENT PAGE |
| CLIENT | Bushehr Petrochemical Company (BUPC) | AIRPACK DWG NO. | 17811-05 | |
| CLIENT REF. | Bushehr MEG Plant Project | REVISION | 02 | |
| AIRPACK REF. | 17811-30A | TOTAL PAGE AMOUNT | 8 | |


Internal targets

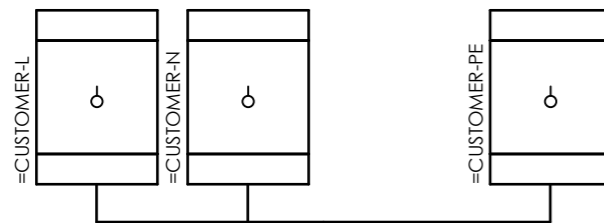

=20-C-1002+UCP-C1002-01-PS_01
3x2.5 sqmm

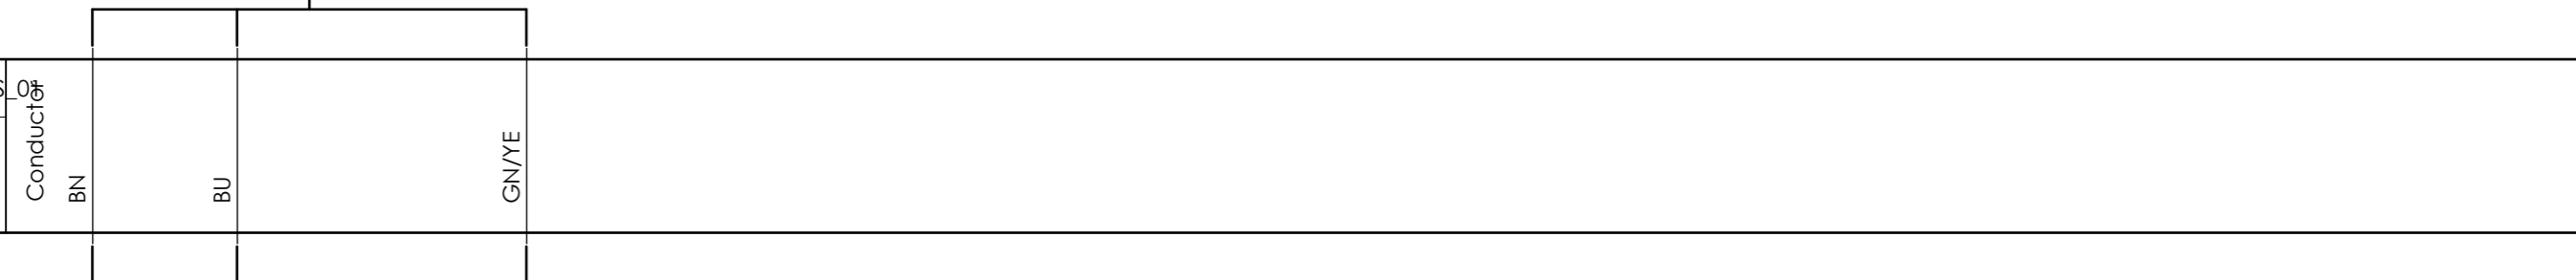

External targets

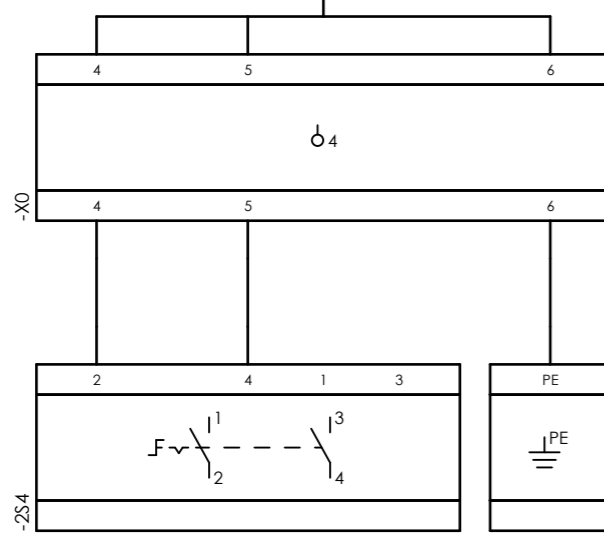


| | |
|--|--------------------------|
| CLIENT DWG NO. | BU-20-VD-303-IN-DIG-0043 |
| EQUIPMENT NO. | 20-C-1002 |
| EQUIPMENT LOCATION | Iran, Onshore |
| THIS DRAWING IS OWNED BY AIRPACK, AND SHALL NOT BE PRINTED OR COPIED IN ANY OTHER WAY THAN WITH AIRPACKS PERMISSION! | |

| | | | |
|--------------------------|---------------------------|--|--------------------------------------|
| SUBJECT | | Cable-connection diagram =20-C-1002+UCP-C1002-01-PS_01 | |
| ADAPTED TO P&ID REVISION | 06 | CLIENT | Bushehr Petrochemical Company (BUPC) |
| CLIENT REF. | Bushehr MEG Plant Project | AIRPACK REF. | 17811-30A |

| | | |
|------------------------|----------|--------------|
| DRAWN BY | RTR | = |
| CHECKED BY | RBE | + |
| LAST MODIFICATION DATE | | CURRENT PAGE |
| AIRPACK DWG NO. | 17811-05 | |
| REVISION | 02 | |
| TOTAL PAGE AMOUNT | 9 | |


Internal targets

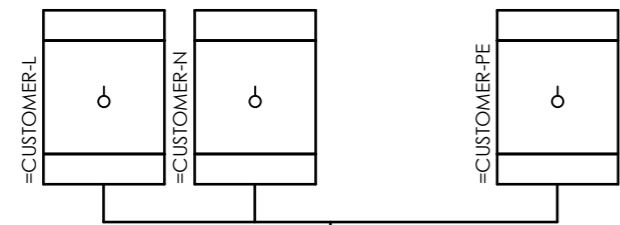

=20-C-1002+UCP-C1002-01-PS_02



External targets

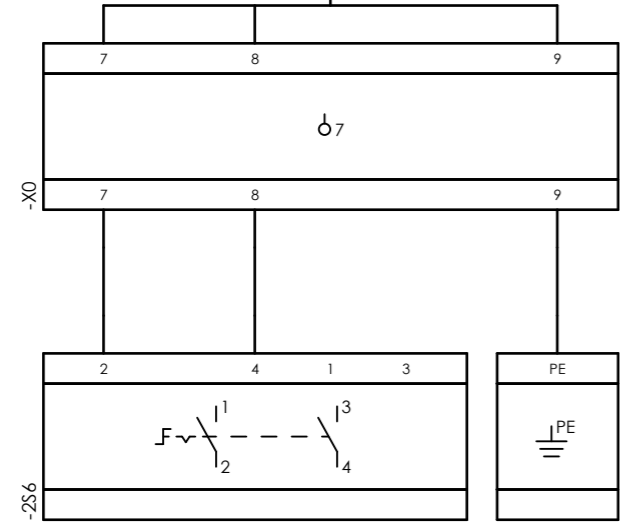


| | |
|--|--------------------------|
| CLIENT DWG NO. | BU-20-VD-303-IN-DIG-0043 |
| EQUIPMENT NO. | 20-C-1002 |
| EQUIPMENT LOCATION | Iran, Onshore |
| THIS DRAWING IS OWNED BY AIRPACK, AND SHALL NOT BE PRINTED OR COPIED IN ANY OTHER WAY THAN WITH AIRPACKS PERMISSION! | |

| | |
|---|--------------------------------------|
| SUBJECT Cable-connection diagram =20-C-1002+UCP-C1002-01-PS_02 | |
| ADAPTED TO P&ID REVISION | 06 |
| CLIENT | Bushehr Petrochemical Company (BUPC) |
| CLIENT REF. | Bushehr MEG Plant Project |
| AIRPACK REF. | 17811-30A |

| | | |
|------------------------|----------|--------------|
| DRAWN BY | RTR | = |
| CHECKED BY | RBE | + |
| LAST MODIFICATION DATE | | CURRENT PAGE |
| AIRPACK DWG NO. | 17811-05 | |
| REVISION | 02 | |
| TOTAL PAGE AMOUNT | 10 | |

Internal targets



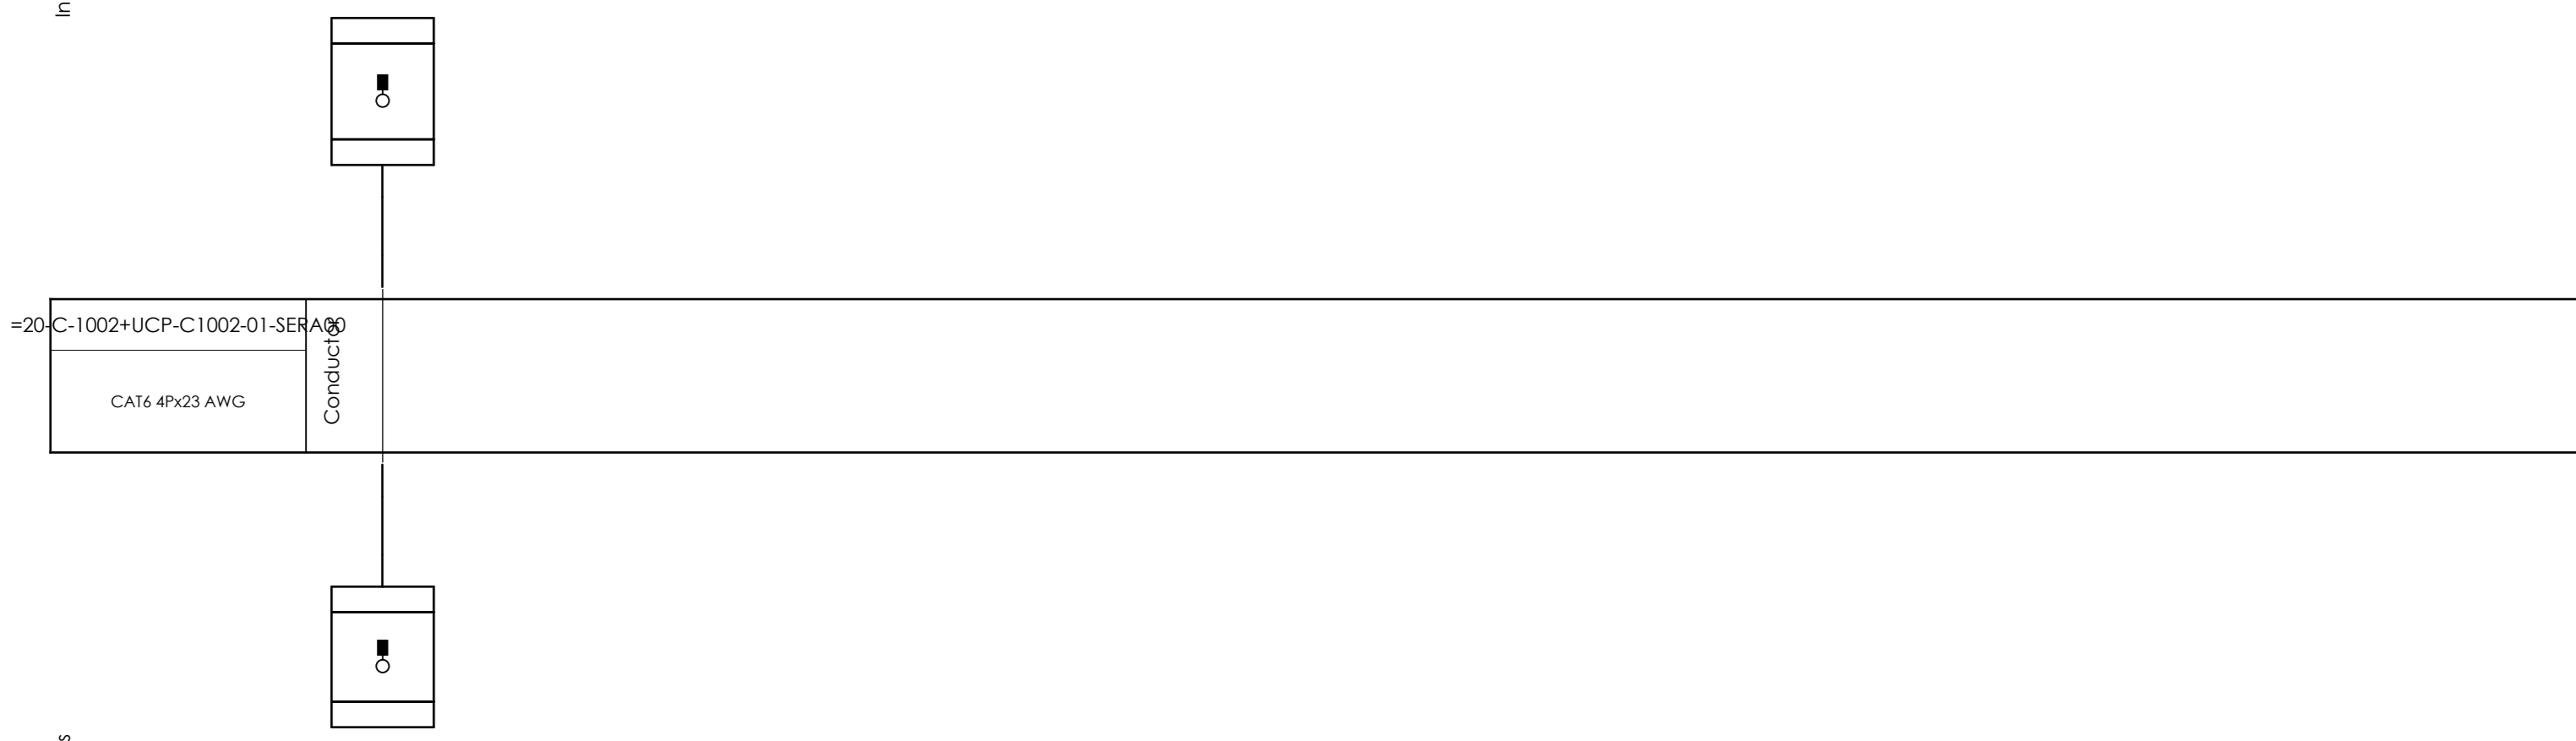


External targets



| | | | | | | |
|--|--------------------------|---|--------------------------------------|------------------------|----------|--------------|
| CLIENT DWG NO. | BU-20-VD-303-IN-DIG-0043 | SUBJECT | | DRAWN BY | RTR | = |
| EQUIPMENT NO. | 20-C-1002 | Cable-connection diagram =20-C-1002+UCP-C1002-01-SERA00 | | CHECKED BY | RBE | + |
| EQUIPMENT LOCATION | Iran, Onshore | ADAPTED TO P&ID REVISION | 06 | LAST MODIFICATION DATE | | CURRENT PAGE |
| THIS DRAWING IS OWNED BY AIRPACK, AND SHALL NOT BE PRINTED OR COPIED IN ANY OTHER WAY THAN WITH AIRPACKS PERMISSION! | | CLIENT | Bushehr Petrochemical Company (BUPC) | AIRPACK DWG NO. | 17811-05 | |
| | | CLIENT REF. | Bushehr MEG Plant Project | REVISION | 02 | |
| | | AIRPACK REF. | 17811-30A | TOTAL PAGE AMOUNT | 11 | |

Internal targets

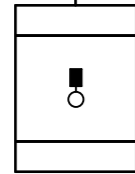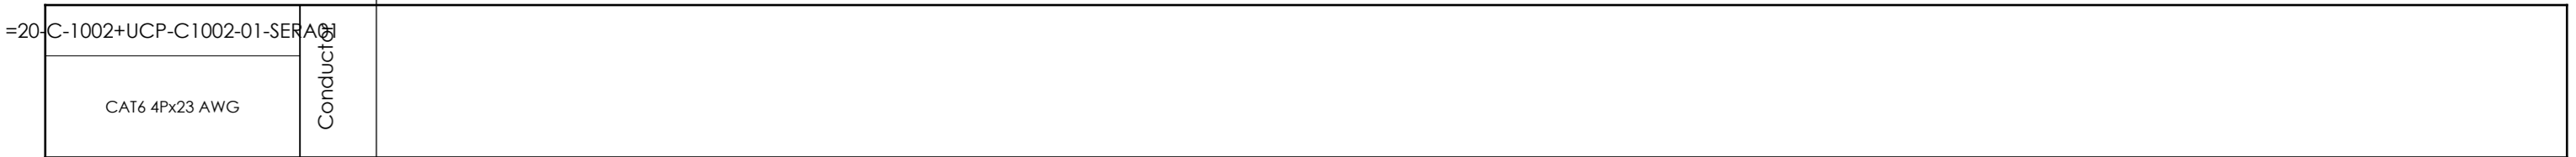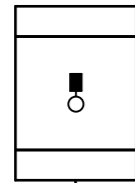

External targets




| | |
|--|--------------------------|
| CLIENT DWG NO. | BU-20-VD-303-IN-DIG-0043 |
| EQUIPMENT NO. | 20-C-1002 |
| EQUIPMENT LOCATION | Iran, Onshore |
| THIS DRAWING IS OWNED BY AIRPACK, AND SHALL NOT BE PRINTED OR COPIED IN ANY OTHER WAY THAN WITH AIRPACKS PERMISSION! | |



| | | | | | |
|---|--------------------------------------|------------------------|--------------|-----|--|
| SUBJECT | | DRAWN BY | | RTR | |
| Cable-connection diagram =20-C-1002+UCP-C1002-01-SERA01 | | RBE | | = | |
| ADAPTED TO P&ID REVISION | 06 | LAST MODIFICATION DATE | CURRENT PAGE | | |
| CLIENT | Bushehr Petrochemical Company (BUPC) | AIRPACK DWG NO. | 17811-05 | | |
| CLIENT REF. | Bushehr MEG Plant Project | REVISION | 02 | | |
| AIRPACK REF. | 17811-30A | TOTAL PAGE AMOUNT | 12 | | |

| | | |
|-------------------|----------|---|
| CHECKED BY | RBE | + |
| AIRPACK DWG NO. | 17811-05 | |
| REVISION | 02 | |
| TOTAL PAGE AMOUNT | 12 | |

Internal targets

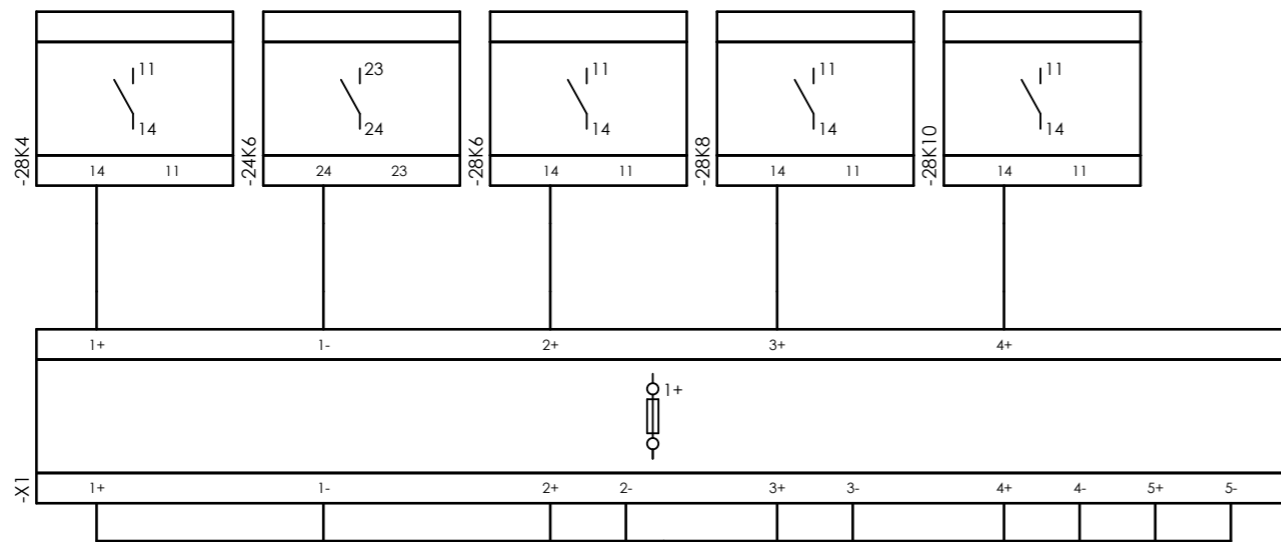

External targets

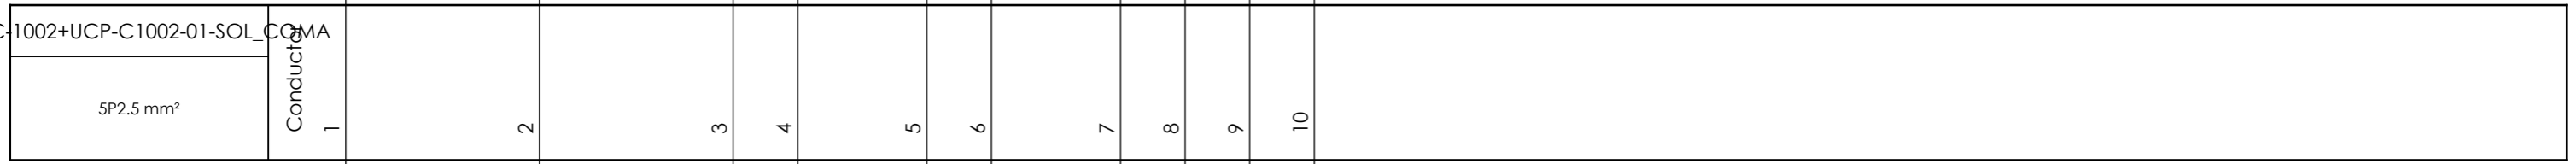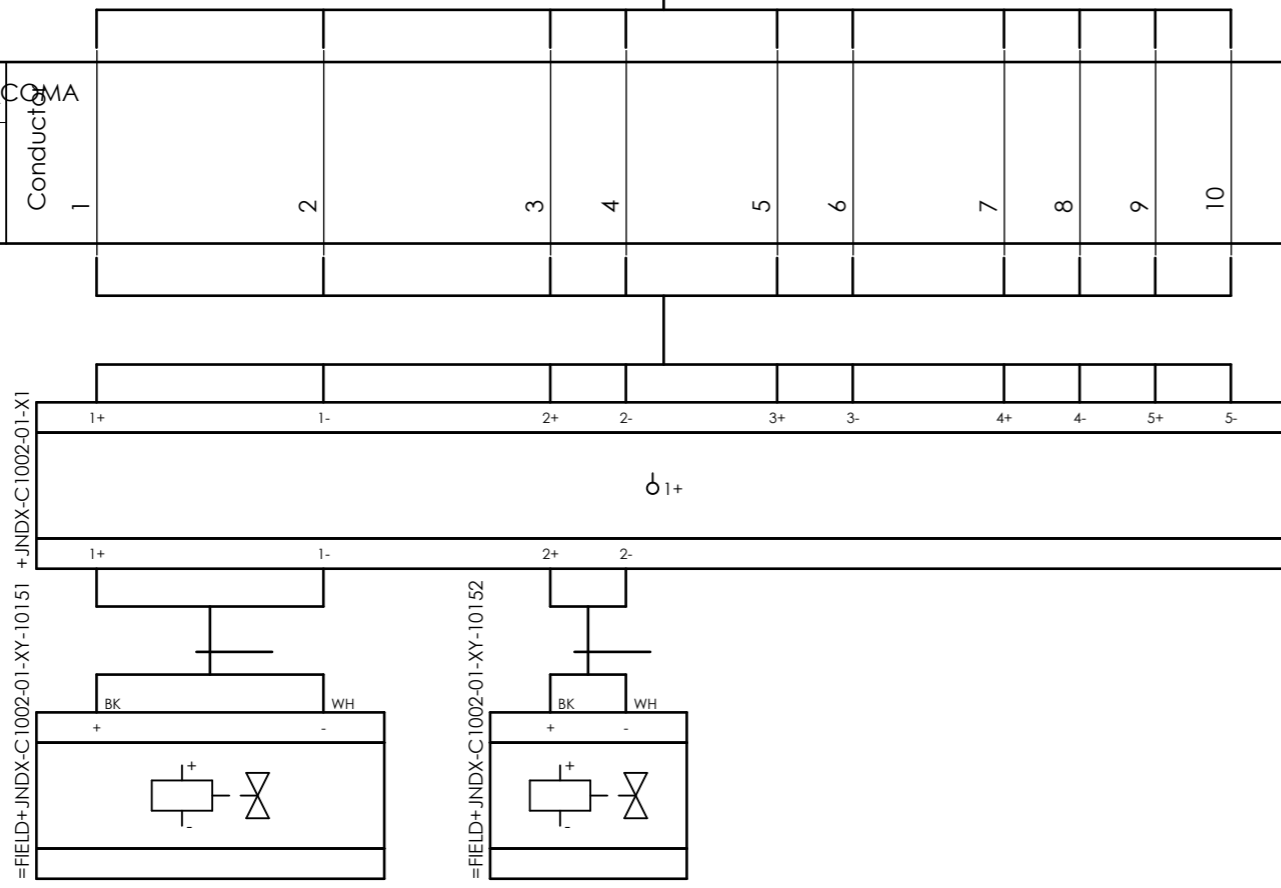


| | |
|--|--------------------------|
| CLIENT DWG NO. | BU-20-VD-303-IN-DIG-0043 |
| EQUIPMENT NO. | 20-C-1002 |
| EQUIPMENT LOCATION | Iran, Onshore |
| THIS DRAWING IS OWNED BY AIRPACK, AND SHALL NOT BE PRINTED OR COPIED IN ANY OTHER WAY THAN WITH AIRPACKS PERMISSION! | |


| | |
|--|--------------------------------------|
| SUBJECT Cable-connection diagram =20-C-1002+UCP-C1002-01-SOL_COMA | |
| ADAPTED TO P&ID REVISION | 06 |
| CLIENT | Bushehr Petrochemical Company (BUPC) |
| CLIENT REF. | Bushehr MEG Plant Project |
| AIRPACK REF. | 17811-30A |

| | | |
|------------------------|----------|--------------|
| DRAWN BY | RTR | = |
| CHECKED BY | RBE | + |
| LAST MODIFICATION DATE | | CURRENT PAGE |
| AIRPACK DWG NO. | 17811-05 | |
| REVISION | 02 | |
| TOTAL PAGE AMOUNT | 13 | |


Internal targets

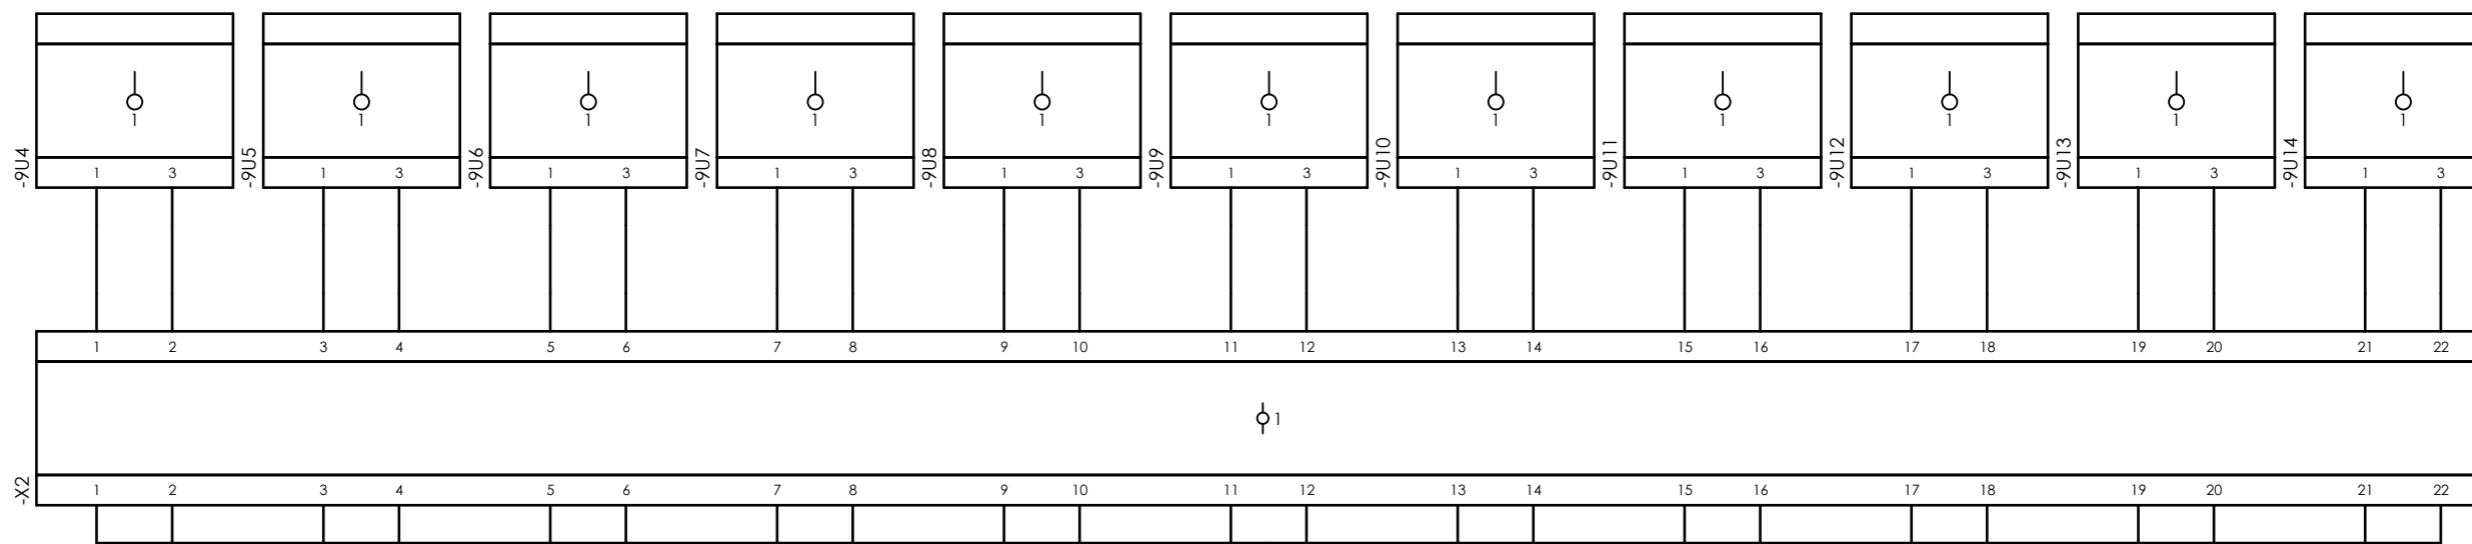

=20-C-1002+UCP-C1002-01-TR_COMA

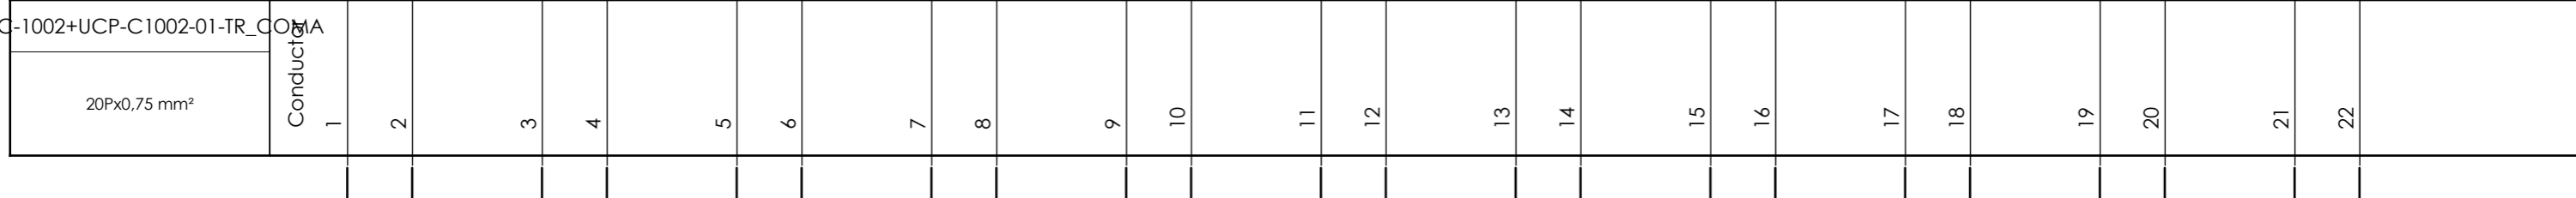

External targets

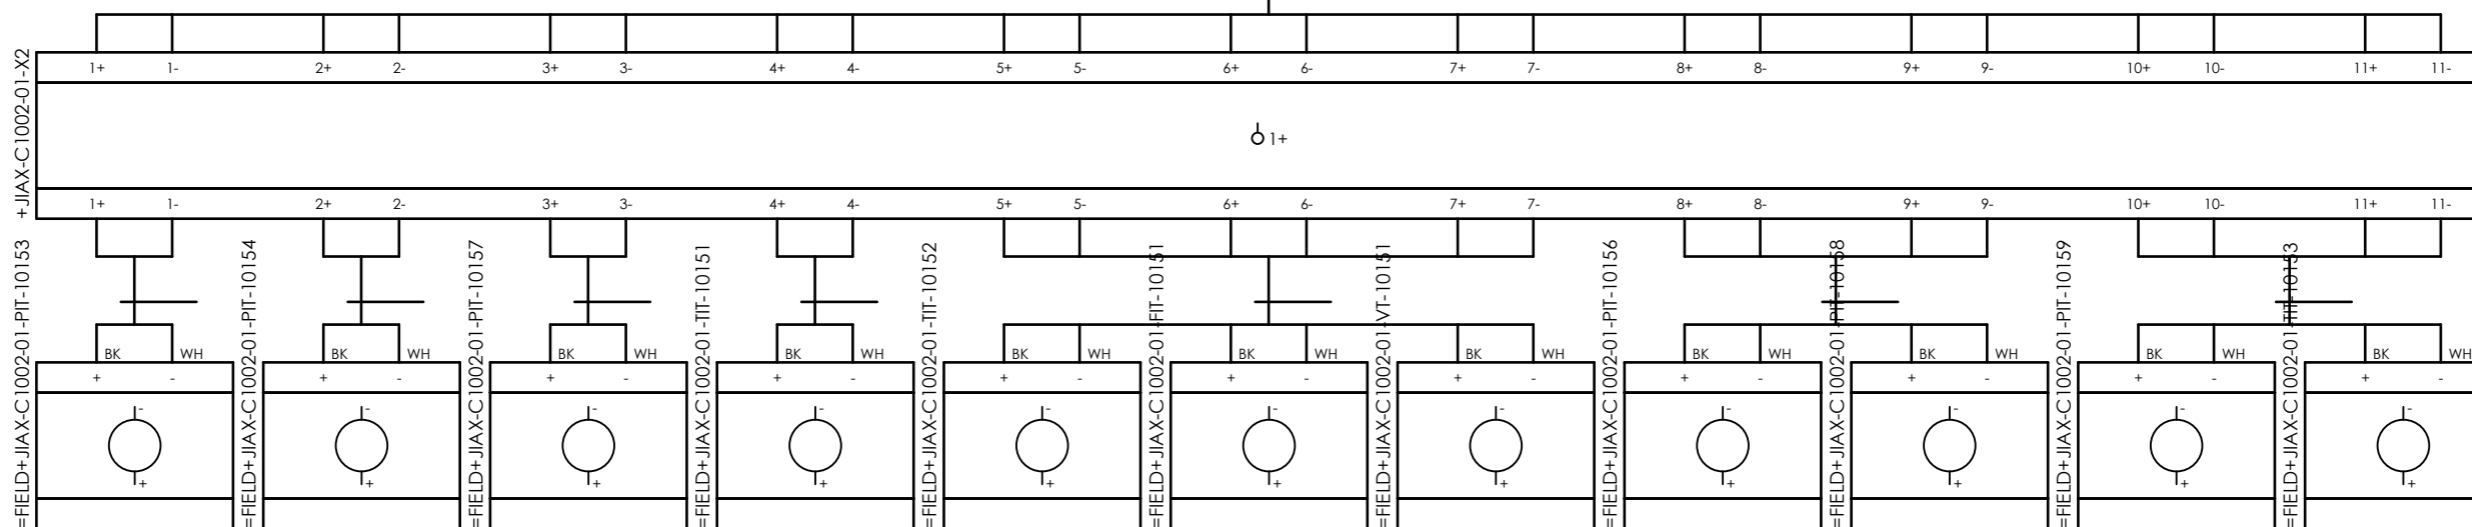


| | |
|--|--------------------------|
| CLIENT DWG NO. | BU-20-VD-303-IN-DIG-0043 |
| EQUIPMENT NO. | 20-C-1002 |
| EQUIPMENT LOCATION | Iran, Onshore |
| THIS DRAWING IS OWNED BY AIRPACK, AND SHALL NOT BE PRINTED OR COPIED IN ANY OTHER WAY THAN WITH AIRPACKS PERMISSION! | |


| | | | |
|--------------------------|--------------------------------------|--|--|
| SUBJECT | | Cable-connection diagram =20-C-1002+UCP-C1002-01-TR_COMA | |
| ADAPTED TO P&ID REVISION | 06 | | |
| CLIENT | Bushehr Petrochemical Company (BUPC) | | |
| CLIENT REF. | Bushehr MEG Plant Project | | |
| AIRPACK REF. | 17811-30A | | |

| | | |
|------------------------|----------|--------------|
| DRAWN BY | RTR | = |
| CHECKED BY | RBE | + |
| LAST MODIFICATION DATE | | CURRENT PAGE |
| AIRPACK DWG NO. | 17811-05 | |
| REVISION | 02 | |
| TOTAL PAGE AMOUNT | 14 | |


Internal targets

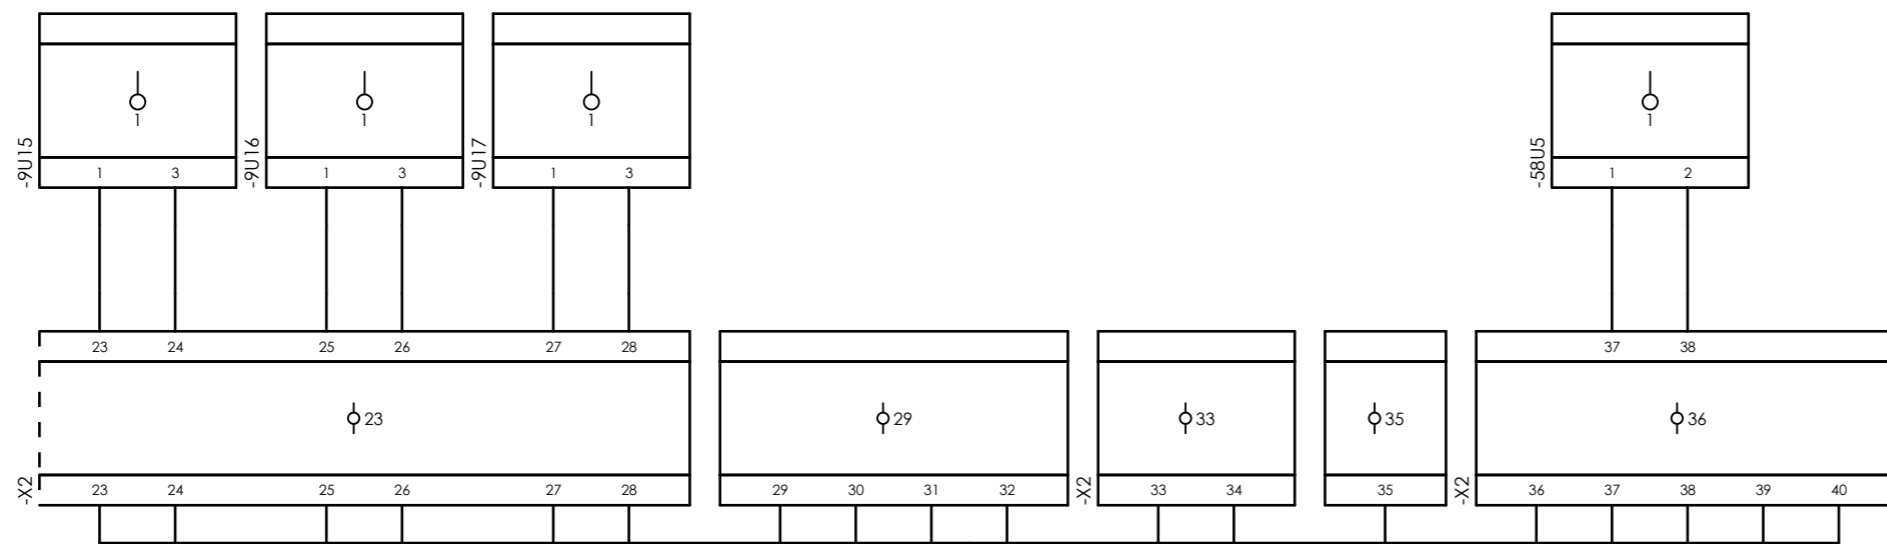

=20-C-1002+UCP-C1002-01-TR_COMA

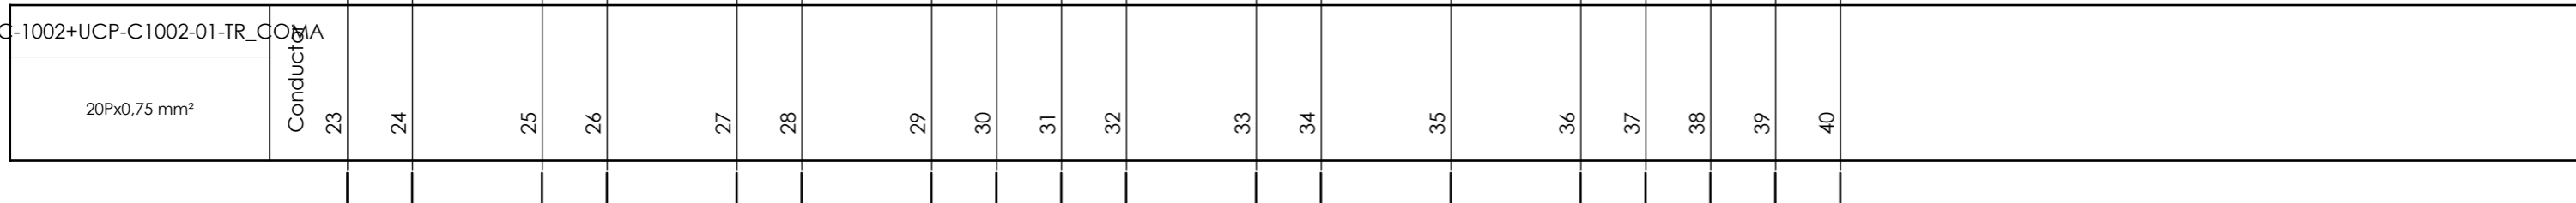



External targets

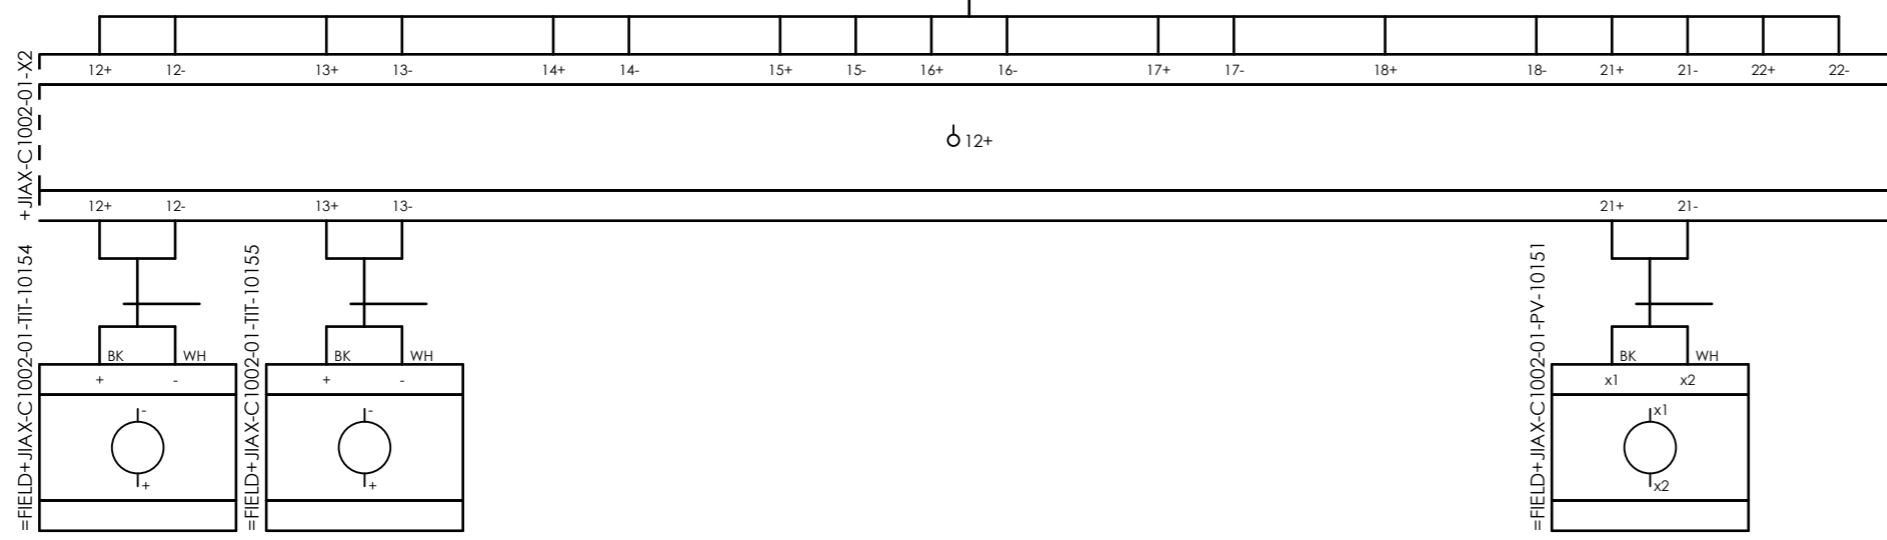




| | | | |
|--|--------------------------|--------------------------|--|
| CLIENT DWG NO. | BU-20-VD-303-IN-DIG-0043 | SUBJECT | Cable-connection diagram =20-C-1002+UCP-C1002-01-TR_COMA |
| EQUIPMENT NO. | 20-C-1002 | ADAPTED TO P&ID REVISION | 06 |
| EQUIPMENT LOCATION | Iran, Onshore | CLIENT | Bushehr Petrochemical Company (BUPC) |
| THIS DRAWING IS OWNED BY AIRPACK, AND SHALL NOT BE PRINTED OR COPIED IN ANY OTHER WAY THAN WITH AIRPACKS PERMISSION! | | CLIENT REF. | Bushehr MEG Plant Project |
| | | AIRPACK REF. | 17811-30A |

| | | |
|------------------------|----------|--------------|
| DRAWN BY | RTR | = |
| CHECKED BY | RBE | + |
| LAST MODIFICATION DATE | | CURRENT PAGE |
| AIRPACK DWG NO. | 17811-05 | |
| REVISION | 02 | |
| TOTAL PAGE AMOUNT | 15 | |

 Internal targets

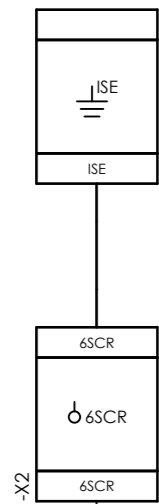

=20-C-1002+JIAX-C1002-01-FIT-10151

 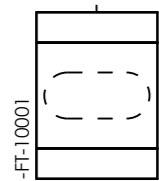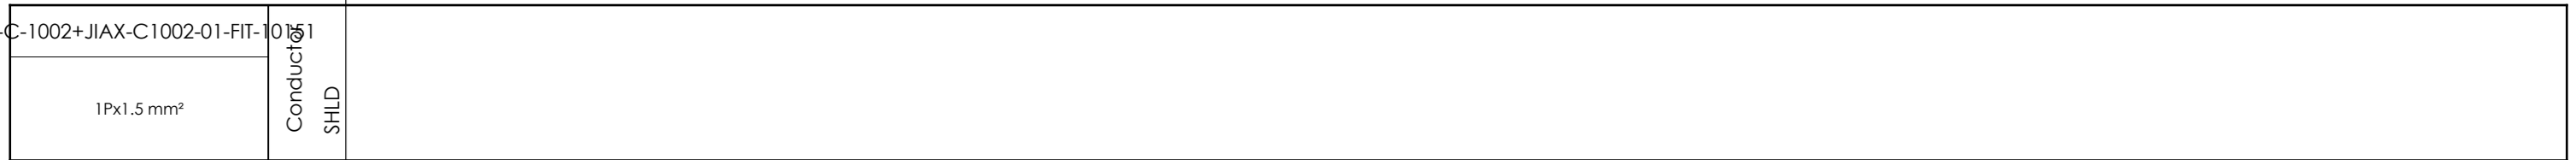

External targets




| | |
|--|--------------------------|
| CLIENT DWG NO. | BU-20-VD-303-IN-DIG-0043 |
| EQUIPMENT NO. | 20-C-1002 |
| EQUIPMENT LOCATION | Iran, Onshore |
| THIS DRAWING IS OWNED BY AIRPACK, AND SHALL NOT BE PRINTED OR COPIED IN ANY OTHER WAY THAN WITH AIRPACKS PERMISSION! | |

| | |
|---|--------------------------------------|
| SUBJECT | |
| Cable-connection diagram =20-C-1002+JIAX-C1002-01-FIT-10151 | |
| ADAPTED TO P&ID REVISION | 06 |
| CLIENT | Bushehr Petrochemical Company (BUPC) |
| CLIENT REF. | Bushehr MEG Plant Project |
| AIRPACK REF. | 17811-30A |

| | | |
|------------------------|----------|--------------|
| DRAWN BY | RTR | = |
| CHECKED BY | RBE | + |
| LAST MODIFICATION DATE | | CURRENT PAGE |
| AIRPACK DWG NO. | 17811-05 | |
| REVISION | 02 | |
| TOTAL PAGE AMOUNT | 16 | |


Internal targets

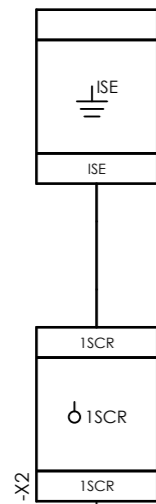


-X2



=20-C-1002+JIAX-C1002-01-PIT-10153

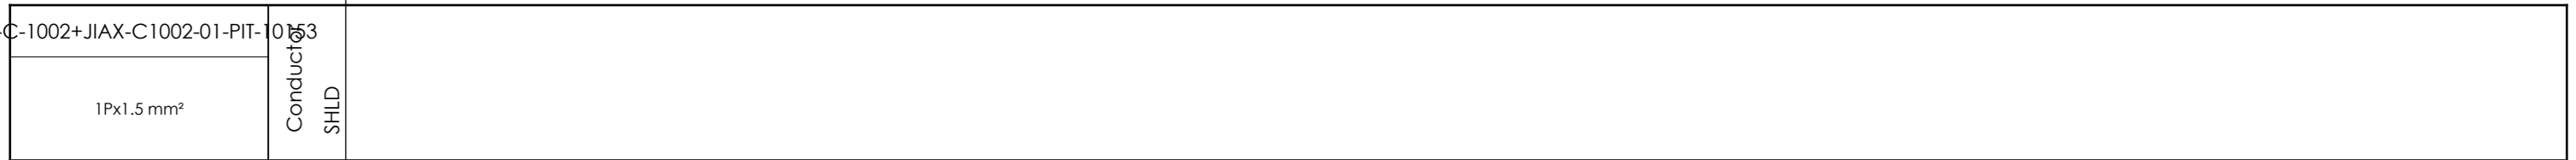

-PIT-10003

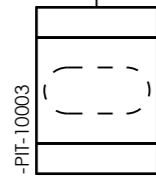

External targets





| | |
|--------------------|--------------------------|
| CLIENT DWG NO. | BU-20-VD-303-IN-DIG-0043 |
| EQUIPMENT NO. | 20-C-1002 |
| EQUIPMENT LOCATION | Iran, Onshore |

THIS DRAWING IS OWNED BY AIRPACK, AND SHALL NOT BE PRINTED OR COPIED IN ANY OTHER WAY THAN WITH AIRPACKS PERMISSION!



| | | | |
|--------------------------|---------------------------|---|--------------------------------------|
| SUBJECT | | Cable-connection diagram =20-C-1002+JIAX-C1002-01-PIT-10153 | |
| ADAPTED TO P&ID REVISION | 06 | CLIENT | Bushehr Petrochemical Company (BUPC) |
| CLIENT REF. | Bushehr MEG Plant Project | AIRPACK REF. | 17811-30A |

| | | |
|------------------------|----------|--------------|
| DRAWN BY | RTR | = |
| CHECKED BY | RBE | + |
| LAST MODIFICATION DATE | | CURRENT PAGE |
| AIRPACK DWG NO. | 17811-05 | |
| REVISION | 02 | |
| TOTAL PAGE AMOUNT | 17 | |

 Internal targets

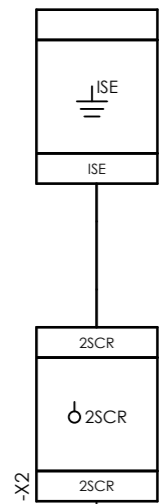

=20-C-1002+JIAX-C1002-01-PIT-10154

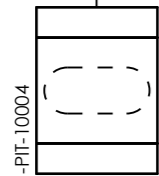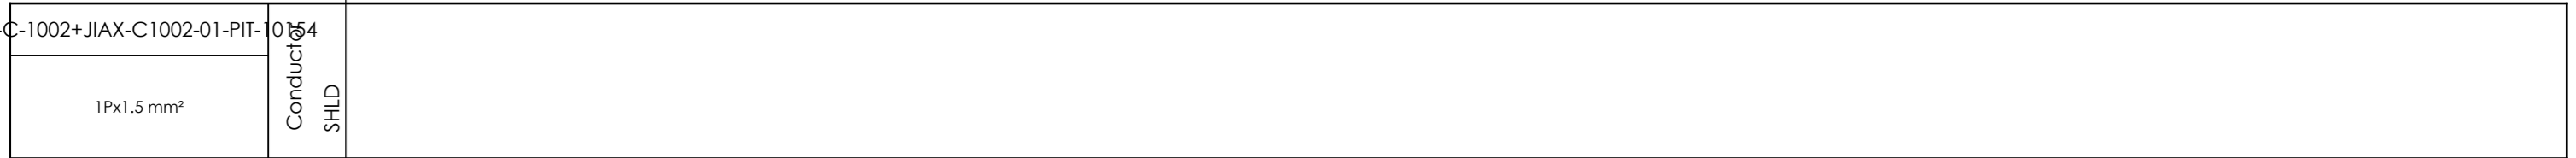

External targets




| | |
|--|--------------------------|
| CLIENT DWG NO. | BU-20-VD-303-IN-DIG-0043 |
| EQUIPMENT NO. | 20-C-1002 |
| EQUIPMENT LOCATION | Iran, Onshore |
| THIS DRAWING IS OWNED BY AIRPACK, AND SHALL NOT BE PRINTED OR COPIED IN ANY OTHER WAY THAN WITH AIRPACKS PERMISSION! | |



| | | | |
|--------------------------|---------------------------|---|--------------------------------------|
| SUBJECT | | Cable-connection diagram =20-C-1002+JIAX-C1002-01-PIT-10154 | |
| ADAPTED TO P&ID REVISION | 06 | CLIENT | Bushehr Petrochemical Company (BUPC) |
| CLIENT REF. | Bushehr MEG Plant Project | AIRPACK REF. | 17811-30A |

| | | |
|------------------------|----------|--------------|
| DRAWN BY | RTR | = |
| CHECKED BY | RBE | + |
| LAST MODIFICATION DATE | | CURRENT PAGE |
| AIRPACK DWG NO. | 17811-05 | |
| REVISION | 02 | |
| TOTAL PAGE AMOUNT | 18 | |

Internal targets

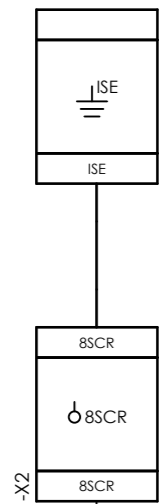

-X2

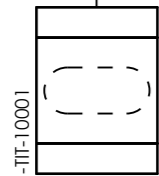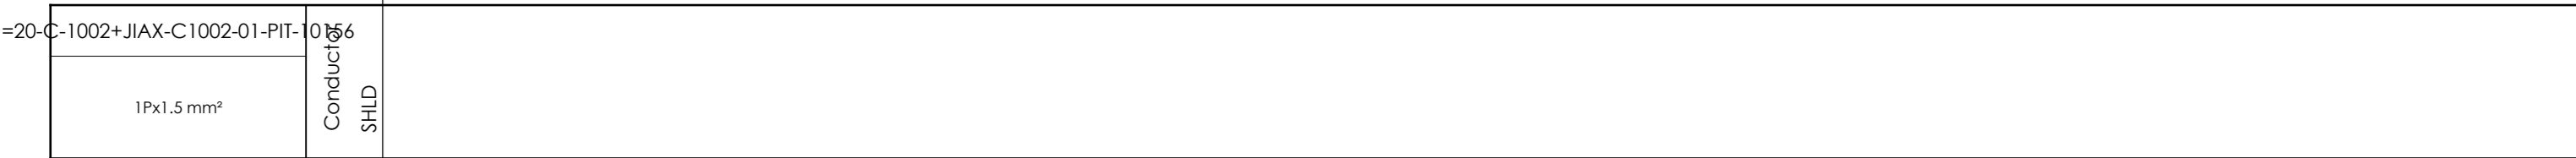

External targets





| | |
|--------------------|--------------------------|
| CLIENT DWG NO. | BU-20-VD-303-IN-DIG-0043 |
| EQUIPMENT NO. | 20-C-1002 |
| EQUIPMENT LOCATION | Iran, Onshore |

THIS DRAWING IS OWNED BY AIRPACK, AND SHALL NOT BE PRINTED OR COPIED IN ANY OTHER WAY THAN WITH AIRPACKS PERMISSION!


| | | | |
|--------------------------|---------------------------|---|--------------------------------------|
| SUBJECT | | Cable-connection diagram =20-C-1002+JIAX-C1002-01-PIT-10156 | |
| ADAPTED TO P&ID REVISION | 06 | CLIENT | Bushehr Petrochemical Company (BUPC) |
| CLIENT REF. | Bushehr MEG Plant Project | AIRPACK REF. | 17811-30A |

| | | |
|------------------------|----------|--------------|
| DRAWN BY | RTR | = |
| CHECKED BY | RBE | + |
| LAST MODIFICATION DATE | | CURRENT PAGE |
| AIRPACK DWG NO. | 17811-05 | |
| REVISION | 02 | |
| TOTAL PAGE AMOUNT | 19 | |

Internal targets

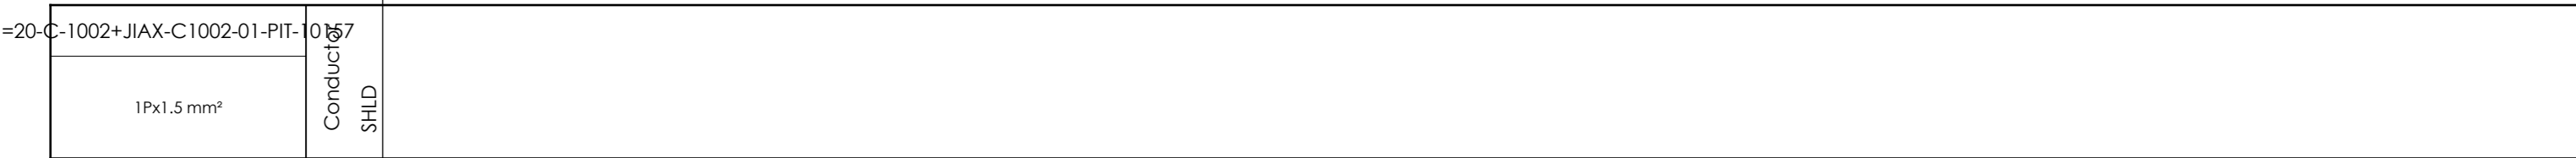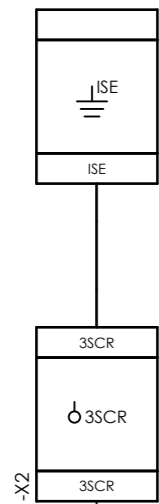

External targets

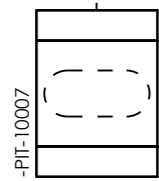


| | |
|--|--------------------------|
| CLIENT DWG NO. | BU-20-VD-303-IN-DIG-0043 |
| EQUIPMENT NO. | 20-C-1002 |
| EQUIPMENT LOCATION | Iran, Onshore |
| THIS DRAWING IS OWNED BY AIRPACK, AND SHALL NOT BE PRINTED OR COPIED IN ANY OTHER WAY THAN WITH AIRPACKS PERMISSION! | |

| | | |
|--------------------------|--------------------------------------|---|
| SUBJECT | | Cable-connection diagram =20-C-1002+JIAX-C1002-01-PIT-10157 |
| ADAPTED TO P&ID REVISION | 06 | |
| CLIENT | Bushehr Petrochemical Company (BUPC) | |
| CLIENT REF. | Bushehr MEG Plant Project | |
| AIRPACK REF. | 17811-30A | |

| | | |
|------------------------|----------|---|
| DRAWN BY | RTR | = |
| CHECKED BY | RBE | + |
| LAST MODIFICATION DATE | | |
| AIRPACK DWG NO. | 17811-05 | |
| REVISION | 02 | |
| TOTAL PAGE AMOUNT | 20 | |

| | |
|--------------|--|
| CURRENT PAGE | |
| 20 | |

Internal targets

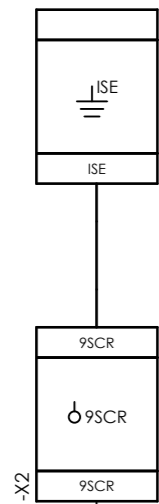


X2

=20-C-1002+JIAX-C1002-01-PIT-10158



-TIT-10001

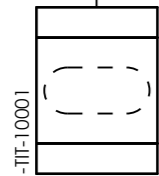

External targets





| | |
|--|--------------------------|
| CLIENT DWG NO. | BU-20-VD-303-IN-DIG-0043 |
| EQUIPMENT NO. | 20-C-1002 |
| EQUIPMENT LOCATION | Iran, Onshore |
| THIS DRAWING IS OWNED BY AIRPACK, AND SHALL NOT BE PRINTED OR COPIED IN ANY OTHER WAY THAN WITH AIRPACKS PERMISSION! | |


| | | | |
|--------------------------|---------------------------|---|--------------------------------------|
| SUBJECT | | Cable-connection diagram =20-C-1002+JIAX-C1002-01-PIT-10158 | |
| ADAPTED TO P&ID REVISION | 06 | CLIENT | Bushehr Petrochemical Company (BUPC) |
| CLIENT REF. | Bushehr MEG Plant Project | AIRPACK REF. | 17811-30A |

| | | |
|------------------------|----------|--------------|
| DRAWN BY | RTR | = |
| CHECKED BY | RBE | + |
| LAST MODIFICATION DATE | | CURRENT PAGE |
| AIRPACK DWG NO. | 17811-05 | |
| REVISION | 02 | |
| TOTAL PAGE AMOUNT | 21 | |

Internal targets

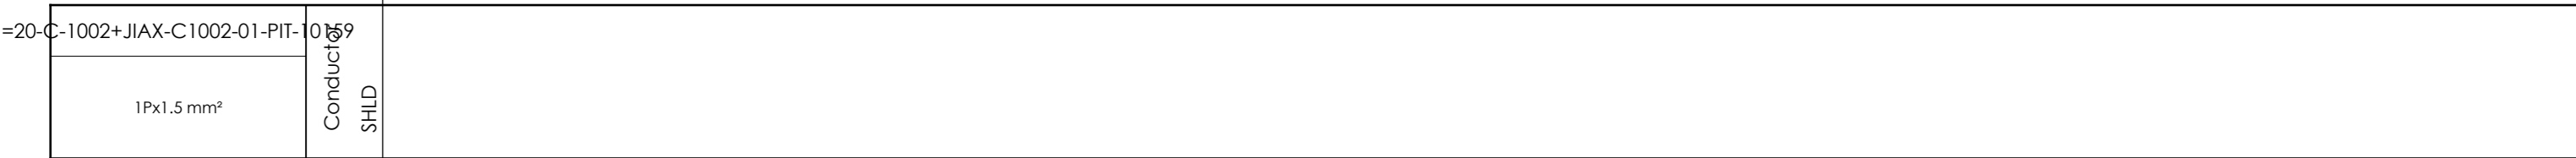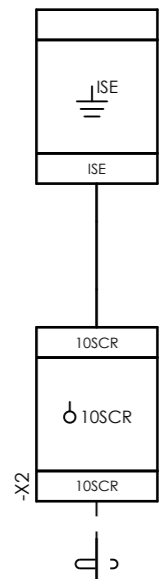

External targets

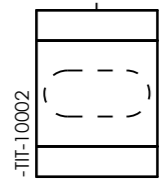


| | |
|--|--------------------------|
| CLIENT DWG NO. | BU-20-VD-303-IN-DIG-0043 |
| EQUIPMENT NO. | 20-C-1002 |
| EQUIPMENT LOCATION | Iran, Onshore |
| THIS DRAWING IS OWNED BY AIRPACK, AND SHALL NOT BE PRINTED OR COPIED IN ANY OTHER WAY THAN WITH AIRPACKS PERMISSION! | |


| | | | |
|--------------------------|---------------------------|---|--------------------------------------|
| SUBJECT | | Cable-connection diagram =20-C-1002+JIAX-C1002-01-PIT-10159 | |
| ADAPTED TO P&ID REVISION | 06 | CLIENT | Bushehr Petrochemical Company (BUPC) |
| CLIENT REF. | Bushehr MEG Plant Project | AIRPACK REF. | 17811-30A |

| | | |
|------------------------|----------|--------------|
| DRAWN BY | RTR | = |
| CHECKED BY | RBE | + |
| LAST MODIFICATION DATE | | CURRENT PAGE |
| AIRPACK DWG NO. | 17811-05 | |
| REVISION | 02 | |
| TOTAL PAGE AMOUNT | 22 | |

Internal targets

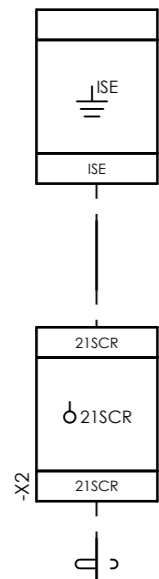

=20-C-1002+JIAX-C1002-01-PV-10151
 Conductor
 SHLD
 1Px1.5 mm²

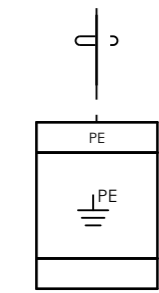

External targets





| | |
|--|--------------------------|
| CLIENT DWG NO. | BU-20-VD-303-IN-DIG-0043 |
| EQUIPMENT NO. | 20-C-1002 |
| EQUIPMENT LOCATION | Iran, Onshore |
| THIS DRAWING IS OWNED BY AIRPACK, AND SHALL NOT BE PRINTED OR COPIED IN ANY OTHER WAY THAN WITH AIRPACKS PERMISSION! | |




| | |
|---|--------------------------------------|
| SUBJECT Cable-connection diagram =20-C-1002+JIAX-C1002-01-PV-10151 | |
| ADAPTED TO P&ID REVISION | 06 |
| CLIENT | Bushehr Petrochemical Company (BUPC) |
| CLIENT REF. | Bushehr MEG Plant Project |
| AIRPACK REF. | 17811-30A |

| | | |
|------------------------|----------|--------------|
| DRAWN BY | RTR | = |
| CHECKED BY | RBE | + |
| LAST MODIFICATION DATE | | CURRENT PAGE |
| AIRPACK DWG NO. | 17811-05 | |
| REVISION | 02 | |
| TOTAL PAGE AMOUNT | 23 | |

 Internal targets

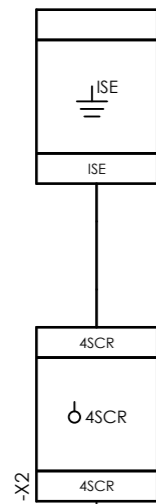

=20-C-1002+JIAX-C1002-01-TIT-10151

 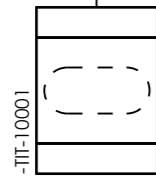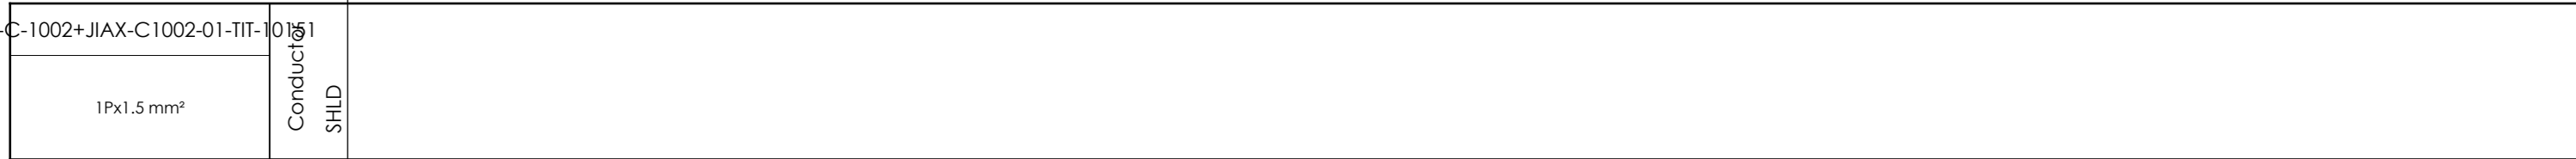

External targets



| | |
|--------------------|--------------------------|
| CLIENT DWG NO. | BU-20-VD-303-IN-DIG-0043 |
| EQUIPMENT NO. | 20-C-1002 |
| EQUIPMENT LOCATION | Iran, Onshore |

| | |
|---|----|
| SUBJECT | |
| Cable-connection diagram =20-C-1002+JIAX-C1002-01-TIT-10151 | |
| ADAPTED TO P&ID REVISION | 06 |

| | | |
|------------------------|-----|---|
| DRAWN BY | RTR | = |
| CHECKED BY | RBE | + |
| LAST MODIFICATION DATE | | |



THIS DRAWING IS OWNED BY AIRPACK, AND SHALL NOT BE PRINTED OR COPIED IN ANY OTHER WAY THAN WITH AIRPACKS PERMISSION!

| | |
|--------------|--------------------------------------|
| CLIENT | Bushehr Petrochemical Company (BUPC) |
| CLIENT REF. | Bushehr MEG Plant Project |
| AIRPACK REF. | 17811-30A |



| | |
|-------------------|----------|
| AIRPACK DWG NO. | 17811-05 |
| REVISION | 02 |
| TOTAL PAGE AMOUNT | 24 |

CURRENT PAGE

 Internal targets

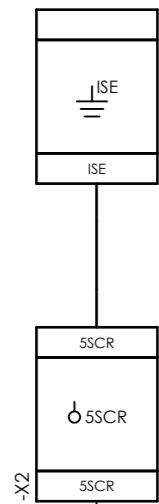

=20-C-1002+JIAX-C1002-01-TIT-10152

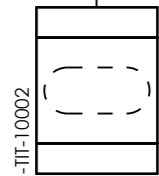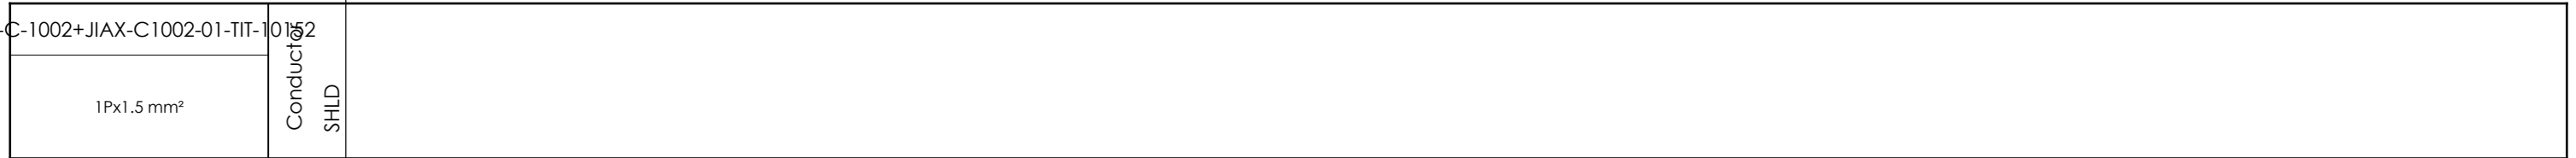

External targets



| | |
|--------------------|--------------------------|
| CLIENT DWG NO. | BU-20-VD-303-IN-DIG-0043 |
| EQUIPMENT NO. | 20-C-1002 |
| EQUIPMENT LOCATION | Iran, Onshore |

| | |
|---|----|
| SUBJECT | |
| Cable-connection diagram =20-C-1002+JIAX-C1002-01-TIT-10152 | |
| ADAPTED TO P&ID REVISION | 06 |




| | | |
|------------------------|-----|--------------|
| DRAWN BY | RTR | = |
| CHECKED BY | RBE | + |
| LAST MODIFICATION DATE | | CURRENT PAGE |

THIS DRAWING IS OWNED BY AIRPACK, AND SHALL NOT BE PRINTED OR COPIED IN ANY OTHER WAY THAN WITH AIRPACKS PERMISSION!

| | |
|--------------|--------------------------------------|
| CLIENT | Bushehr Petrochemical Company (BUPC) |
| CLIENT REF. | Bushehr MEG Plant Project |
| AIRPACK REF. | 17811-30A |

| | |
|-------------------|----------|
| AIRPACK DWG NO. | 17811-05 |
| REVISION | 02 |
| TOTAL PAGE AMOUNT | 25 |

 Internal targets

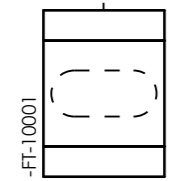
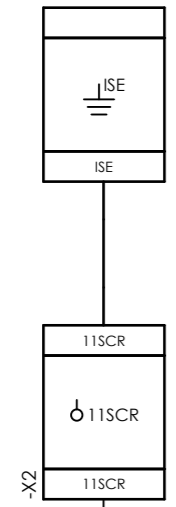


External targets






| | | | | | | |
|--|--------------------------|---|--------------------------------------|------------------------|----------|--------------|
| CLIENT DWG NO. | BU-20-VD-303-IN-DIG-0043 | SUBJECT | | DRAWN BY | RTR | = |
| EQUIPMENT NO. | 20-C-1002 | Cable-connection diagram =20-C-1002+JIAX-C1002-01-TIT-10153 | | CHECKED BY | RBE | + |
| EQUIPMENT LOCATION | Iran, Onshore | ADAPTED TO P&ID REVISION | 06 | LAST MODIFICATION DATE | | CURRENT PAGE |
| THIS DRAWING IS OWNED BY AIRPACK, AND SHALL NOT BE PRINTED OR COPIED IN ANY OTHER WAY THAN WITH AIRPACKS PERMISSION! | | CLIENT | Bushehr Petrochemical Company (BUPC) | AIRPACK DWG NO. | 17811-05 | |
| | | CLIENT REF. | Bushehr MEG Plant Project | REVISION | 02 | |
| | | AIRPACK REF. | 17811-30A | TOTAL PAGE AMOUNT | 26 | |

 Internal targets

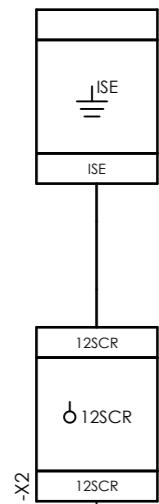

=20-C-1002+JIAX-C1002-01-TIT-10154

 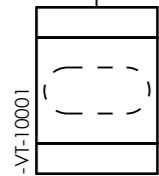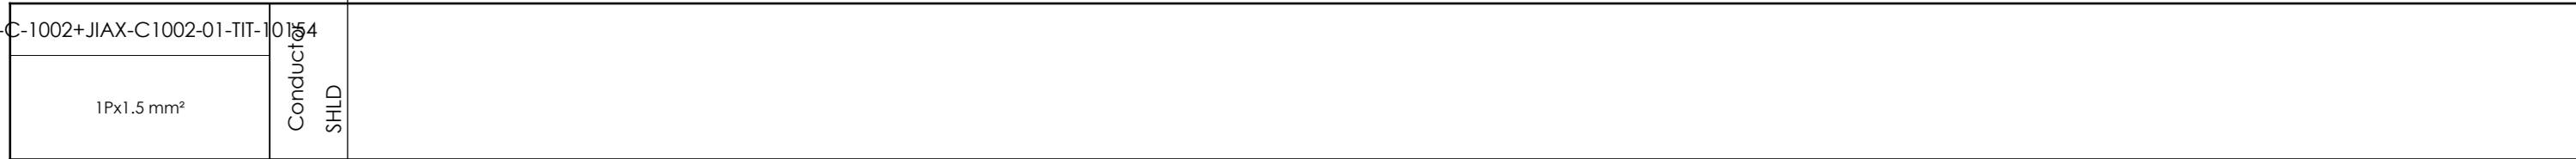

External targets





| | |
|--|--------------------------|
| CLIENT DWG NO. | BU-20-VD-303-IN-DIG-0043 |
| EQUIPMENT NO. | 20-C-1002 |
| EQUIPMENT LOCATION | Iran, Onshore |
| THIS DRAWING IS OWNED BY AIRPACK, AND SHALL NOT BE PRINTED OR COPIED IN ANY OTHER WAY THAN WITH AIRPACKS PERMISSION! | |



| | |
|--|--------------------------------------|
| SUBJECT Cable-connection diagram =20-C-1002+JIAX-C1002-01-TIT-10154 | |
| ADAPTED TO P&ID REVISION | 06 |
| CLIENT | Bushehr Petrochemical Company (BUPC) |
| CLIENT REF. | Bushehr MEG Plant Project |
| AIRPACK REF. | 17811-30A |

| | | |
|------------------------|----------|--------------|
| DRAWN BY | RTR | = |
| CHECKED BY | RBE | + |
| LAST MODIFICATION DATE | | CURRENT PAGE |
| AIRPACK DWG NO. | 17811-05 | |
| REVISION | 02 | |
| TOTAL PAGE AMOUNT | 27 | |

 Internal targets

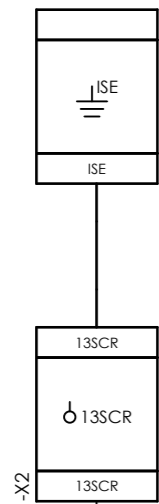

=20-C-1002+JIAX-C1002-01-TIT-10155

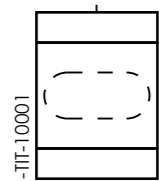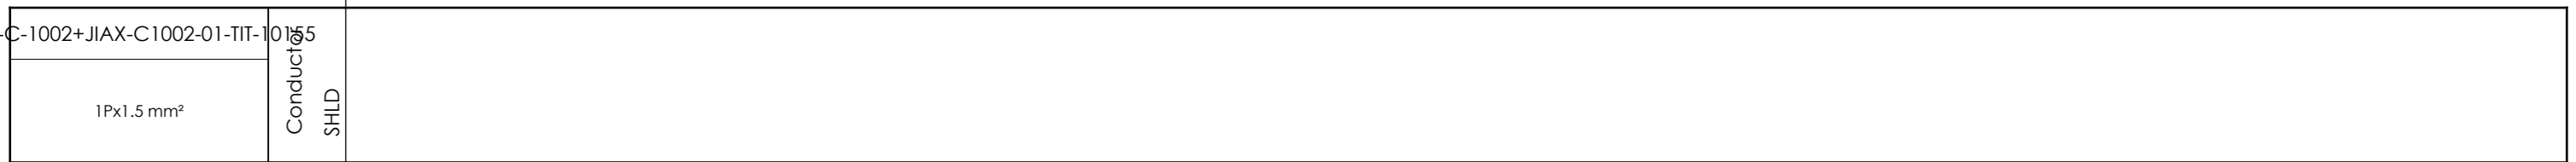

External targets




| | |
|--|--------------------------|
| CLIENT DWG NO. | BU-20-VD-303-IN-DIG-0043 |
| EQUIPMENT NO. | 20-C-1002 |
| EQUIPMENT LOCATION | Iran, Onshore |
| THIS DRAWING IS OWNED BY AIRPACK, AND SHALL NOT BE PRINTED OR COPIED IN ANY OTHER WAY THAN WITH AIRPACKS PERMISSION! | |

| | | | |
|--------------------------|---------------------------|---|--------------------------------------|
| SUBJECT | | Cable-connection diagram =20-C-1002+JIAX-C1002-01-TIT-10155 | |
| ADAPTED TO P&ID REVISION | 06 | CLIENT | Bushehr Petrochemical Company (BUPC) |
| CLIENT REF. | Bushehr MEG Plant Project | AIRPACK REF. | 17811-30A |

| | | |
|------------------------|----------|--------------|
| DRAWN BY | RTR | = |
| CHECKED BY | RBE | + |
| LAST MODIFICATION DATE | | CURRENT PAGE |
| AIRPACK DWG NO. | 17811-05 | |
| REVISION | 02 | |
| TOTAL PAGE AMOUNT | 28 | |



Internal targets

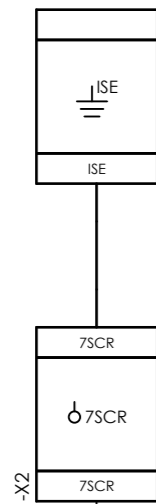

-X2



=20-C-1002+JIAX-C1002-01-VT-10151

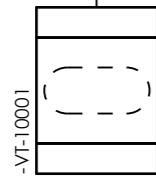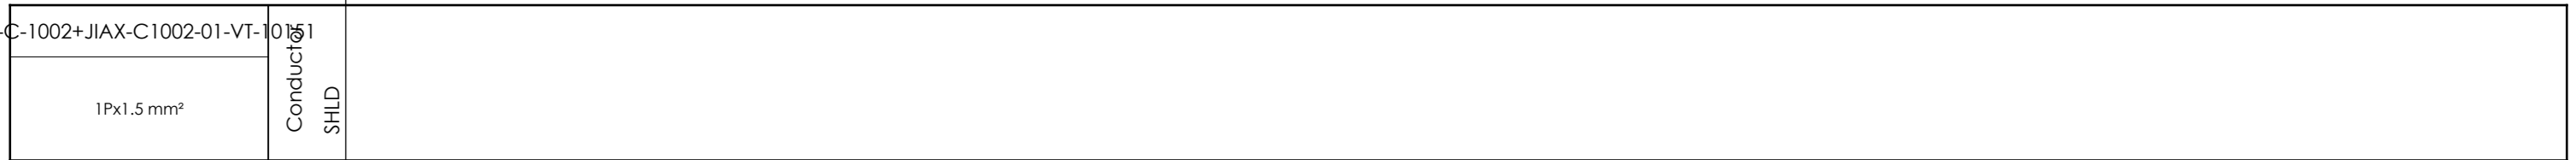

External targets




| | |
|--------------------|--------------------------|
| CLIENT DWG NO. | BU-20-VD-303-IN-DIG-0043 |
| EQUIPMENT NO. | 20-C-1002 |
| EQUIPMENT LOCATION | Iran, Onshore |

THIS DRAWING IS OWNED BY AIRPACK, AND SHALL NOT BE PRINTED OR COPIED IN ANY OTHER WAY THAN WITH AIRPACKS PERMISSION!


| | | | |
|--------------------------|---------------------------|--|--------------------------------------|
| SUBJECT | | Cable-connection diagram =20-C-1002+JIAX-C1002-01-VT-10151 | |
| ADAPTED TO P&ID REVISION | 06 | CLIENT | Bushehr Petrochemical Company (BUPC) |
| CLIENT REF. | Bushehr MEG Plant Project | AIRPACK REF. | 17811-30A |

| | | |
|------------------------|----------|--------------|
| DRAWN BY | RTR | = |
| CHECKED BY | RBE | + |
| LAST MODIFICATION DATE | | CURRENT PAGE |
| AIRPACK DWG NO. | 17811-05 | |
| REVISION | 02 | |
| TOTAL PAGE AMOUNT | 29 | |

Internal targets

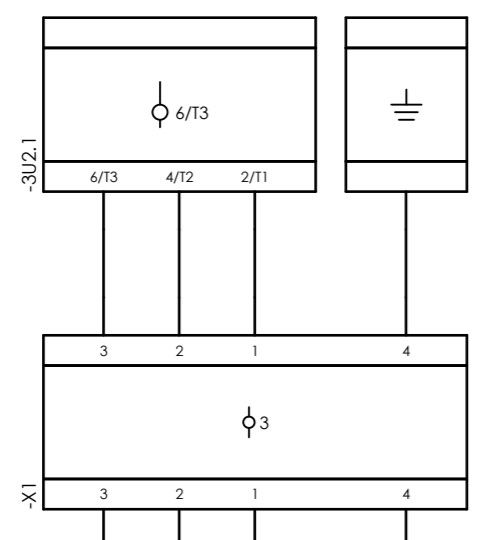

External targets

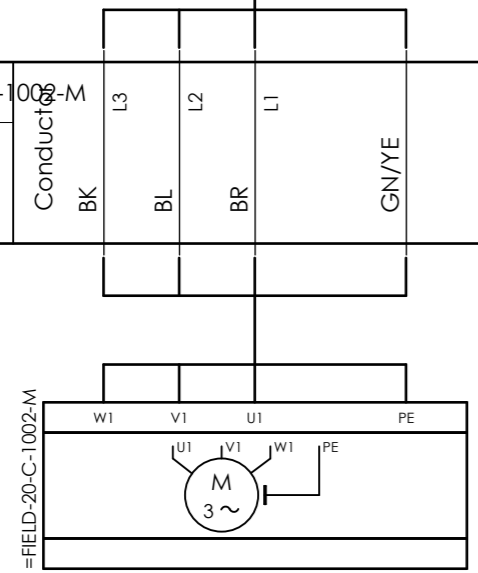


| | |
|--|--------------------------|
| CLIENT DWG NO. | BU-20-VD-303-IN-DIG-0043 |
| EQUIPMENT NO. | 20-C-1002 |
| EQUIPMENT LOCATION | Iran, Onshore |
| THIS DRAWING IS OWNED BY AIRPACK, AND SHALL NOT BE PRINTED OR COPIED IN ANY OTHER WAY THAN WITH AIRPACKS PERMISSION! | |


| | |
|---|--------------------------------------|
| SUBJECT Cable-connection diagram =20-C-1002+PD-C-1002-01-20-C-1002-M | |
| ADAPTED TO P&ID REVISION | 06 |
| CLIENT | Bushehr Petrochemical Company (BUPC) |
| CLIENT REF. | Bushehr MEG Plant Project |
| AIRPACK REF. | 17811-30A |

| | | |
|------------------------|----------|--------------|
| DRAWN BY | RTR | = |
| CHECKED BY | RBE | + |
| LAST MODIFICATION DATE | | CURRENT PAGE |
| AIRPACK DWG NO. | 17811-05 | |
| REVISION | 02 | |
| TOTAL PAGE AMOUNT | 30 | |

Internal targets

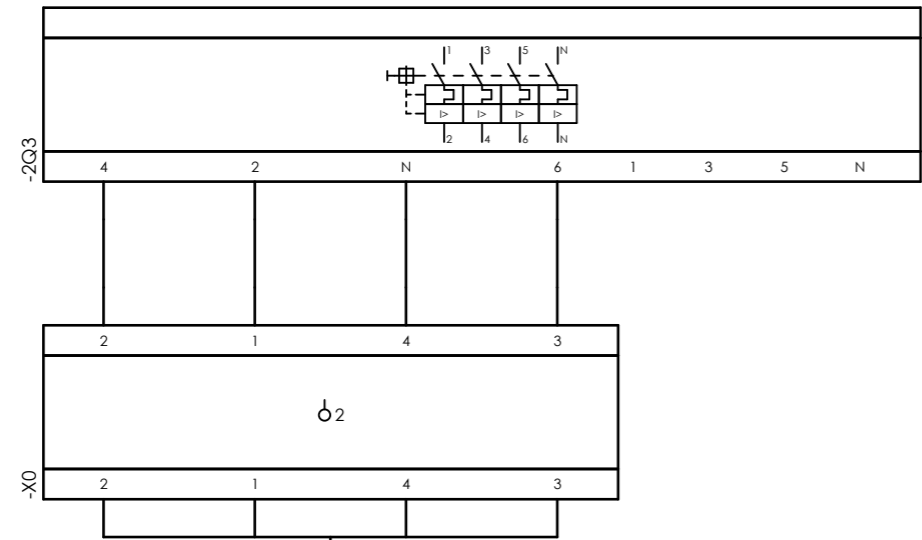

External targets

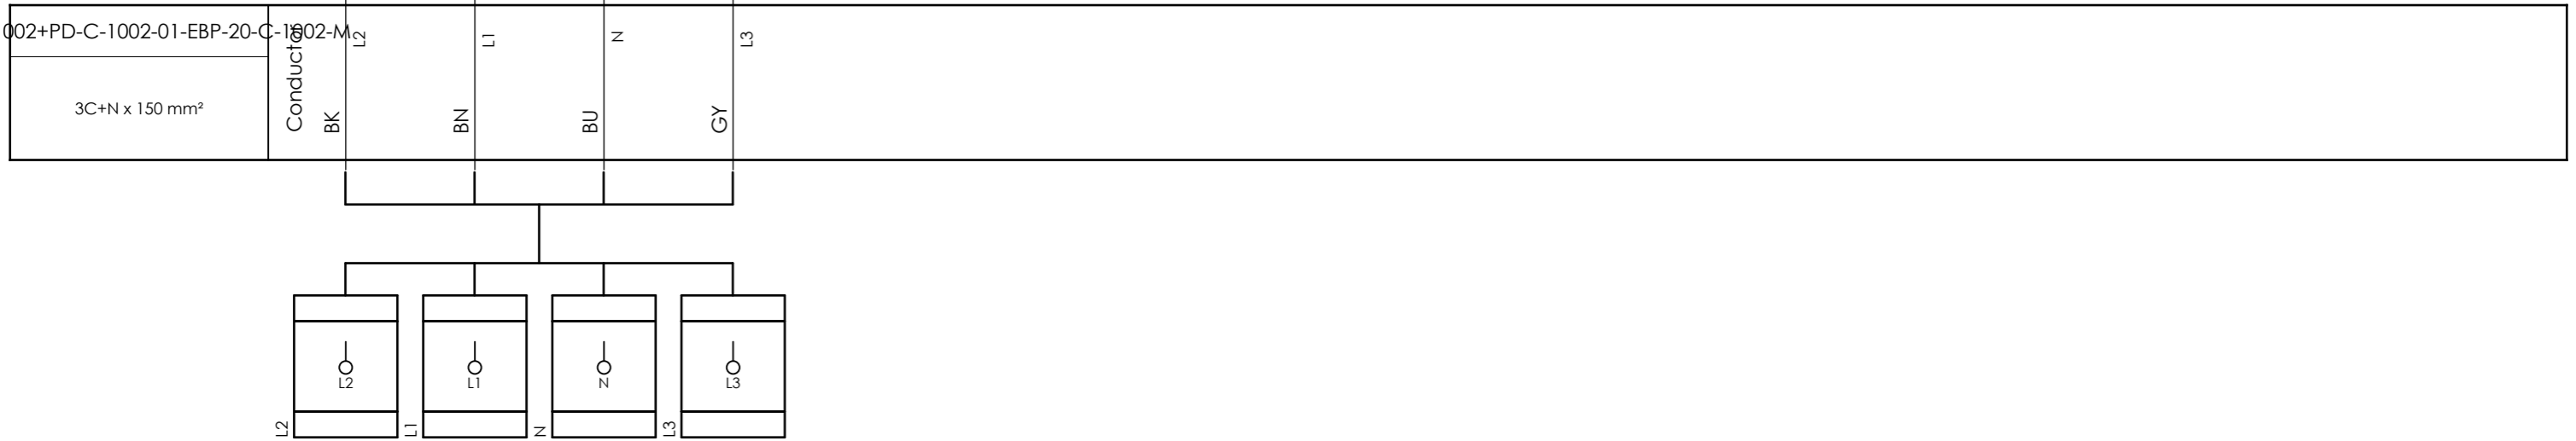


| | |
|--|--------------------------|
| CLIENT DWG NO. | BU-20-VD-303-IN-DIG-0043 |
| EQUIPMENT NO. | 20-C-1002 |
| EQUIPMENT LOCATION | Iran, Onshore |
| THIS DRAWING IS OWNED BY AIRPACK, AND SHALL NOT BE PRINTED OR COPIED IN ANY OTHER WAY THAN WITH AIRPACKS PERMISSION! | |

| | | |
|--------------------------|--------------------------------------|--|
| SUBJECT | | Cable-connection diagram =20-C-1002+PD-C-1002-01-EBP-20-C-1002-M |
| ADAPTED TO P&ID REVISION | 06 | |
| CLIENT | Bushehr Petrochemical Company (BUPC) | |
| CLIENT REF. | Bushehr MEG Plant Project | |
| AIRPACK REF. | 17811-30A | |


| | | |
|------------------------|----------|---|
| DRAWN BY | RTR | = |
| CHECKED BY | RBE | + |
| LAST MODIFICATION DATE | | |
| AIRPACK DWG NO. | 17811-05 | |
| REVISION | 02 | |
| TOTAL PAGE AMOUNT | 31 | |

| | |
|--------------|--|
| CURRENT PAGE | |
|--------------|--|


Internal targets

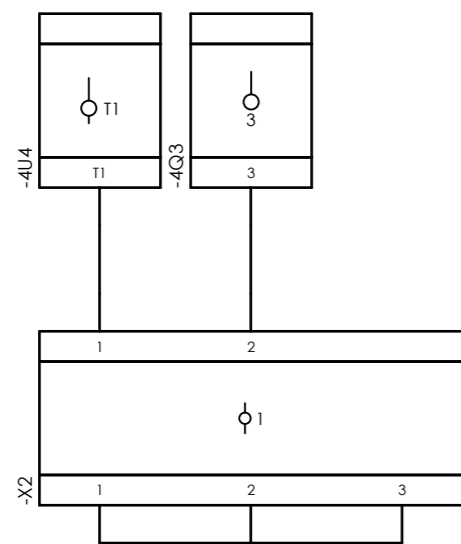

=20-C-1002+PD-C-1002-01-LG-10151

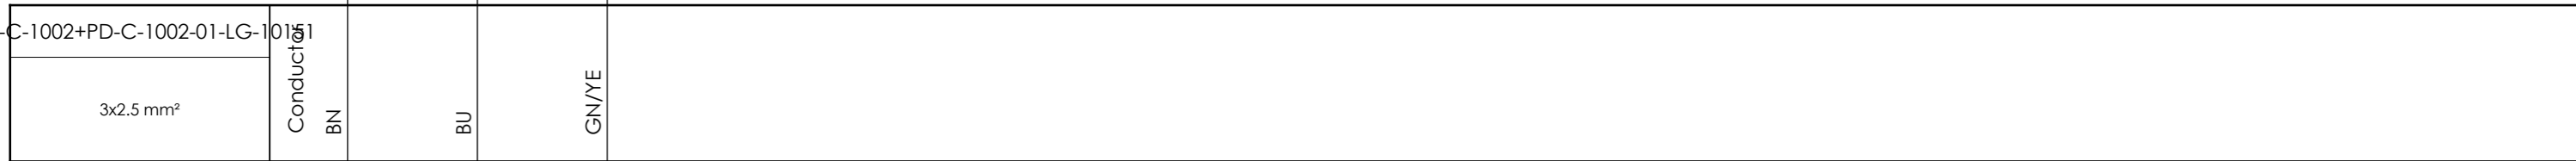

External targets

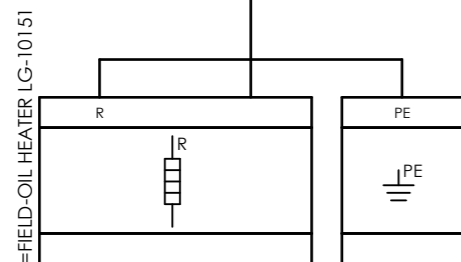

| | |
|--|--------------------------|
| CLIENT DWG NO. | BU-20-VD-303-IN-DIG-0043 |
| EQUIPMENT NO. | 20-C-1002 |
| EQUIPMENT LOCATION | Iran, Onshore |
| THIS DRAWING IS OWNED BY AIRPACK, AND SHALL NOT BE PRINTED OR COPIED IN ANY OTHER WAY THAN WITH AIRPACKS PERMISSION! | |

| | | | |
|--------------------------|---------------------------|---|--------------------------------------|
| SUBJECT | | Cable-connection diagram =20-C-1002+PD-C-1002-01-LG-10151 | |
| ADAPTED TO P&ID REVISION | 06 | CLIENT | Bushehr Petrochemical Company (BUPC) |
| CLIENT REF. | Bushehr MEG Plant Project | AIRPACK REF. | 17811-30A |

| | | |
|------------------------|----------|--------------|
| DRAWN BY | RTR | = |
| CHECKED BY | RBE | + |
| LAST MODIFICATION DATE | | CURRENT PAGE |
| AIRPACK DWG NO. | 17811-05 | |
| REVISION | 02 | |
| TOTAL PAGE AMOUNT | 32 | |

