







OWNER:  شرکت سست و سویی آرمینان (سهامی خاص)	BUSHEHR PETROCHEMICAL COMPANY MEG PLANT						EPC CONTRACTOR:  Chagalesh-Enerchimi-Steam Joint Venture BUPC-MEG PLANT PROJECT		
MC :  شرکت سست و سویی آرمینان (سهامی خاص)	LOOP DIAGRAM FOR EMERGENCY INSTRUMENT AIR COMPRESSOR								
Owner Document Number: 17811-30B							Project	Area	Phase
	BU	20	VD	303	IN	DIG	0086	Rev.: 02	Page 1 of 24

LOOP DIAGRAM FOR EMERGENCY INSTRUMENT AIR COMPRESSOR

 شرکت سست و سویی آرمینان توسعه ایرانیان	 Chagalesh-Enerchimi-Steam Joint Venture BUPC-MEG PLANT PROJECT	BUSHEHR PETROCHEMICAL COMPANY MEG PLANT
Document Review		
Issue Purpose:	AFC	
Result Code: AP,AN,CM,RE,NC	AP	
Next Status : IFC,IFA,IFI,AFC,AB	-	
Responsible Department	MECHANICAL	
Commented Date	Sep/18/2022	
Approval or review hereunder shall not be construed to relieve Vendor / Subcontractor of his responsibilities and liability under the contract.		

02	05/09/2022	Approved for Construction	RT	KP	JR	
01	15/07/2022	For approval	MG	RB	KP	
00	18/10/2021	For approval	HT	KP	JR	
Rev.	Date	Purpose of Issue	Prepared	Checked	Approved	AC Code
					Class: 1	Phase: P



Airpack B.V.

4301 RN Zierikzee
The Netherlands

PHONE: (31) (0) 111 - 415455

FAX: (31) (0) 111 - 413338

E-MAIL : AIRPACK@AIRPACK.NL

WEBPAGE : WWW.AIRPACK.NL

Client	:	Bushehr Petrochemical Company (BUPC)		
Equipment location	:	Iran, Onshore		
Client reference	:	Bushehr MEG Plant Project		
Client dwg. no.	:	BU-20-VD-303-IN-DIG-0093		
Airpack reference	:	17811-30B		
Airpack dwg. no.	:	17811-30B		
Generation date	:	30-Jun-21		
E & I manager	:	RBE	Revision no.	: 02
Last modifications	:	24-Aug-22		
Last modifications by	:	RTR		




CLIENT DWG NO.	BU-20-VD-303-IN-DIG-0093
EQUIPMENT NO.	20-C-7080
EQUIPMENT LOCATION	Iran, Onshore
THIS DRAWING IS OWNED BY AIRPACK, AND SHALL NOT BE PRINTED OR COPIED IN ANY OTHER WAY THAN WITH AIRPACKS PERMISSION!	


SUBJECT Title page / cover sheet	
ADAPTED TO P&ID REVISION	03
CLIENT	Bushehr Petrochemical Company (BUPC)
CLIENT REF.	Bushehr MEG Plant Project
AIRPACK REF.	17811-30B

DRAWN BY	RTR	=
CHECKED BY	RBE	+
LAST MODIFICATION DATE		CURRENT PAGE
AIRPACK DWG NO.	17811-30B	
REVISION	02	
TOTAL PAGE AMOUNT	1	


Internal targets

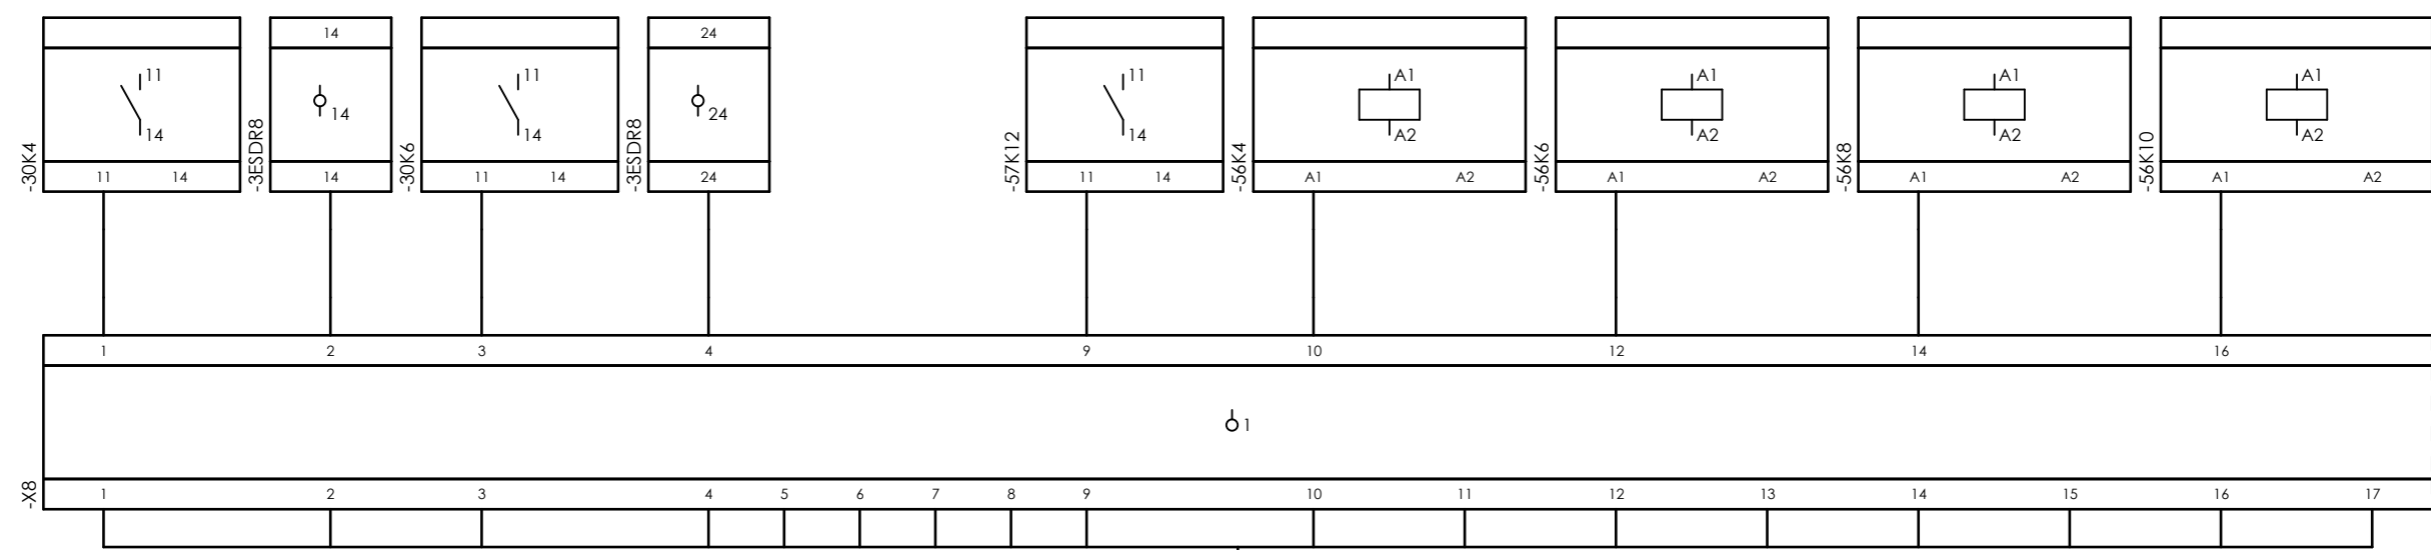

=20-C-7080+UCP-C7080-01-DB_COMB

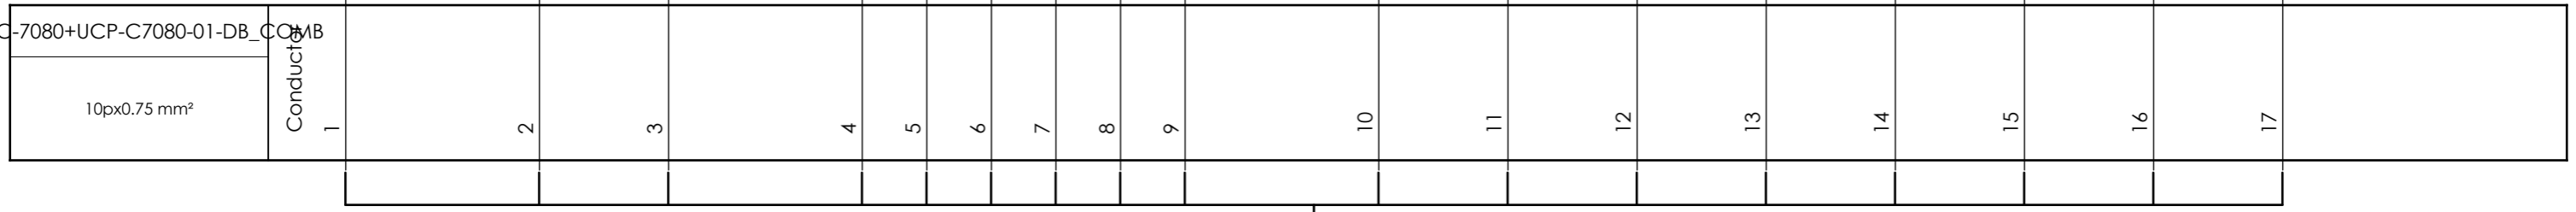

External targets

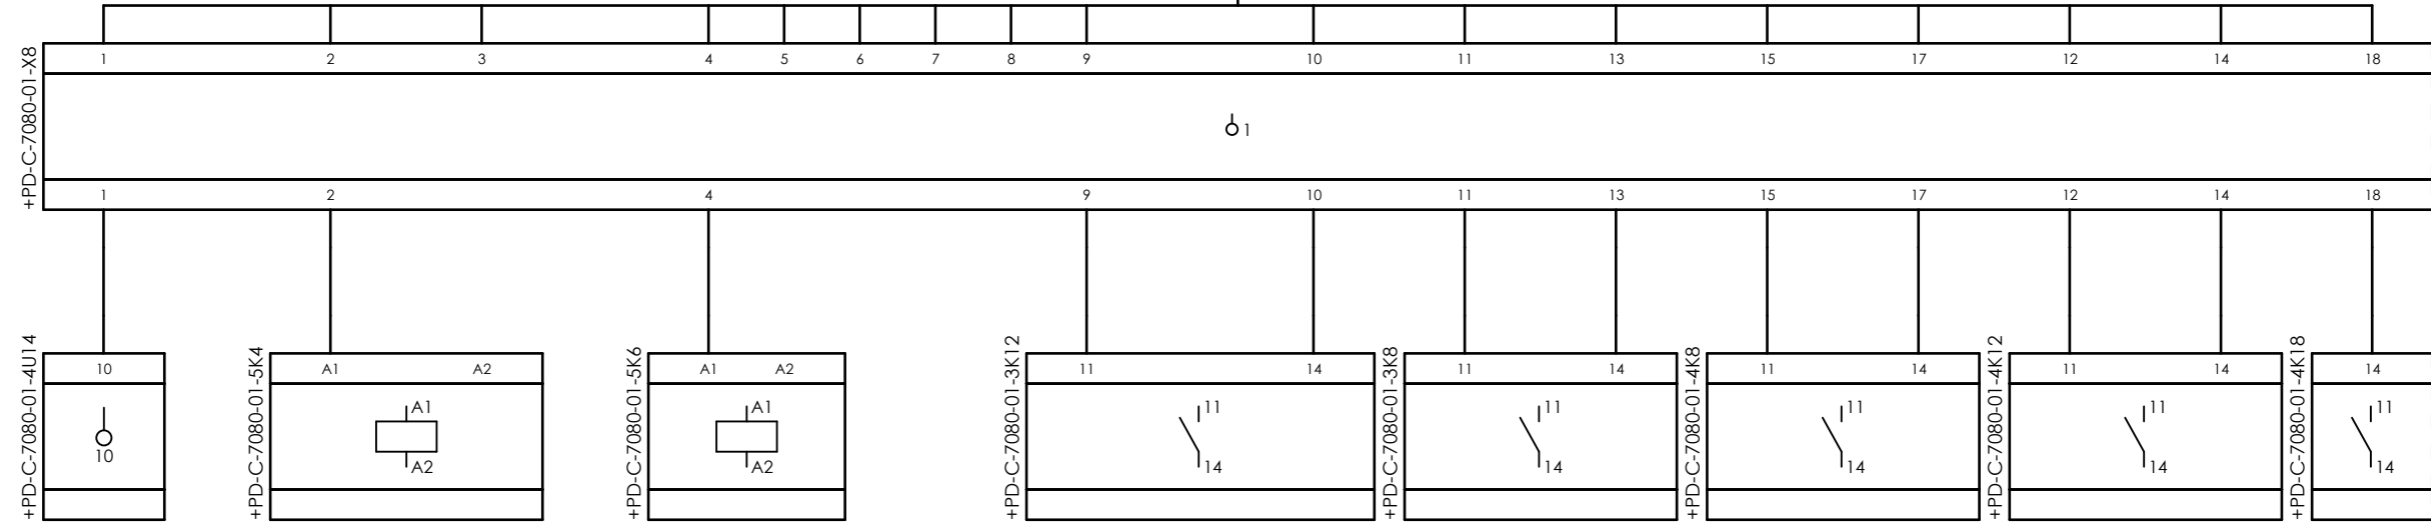


CLIENT DWG NO.	BU-20-VD-303-IN-DIG-0093
EQUIPMENT NO.	20-C-7080
EQUIPMENT LOCATION	Iran, Onshore
THIS DRAWING IS OWNED BY AIRPACK, AND SHALL NOT BE PRINTED OR COPIED IN ANY OTHER WAY THAN WITH AIRPACKS PERMISSION!	

SUBJECT		Cable-connection diagram =20-C-7080+UCP-C7080-01-DB_COMB	
ADAPTED TO P&ID REVISION	03		
CLIENT	Bushehr Petrochemical Company (BUPC)		
CLIENT REF.	Bushehr MEG Plant Project		
AIRPACK REF.	17811-30B		

DRAWN BY	RTR	=
CHECKED BY	RBE	+
LAST MODIFICATION DATE		CURRENT PAGE
AIRPACK DWG NO.	17811-30B	
REVISION	02	
TOTAL PAGE AMOUNT	2	


Internal targets

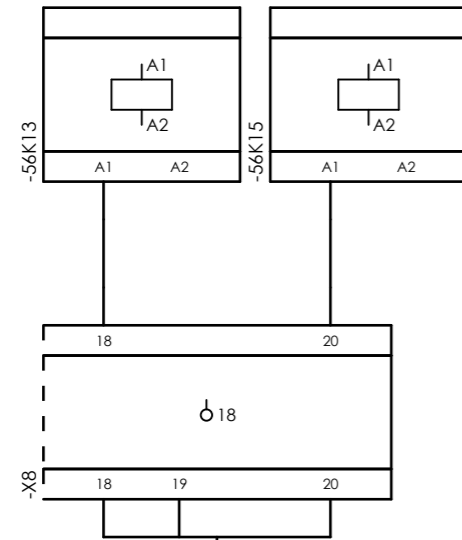

=20-C-7080+UCP-C7080-01-DB_COMB




External targets

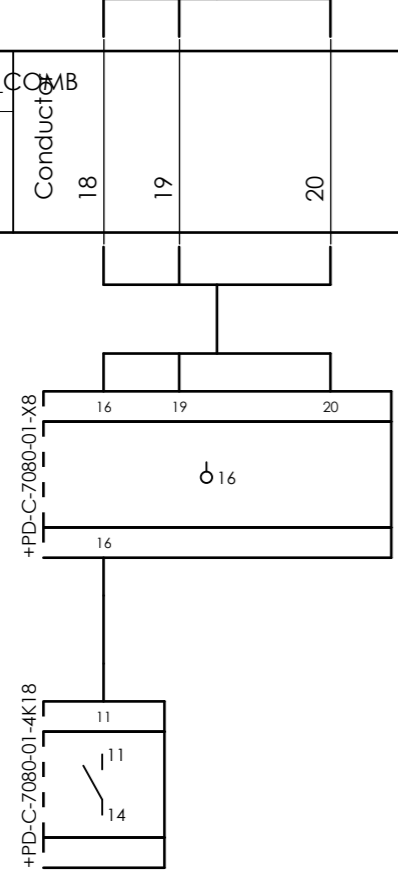

CLIENT DWG NO.	BU-20-VD-303-IN-DIG-0093
EQUIPMENT NO.	20-C-7080
EQUIPMENT LOCATION	Iran, Onshore
THIS DRAWING IS OWNED BY AIRPACK, AND SHALL NOT BE PRINTED OR COPIED IN ANY OTHER WAY THAN WITH AIRPACKS PERMISSION!	


SUBJECT		DRAWN BY		RTR		=	
Cable-connection diagram =20-C-7080+UCP-C7080-01-DB_COMB		CHECKED BY		RBE		+	
ADAPTED TO P&ID REVISION	03	LAST MODIFICATION DATE				CURRENT PAGE	
CLIENT	Bushehr Petrochemical Company (BUPC)	AIRPACK DWG NO.		17811-30B			
CLIENT REF.	Bushehr MEG Plant Project	REVISION		02			
AIRPACK REF.	17811-30B	TOTAL PAGE AMOUNT		3			

Internal targets





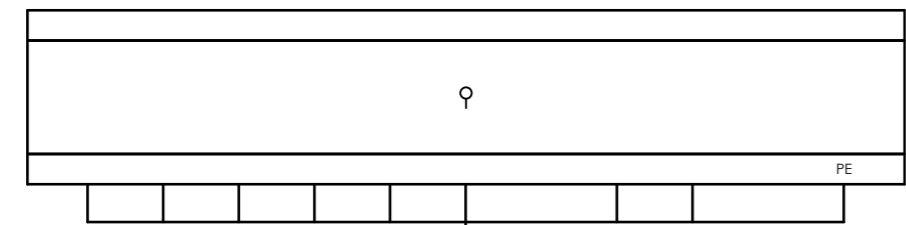


=20-C-7080+UCP-C7080-01-ESD

5Px0,75 mm² mm²

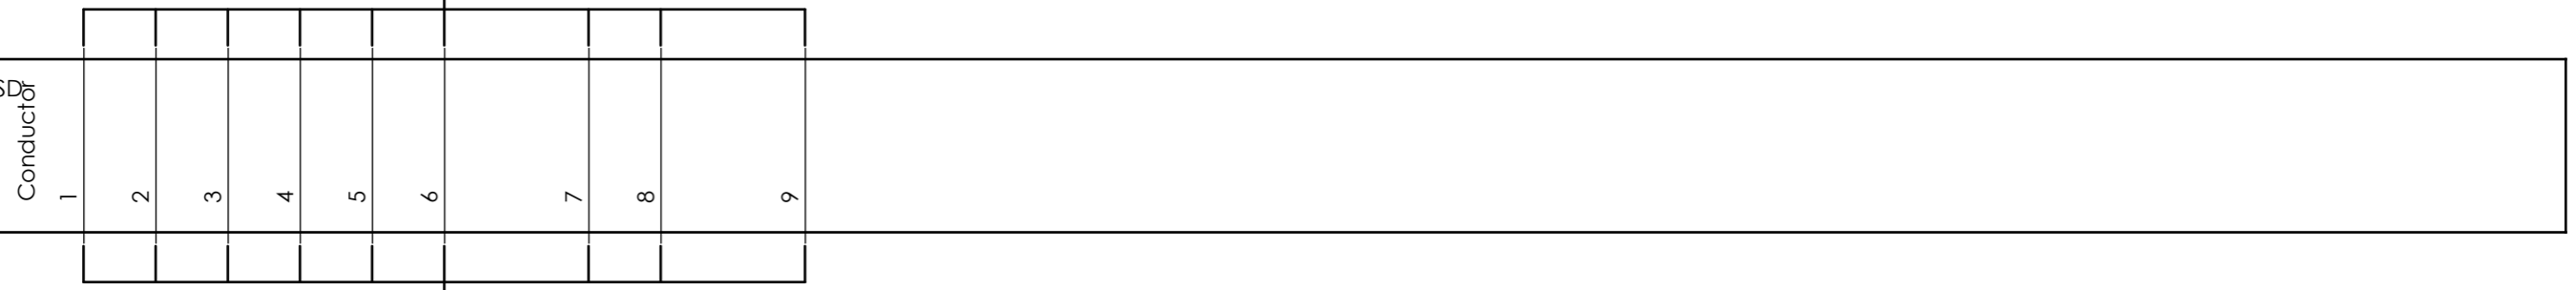

External targets

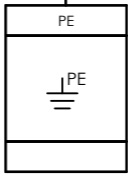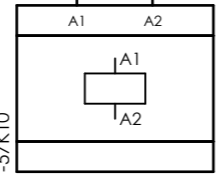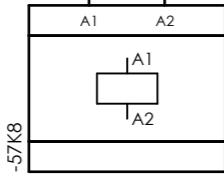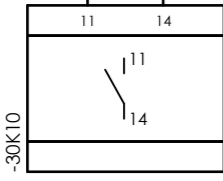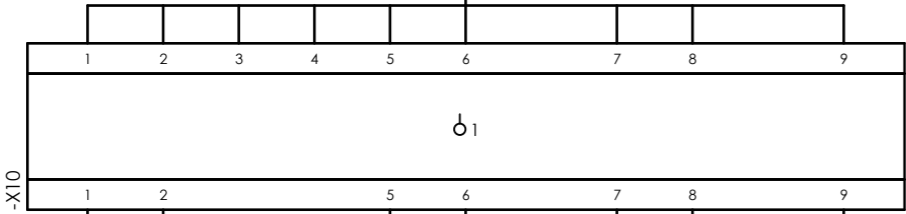


CLIENT DWG NO. BU-20-VD-303-IN-DIG-0093
 EQUIPMENT NO. 20-C-7080
 EQUIPMENT LOCATION Iran, Onshore
 THIS DRAWING IS OWNED BY AIRPACK, AND SHALL NOT BE PRINTED OR COPIED IN ANY OTHER WAY THAN WITH AIRPACKS PERMISSION!

SUBJECT Cable-connection diagram =20-C-7080+UCP-C7080-01-ESD
 ADAPTED TO P&ID REVISION 03
 CLIENT Bushehr Petrochemical Company (BUPC)
 CLIENT REF. Bushehr MEG Plant Project
 AIRPACK REF. 17811-30B

DRAWN BY RTR
 CHECKED BY RBE
 LAST MODIFICATION DATE
 AIRPACK DWG NO. 17811-30B
 REVISION 02
 TOTAL PAGE AMOUNT 4

=
 +
 CURRENT PAGE


Internal targets

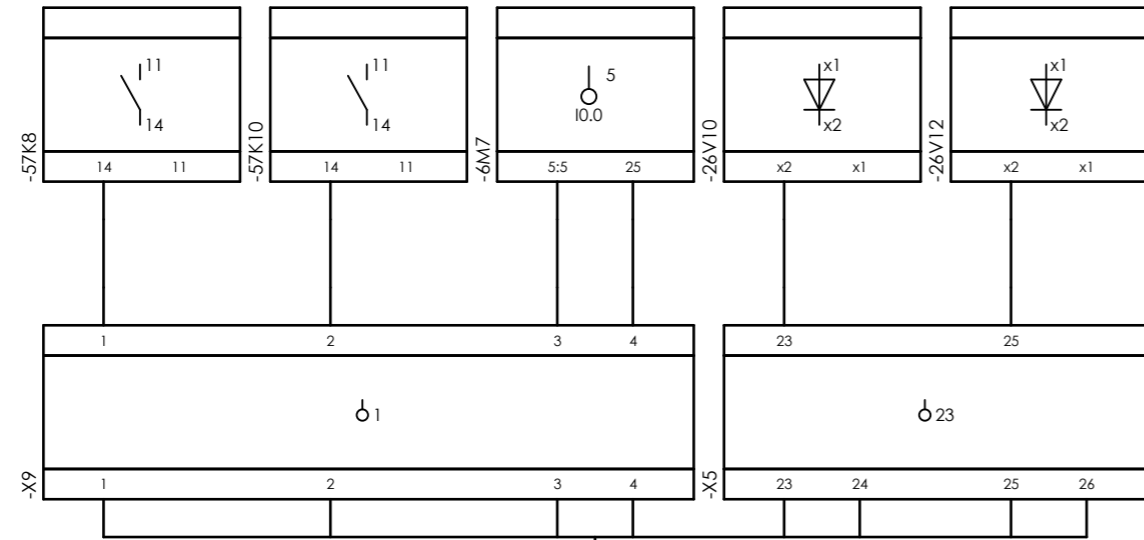

=20-C-7080+UCP-C7080-01-ESD_LCP_B




External targets


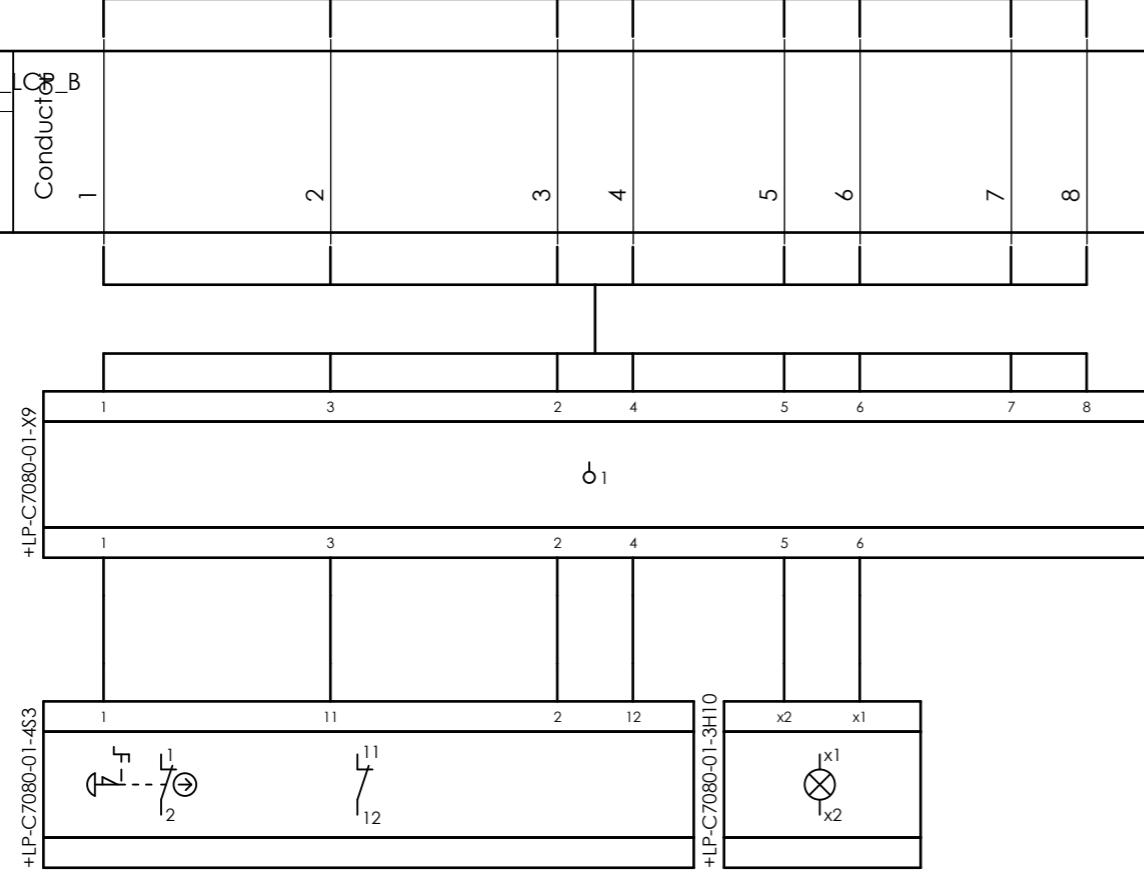


CLIENT DWG NO.	BU-20-VD-303-IN-DIG-0093	SUBJECT		DRAWN BY	RTR	=
EQUIPMENT NO.	20-C-7080	Cable-connection diagram =20-C-7080+UCP-C7080-01-ESD_LCP_B		CHECKED BY	RBE	+
EQUIPMENT LOCATION	Iran, Onshore	ADAPTED TO P&ID REVISION	03	LAST MODIFICATION DATE		CURRENT PAGE
THIS DRAWING IS OWNED BY AIRPACK, AND SHALL NOT BE PRINTED OR COPIED IN ANY OTHER WAY THAN WITH AIRPACKS PERMISSION!		CLIENT	Bushehr Petrochemical Company (BUPC)	AIRPACK DWG NO.	17811-30B	
		CLIENT REF.	Bushehr MEG Plant Project	REVISION	02	
		AIRPACK REF.	17811-30B	TOTAL PAGE AMOUNT	5	


Internal targets

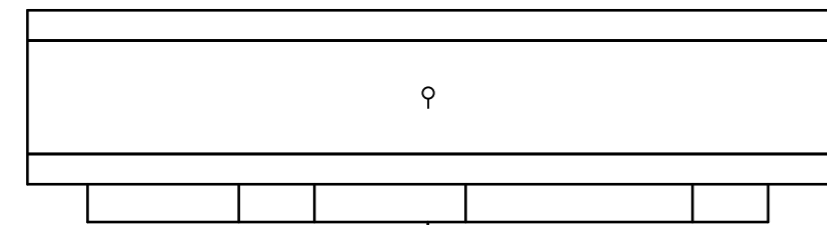

=20-C-7080+UCP-C7080-01-FCS
10Px0,75 mm²
Conductors

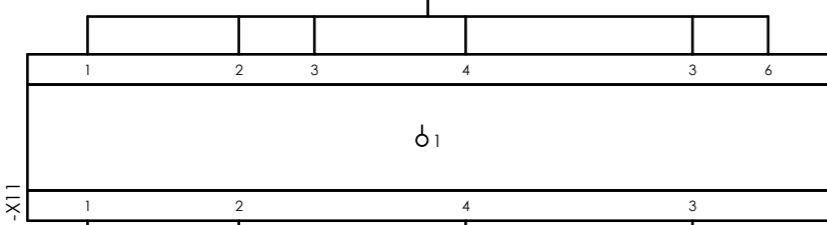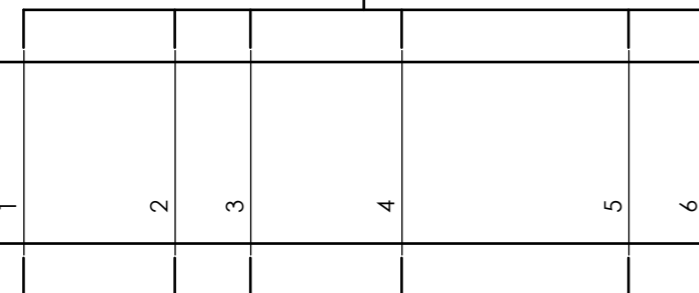


External targets

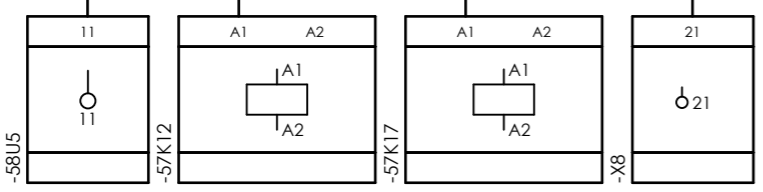


CLIENT DWG NO.	BU-20-VD-303-IN-DIG-0093
EQUIPMENT NO.	20-C-7080
EQUIPMENT LOCATION	Iran, Onshore
THIS DRAWING IS OWNED BY AIRPACK, AND SHALL NOT BE PRINTED OR COPIED IN ANY OTHER WAY THAN WITH AIRPACKS PERMISSION!	

SUBJECT		DRAWN BY	RTR	=
Cable-connection diagram =20-C-7080+UCP-C7080-01-FCS		CHECKED BY	RBE	+
ADAPTED TO P&ID REVISION	03	LAST MODIFICATION DATE		CURRENT PAGE
CLIENT	Bushehr Petrochemical Company (BUPC)	AIRPACK DWG NO.	17811-30B	
CLIENT REF.	Bushehr MEG Plant Project	REVISION	02	
AIRPACK REF.	17811-30B	TOTAL PAGE AMOUNT	6	

Internal targets

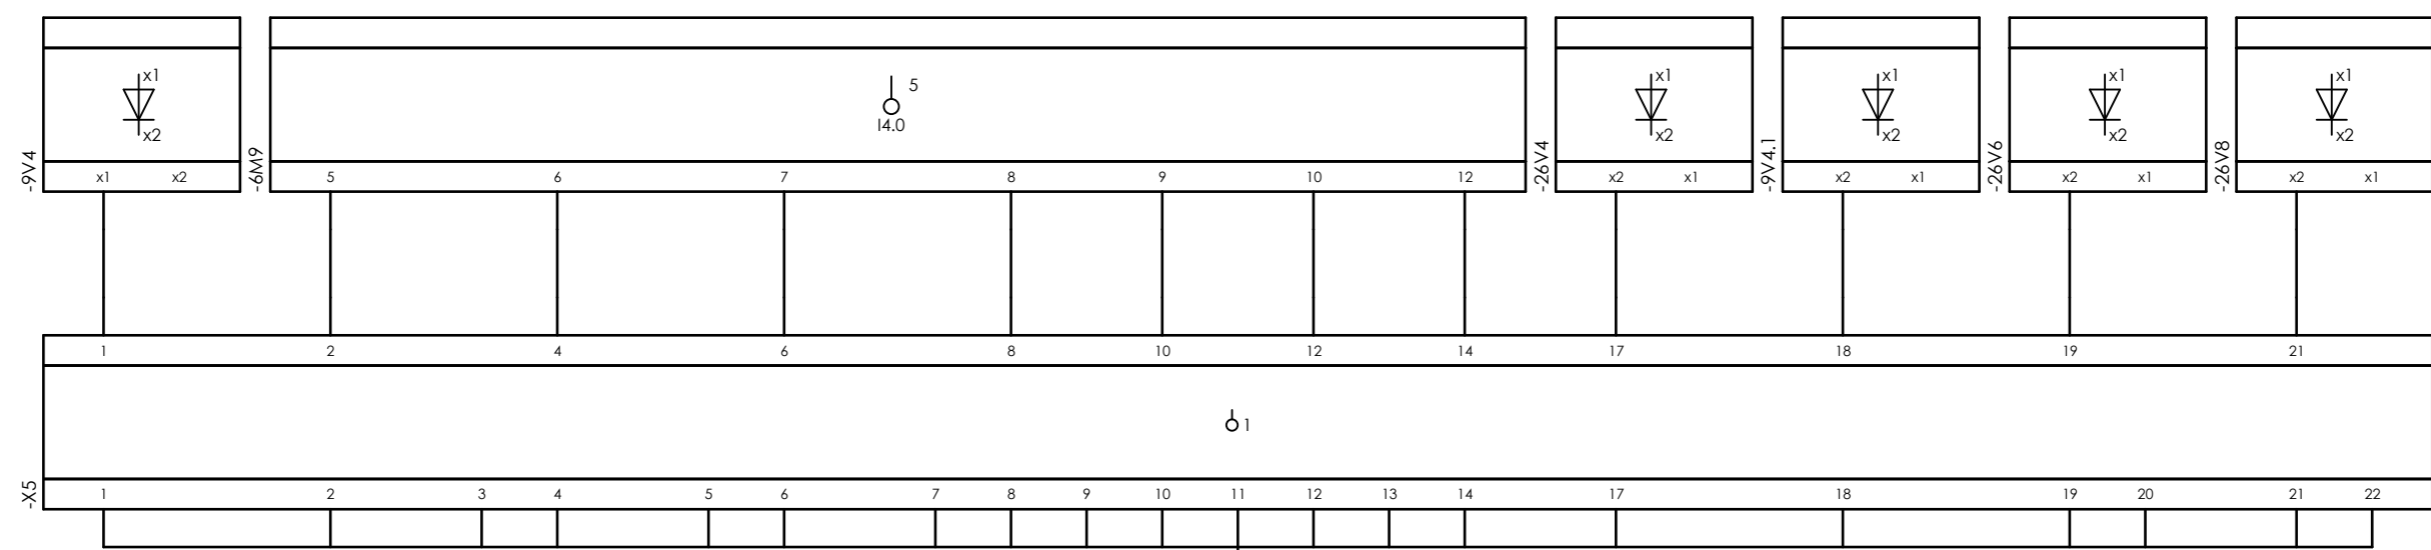

External targets

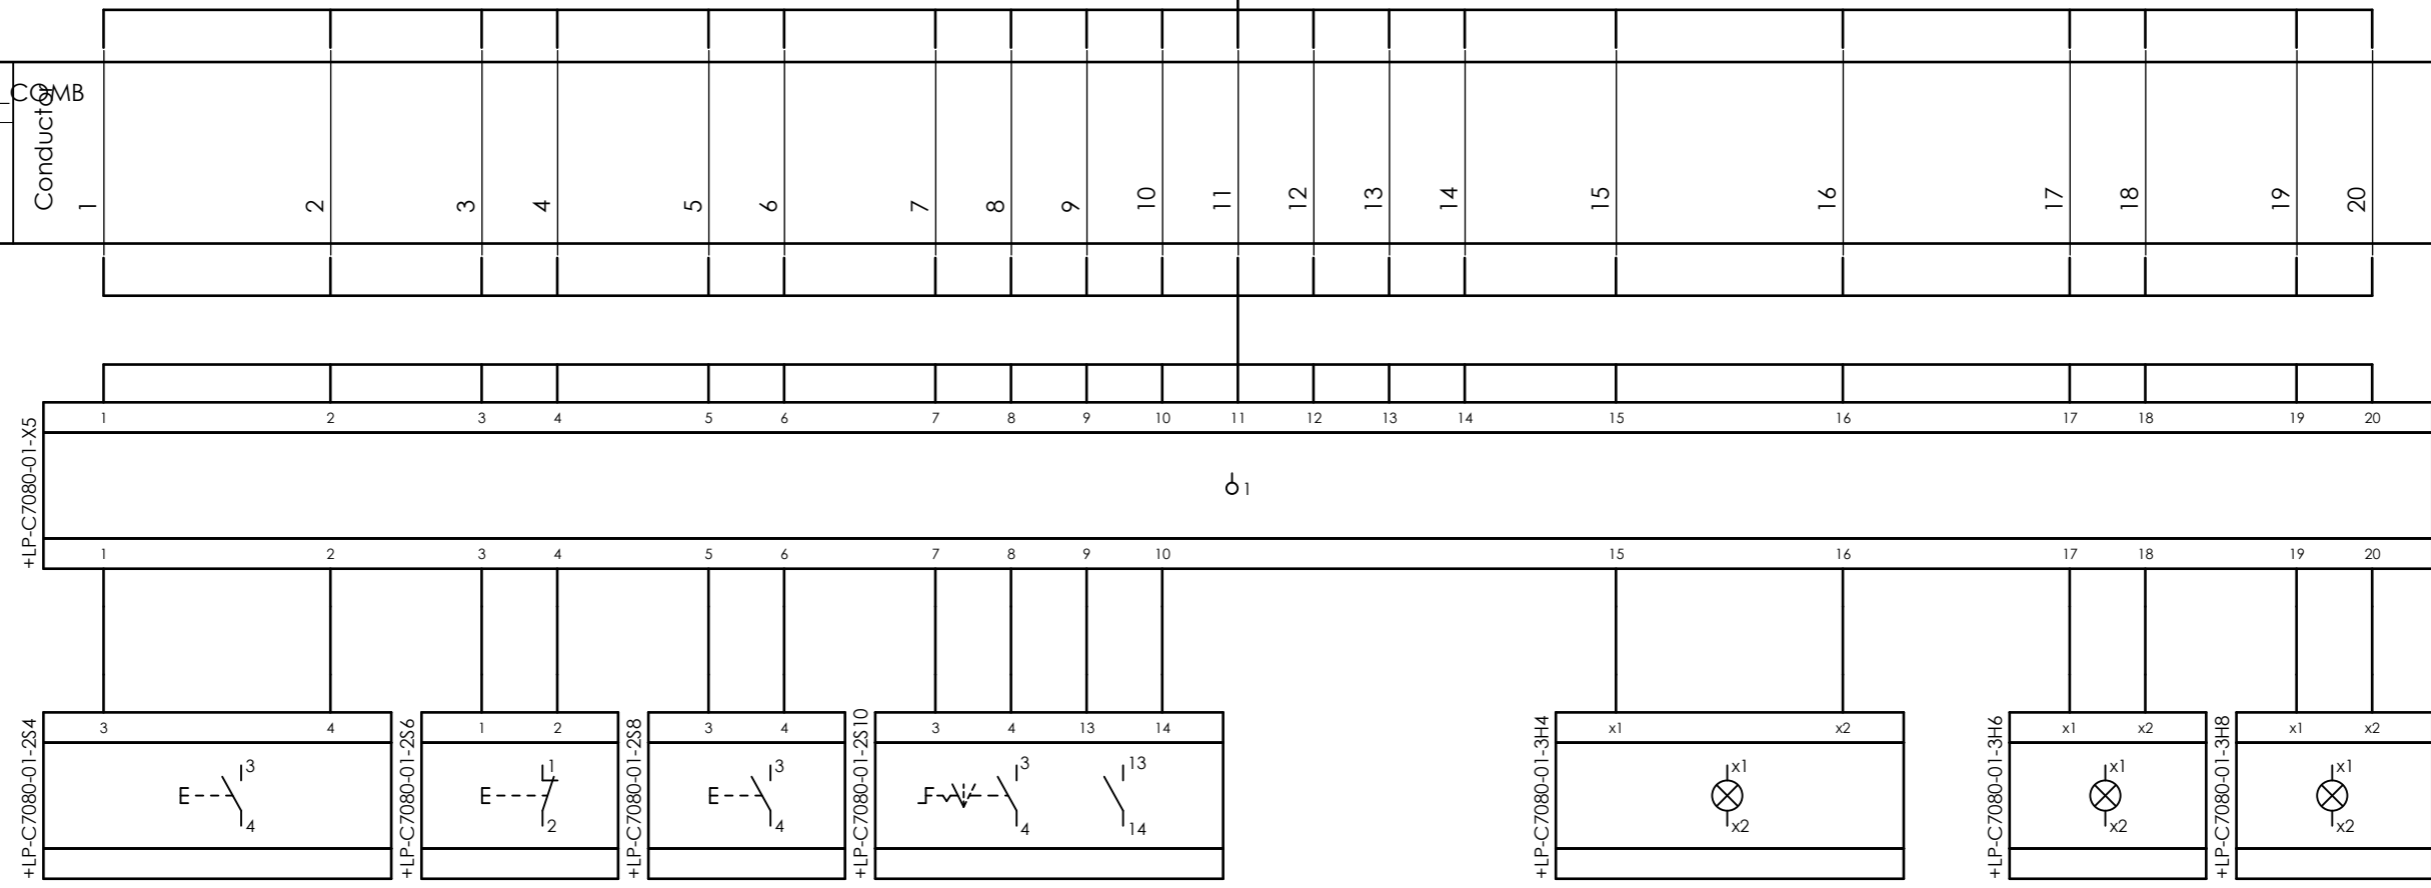

=20-C-7080+UCP-C7080-01-LCP_COMB
 Conductors
 10x0,75 mm²




CLIENT DWG NO. BU-20-VD-303-IN-DIG-0093
 EQUIPMENT NO. 20-C-7080
 EQUIPMENT LOCATION Iran, Onshore
 THIS DRAWING IS OWNED BY AIRPACK, AND SHALL NOT BE PRINTED OR COPIED IN ANY OTHER WAY THAN WITH AIRPACKS PERMISSION!

SUBJECT Cable-connection diagram =20-C-7080+UCP-C7080-01-LCP_COMB
 ADAPTED TO P&ID REVISION 03
 CLIENT Bushehr Petrochemical Company (BUPC)
 CLIENT REF. Bushehr MEG Plant Project
 AIRPACK REF. 17811-30B


DRAWN BY RTR
 CHECKED BY RBE
 LAST MODIFICATION DATE
 AIRPACK DWG NO. 17811-30B
 REVISION 02
 TOTAL PAGE AMOUNT 7

=
 +
 CURRENT PAGE
 7


Internal targets

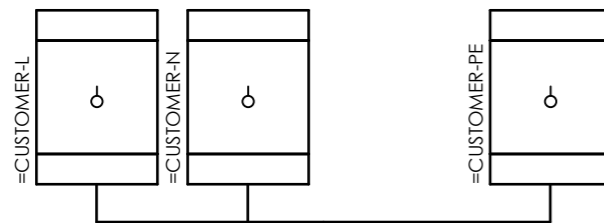

=20-C-7080+UCP-C7080-01-PS_00
3x2.5 sqmm

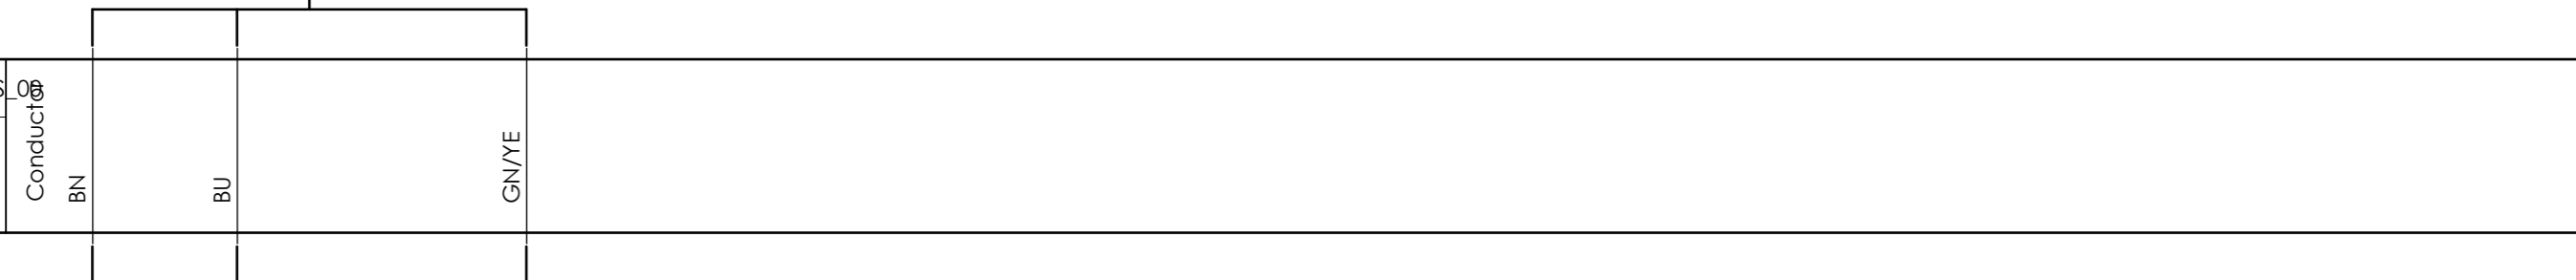

External targets

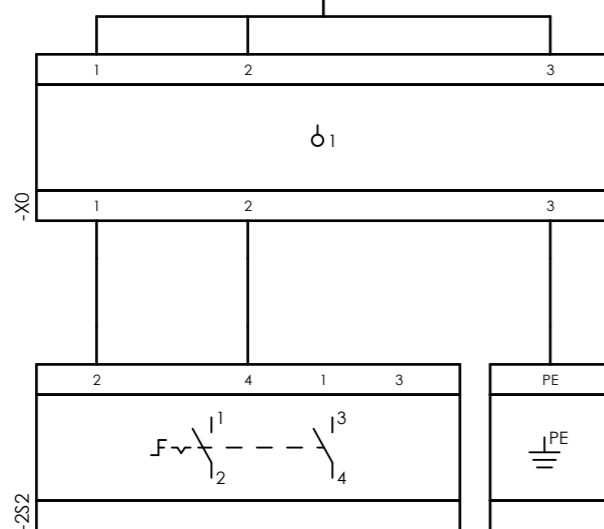


CLIENT DWG NO.	BU-20-VD-303-IN-DIG-0093
EQUIPMENT NO.	20-C-7080
EQUIPMENT LOCATION	Iran, Onshore
THIS DRAWING IS OWNED BY AIRPACK, AND SHALL NOT BE PRINTED OR COPIED IN ANY OTHER WAY THAN WITH AIRPACKS PERMISSION!	


SUBJECT		Cable-connection diagram =20-C-7080+UCP-C7080-01-PS_00	
ADAPTED TO P&ID REVISION	03	CLIENT	Bushehr Petrochemical Company (BUPC)
CLIENT REF.	Bushehr MEG Plant Project	AIRPACK REF.	17811-30B

DRAWN BY	RTR	=
CHECKED BY	RBE	+
LAST MODIFICATION DATE		CURRENT PAGE
AIRPACK DWG NO.	17811-30B	
REVISION	02	
TOTAL PAGE AMOUNT	8	


Internal targets

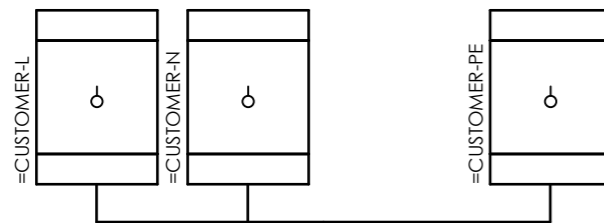

=20-C-7080+UCP-C7080-01-PS_01
3x2.5 sqmm

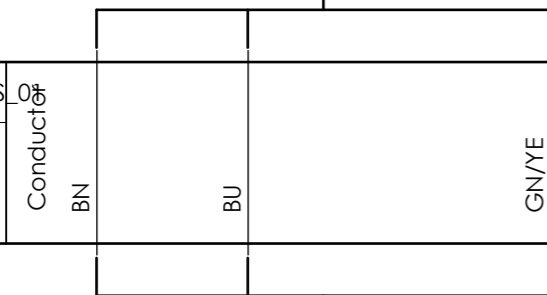


External targets

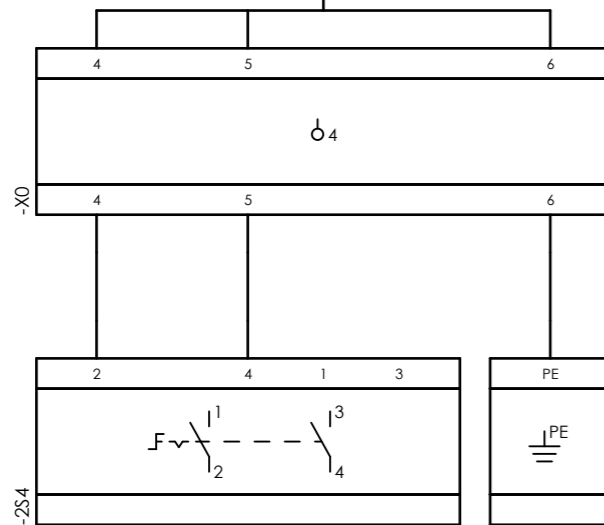


CLIENT DWG NO.	BU-20-VD-303-IN-DIG-0093
EQUIPMENT NO.	20-C-7080
EQUIPMENT LOCATION	Iran, Onshore
THIS DRAWING IS OWNED BY AIRPACK, AND SHALL NOT BE PRINTED OR COPIED IN ANY OTHER WAY THAN WITH AIRPACKS PERMISSION!	

SUBJECT		DRAWN BY	RTR	=
Cable-connection diagram =20-C-7080+UCP-C7080-01-PS_01		CHECKED BY	RBE	+
ADAPTED TO P&ID REVISION	03	LAST MODIFICATION DATE		CURRENT PAGE
CLIENT	Bushehr Petrochemical Company (BUPC)	AIRPACK DWG NO.	17811-30B	
CLIENT REF.	Bushehr MEG Plant Project	REVISION	02	
AIRPACK REF.	17811-30B	TOTAL PAGE AMOUNT	9	


Internal targets

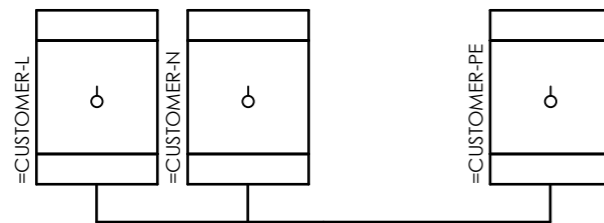

=20-C-7080+UCP-C7080-01-PS_02
3x2.5 sqmm

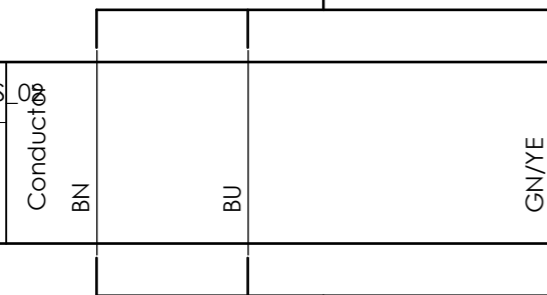


External targets

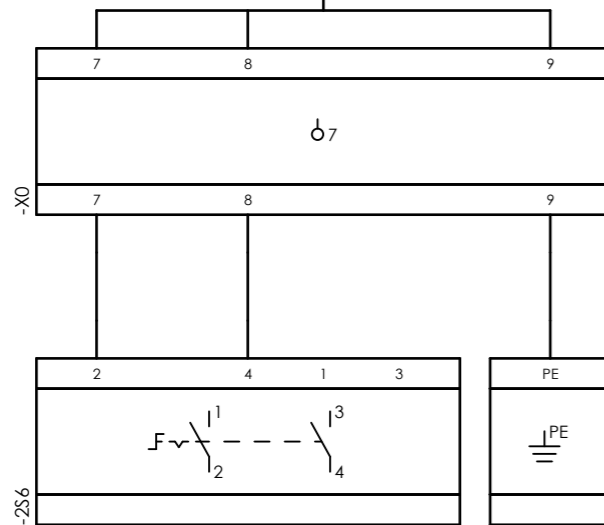

CLIENT DWG NO.	BU-20-VD-303-IN-DIG-0093
EQUIPMENT NO.	20-C-7080
EQUIPMENT LOCATION	Iran, Onshore
THIS DRAWING IS OWNED BY AIRPACK, AND SHALL NOT BE PRINTED OR COPIED IN ANY OTHER WAY THAN WITH AIRPACKS PERMISSION!	

SUBJECT		DRAWN BY	RTR	=
Cable-connection diagram =20-C-7080+UCP-C7080-01-PS_02		CHECKED BY	RBE	+
ADAPTED TO P&ID REVISION	03	LAST MODIFICATION DATE		CURRENT PAGE
CLIENT	Bushehr Petrochemical Company (BUPC)	AIRPACK DWG NO.	17811-30B	
CLIENT REF.	Bushehr MEG Plant Project	REVISION	02	
AIRPACK REF.	17811-30B	TOTAL PAGE AMOUNT	10	

Internal targets

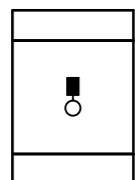


=20-C-7080+UCP-C7080-01-SERA00

CAT6 4Px23 AWG



Conductors

External targets

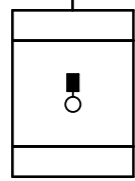


CLIENT DWG NO.	BU-20-VD-303-IN-DIG-0093	SUBJECT		DRAWN BY	RTR	=
EQUIPMENT NO.	20-C-7080	Cable-connection diagram =20-C-7080+UCP-C7080-01-SERA00		CHECKED BY	RBE	+
EQUIPMENT LOCATION	Iran, Onshore	ADAPTED TO P&ID REVISION	03	LAST MODIFICATION DATE		CURRENT PAGE
THIS DRAWING IS OWNED BY AIRPACK, AND SHALL NOT BE PRINTED OR COPIED IN ANY OTHER WAY THAN WITH AIRPACKS PERMISSION!		CLIENT	Bushehr Petrochemical Company (BUPC)	AIRPACK DWG NO.	17811-30B	11
		CLIENT REF.	Bushehr MEG Plant Project	REVISION	02	
		AIRPACK REF.	17811-30B	TOTAL PAGE AMOUNT	11	

Internal targets

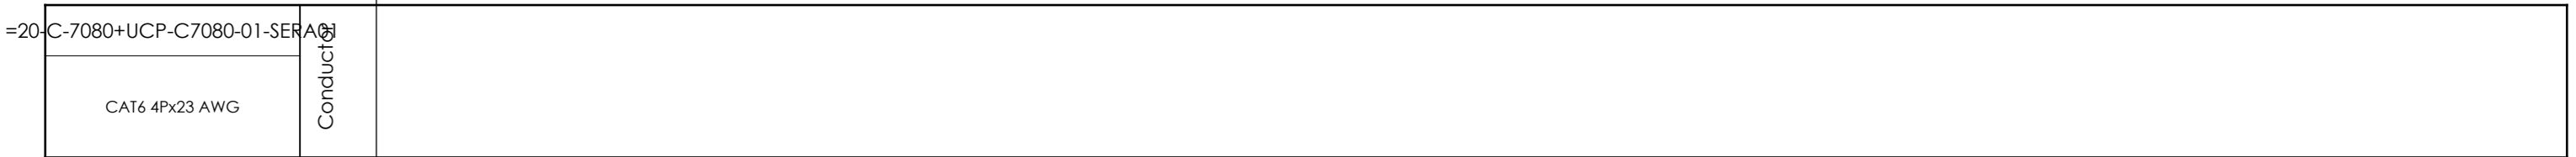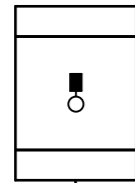

External targets

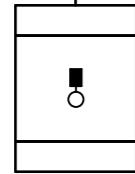


CLIENT DWG NO.	BU-20-VD-303-IN-DIG-0093
EQUIPMENT NO.	20-C-7080
EQUIPMENT LOCATION	Iran, Onshore
THIS DRAWING IS OWNED BY AIRPACK, AND SHALL NOT BE PRINTED OR COPIED IN ANY OTHER WAY THAN WITH AIRPACKS PERMISSION!	


SUBJECT Cable-connection diagram =20-C-7080+UCP-C7080-01-SERA01	
ADAPTED TO P&ID REVISION	03
CLIENT	Bushehr Petrochemical Company (BUPC)
CLIENT REF.	Bushehr MEG Plant Project
AIRPACK REF.	17811-30B

DRAWN BY	RTR	=
CHECKED BY	RBE	+
LAST MODIFICATION DATE		CURRENT PAGE
AIRPACK DWG NO.	17811-30B	
REVISION	02	
TOTAL PAGE AMOUNT	12	

Internal targets

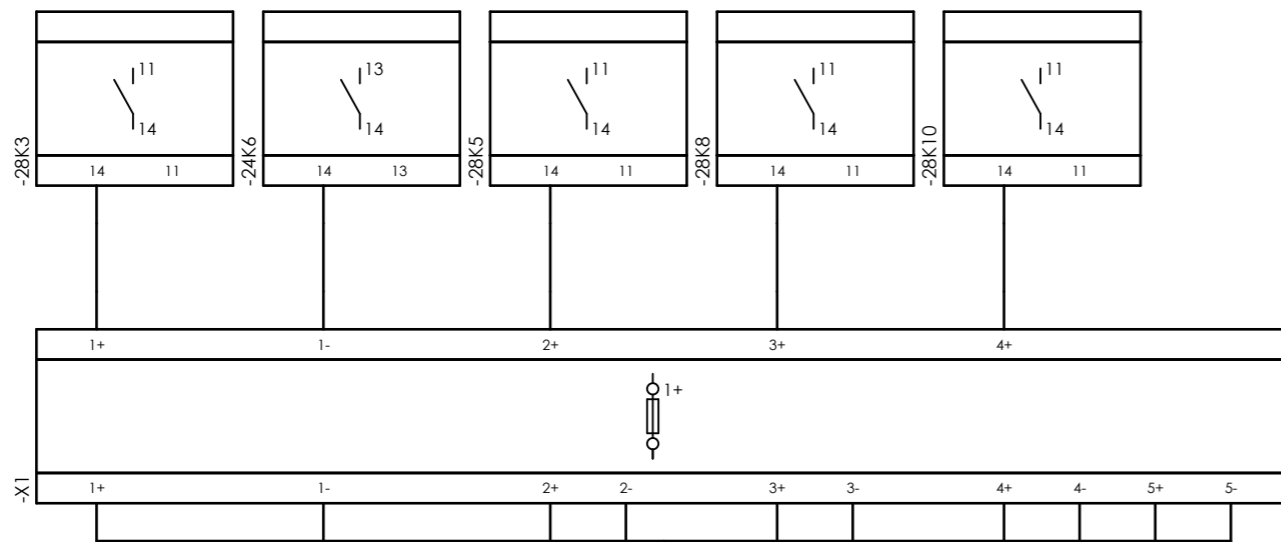

External targets

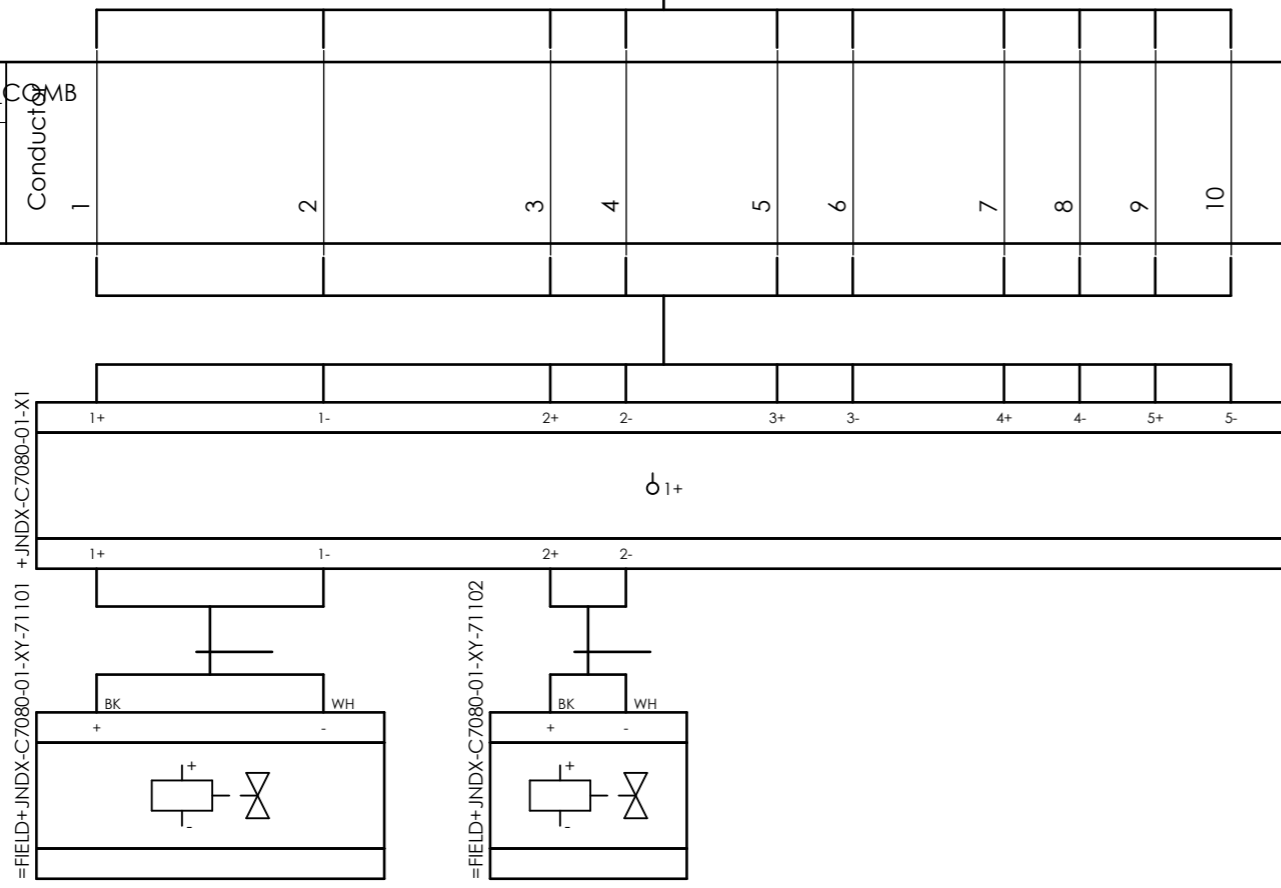


CLIENT DWG NO.	BU-20-VD-303-IN-DIG-0093
EQUIPMENT NO.	20-C-7080
EQUIPMENT LOCATION	Iran, Onshore
THIS DRAWING IS OWNED BY AIRPACK, AND SHALL NOT BE PRINTED OR COPIED IN ANY OTHER WAY THAN WITH AIRPACKS PERMISSION!	


SUBJECT		Cable-connection diagram =20-C-7080+UCP-C7080-01-SOL_COMB	
ADAPTED TO P&ID REVISION	03	CLIENT	Bushehr Petrochemical Company (BUPC)
CLIENT REF.	Bushehr MEG Plant Project	AIRPACK REF.	17811-30B

DRAWN BY	RTR	=
CHECKED BY	RBE	+
LAST MODIFICATION DATE		CURRENT PAGE
AIRPACK DWG NO.	17811-30B	
REVISION	02	
TOTAL PAGE AMOUNT	13	


Internal targets

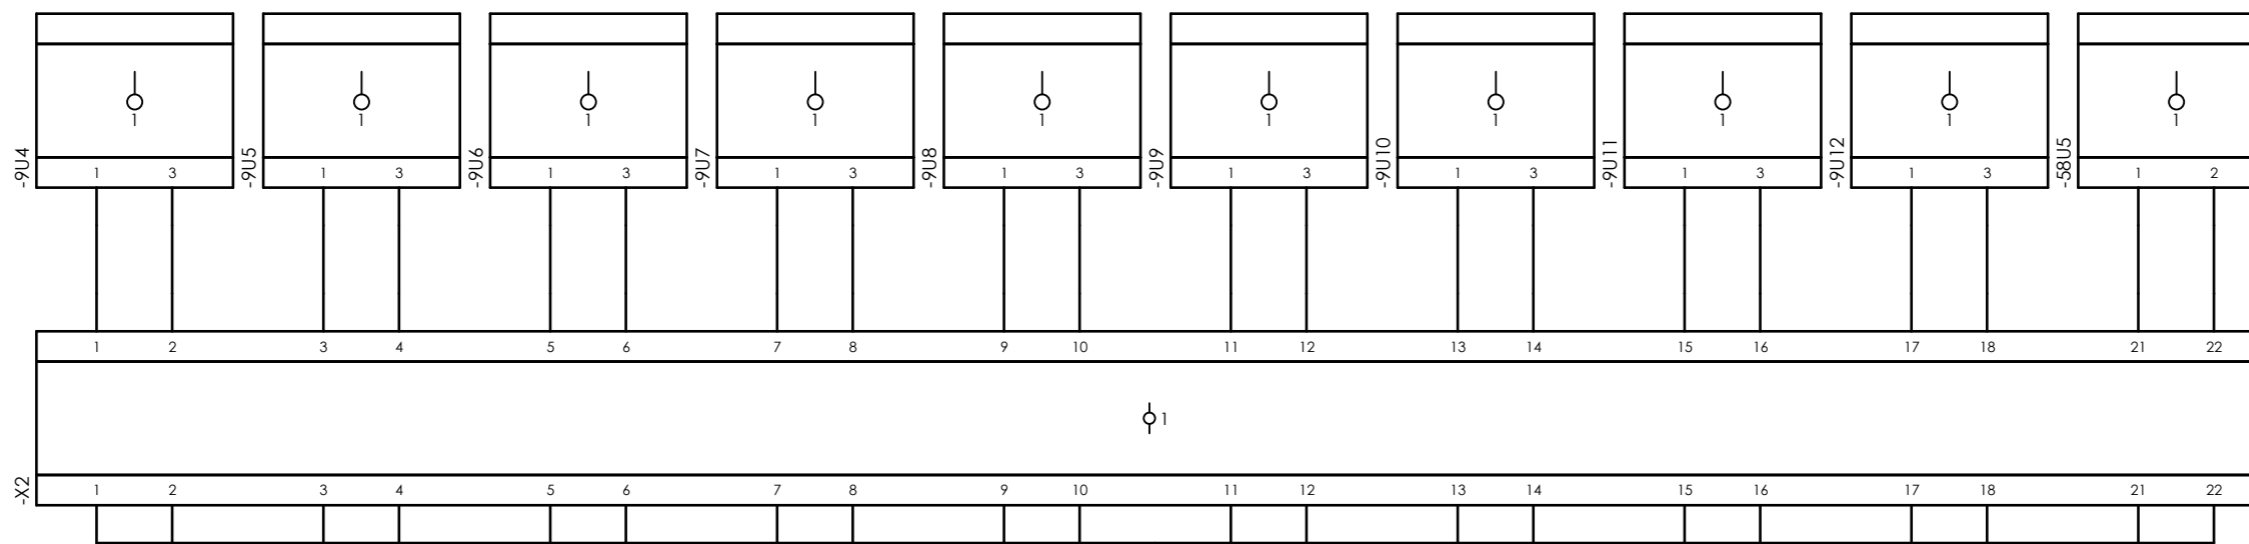

=20-C-7080+UCP-C7080-01-TR_COMB

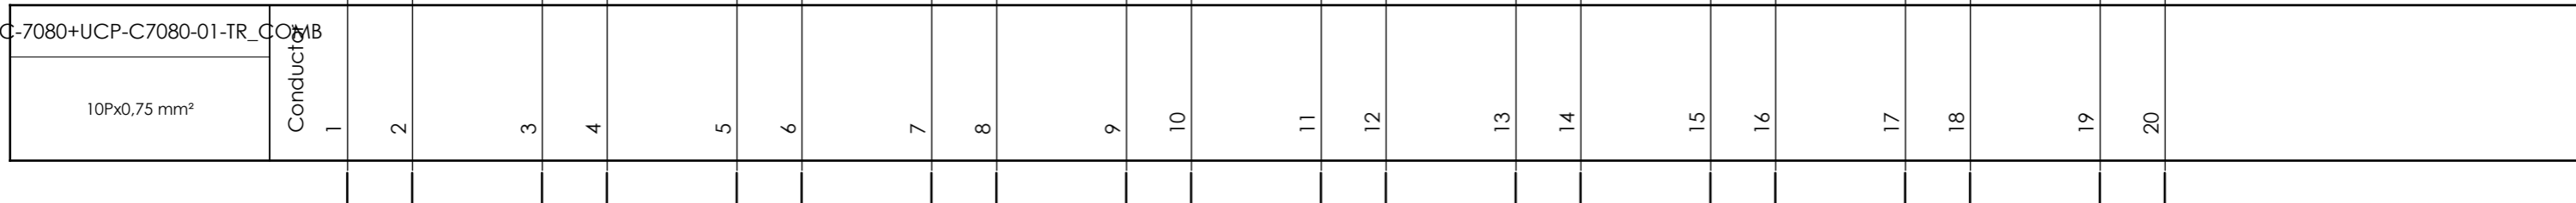

External targets




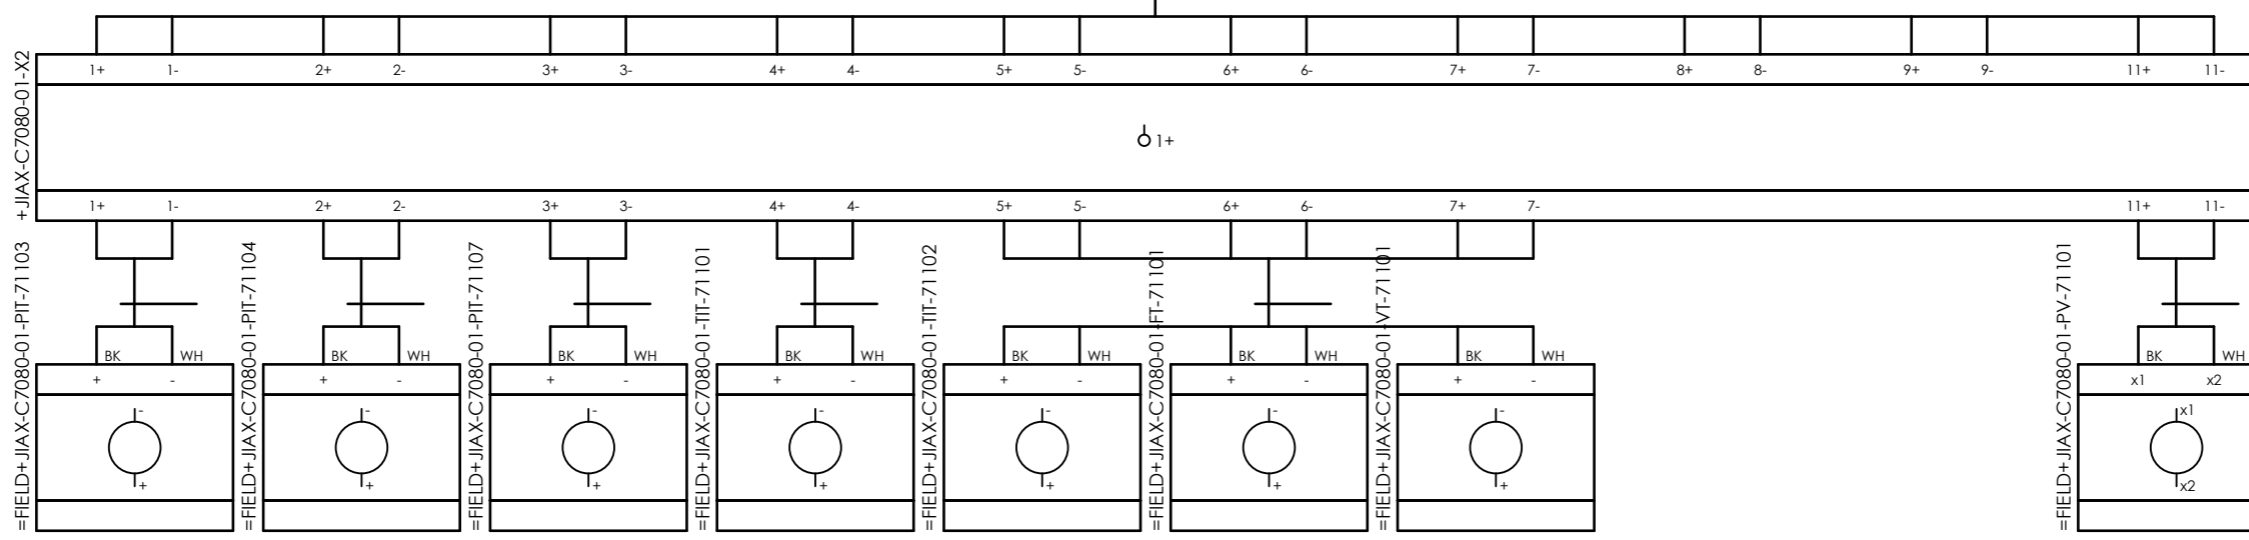


CLIENT DWG NO.	BU-20-VD-303-IN-DIG-0093
EQUIPMENT NO.	20-C-7080
EQUIPMENT LOCATION	Iran, Onshore
THIS DRAWING IS OWNED BY AIRPACK, AND SHALL NOT BE PRINTED OR COPIED IN ANY OTHER WAY THAN WITH AIRPACKS PERMISSION!	

SUBJECT		Cable-connection diagram =20-C-7080+UCP-C7080-01-TR_COMB	
ADAPTED TO P&ID REVISION	03		
CLIENT	Bushehr Petrochemical Company (BUPC)		
CLIENT REF.	Bushehr MEG Plant Project		
AIRPACK REF.	17811-30B		

DRAWN BY	RTR	=
CHECKED BY	RBE	+
LAST MODIFICATION DATE		CURRENT PAGE
AIRPACK DWG NO.	17811-30B	
REVISION	02	
TOTAL PAGE AMOUNT	14	

 Internal targets

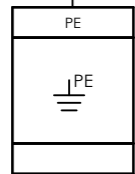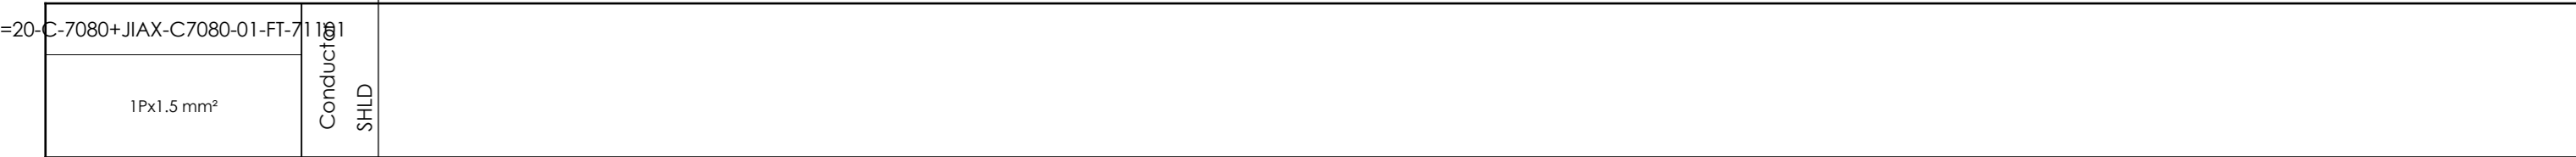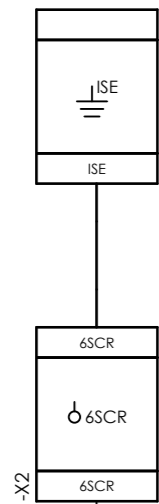

External targets





CLIENT DWG NO.	BU-20-VD-303-IN-DIG-0093
EQUIPMENT NO.	20-C-7080
EQUIPMENT LOCATION	Iran, Onshore

THIS DRAWING IS OWNED BY AIRPACK, AND SHALL NOT BE PRINTED OR COPIED IN ANY OTHER WAY THAN WITH AIRPACKS PERMISSION!



SUBJECT		Cable-connection diagram =20-C-7080+JIAX-C7080-01-FT-71101	
ADAPTED TO P&ID REVISION	03	CLIENT	Bushehr Petrochemical Company (BUPC)
CLIENT REF.	Bushehr MEG Plant Project	AIRPACK REF.	17811-30B

DRAWN BY	RTR	=
CHECKED BY	RBE	+
LAST MODIFICATION DATE		CURRENT PAGE
AIRPACK DWG NO.	17811-30B	
REVISION	02	
TOTAL PAGE AMOUNT	15	

 Internal targets

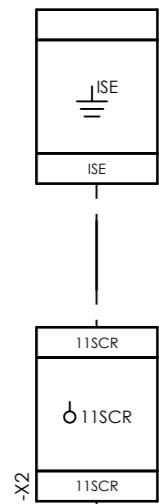

=20-C-7080+JIAX-C7080-01-PV-71101

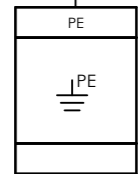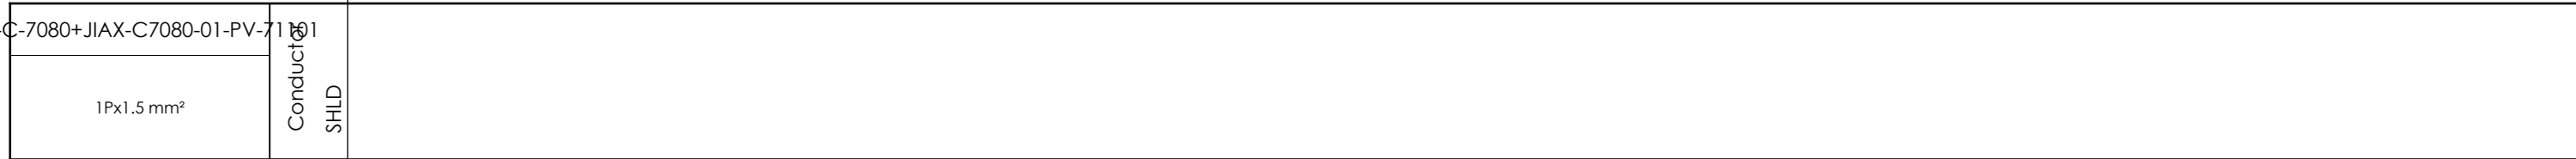

External targets





CLIENT DWG NO.	BU-20-VD-303-IN-DIG-0093
EQUIPMENT NO.	20-C-7080
EQUIPMENT LOCATION	Iran, Onshore
THIS DRAWING IS OWNED BY AIRPACK, AND SHALL NOT BE PRINTED OR COPIED IN ANY OTHER WAY THAN WITH AIRPACKS PERMISSION!	



SUBJECT		Cable-connection diagram =20-C-7080+JIAX-C7080-01-PV-71101	
ADAPTED TO P&ID REVISION	03	CLIENT	Bushehr Petrochemical Company (BUPC)
CLIENT REF.	Bushehr MEG Plant Project	AIRPACK REF.	17811-30B

DRAWN BY	RTR	=
CHECKED BY	RBE	+
LAST MODIFICATION DATE		CURRENT PAGE
AIRPACK DWG NO.	17811-30B	
REVISION	02	
TOTAL PAGE AMOUNT	16	

 Internal targets

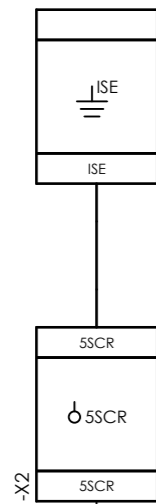

=20-C-7080+JIAX-C7080-01-TIT-71102

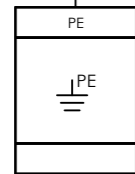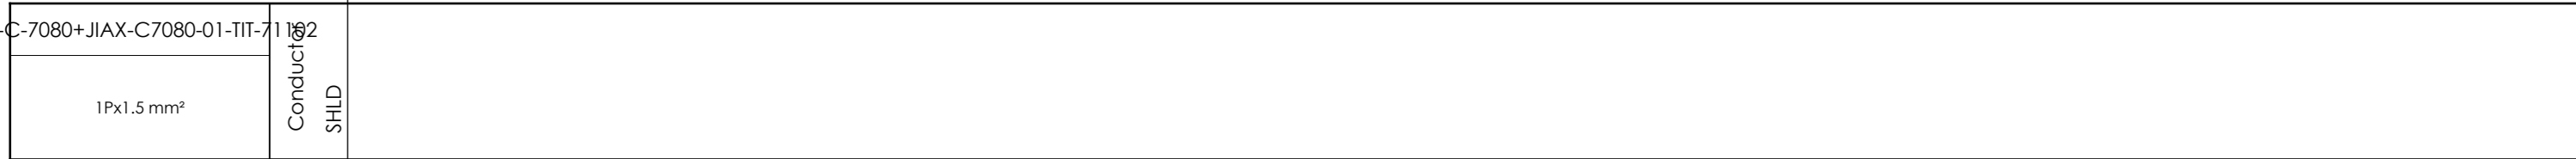



External targets





CLIENT DWG NO.	BU-20-VD-303-IN-DIG-0093
EQUIPMENT NO.	20-C-7080
EQUIPMENT LOCATION	Iran, Onshore
THIS DRAWING IS OWNED BY AIRPACK, AND SHALL NOT BE PRINTED OR COPIED IN ANY OTHER WAY THAN WITH AIRPACKS PERMISSION!	

SUBJECT		DRAWN BY		RTR		=	
Cable-connection diagram =20-C-7080+JIAX-C7080-01-TIT-71102		CHECKED BY		RBE		+	
ADAPTED TO P&ID REVISION	03	LAST MODIFICATION DATE		CURRENT PAGE			
CLIENT	Bushehr Petrochemical Company (BUPC)	AIRPACK DWG NO.		17811-30B			
CLIENT REF.	Bushehr MEG Plant Project	REVISION		02			
AIRPACK REF.	17811-30B	TOTAL PAGE AMOUNT		17			

 Internal targets

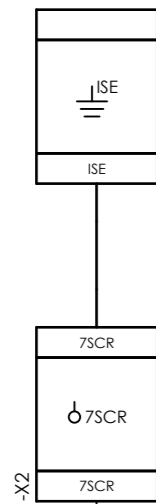

=20-C-7080+JIAX-C7080-01-VT-71101

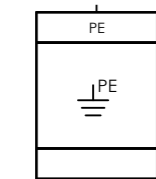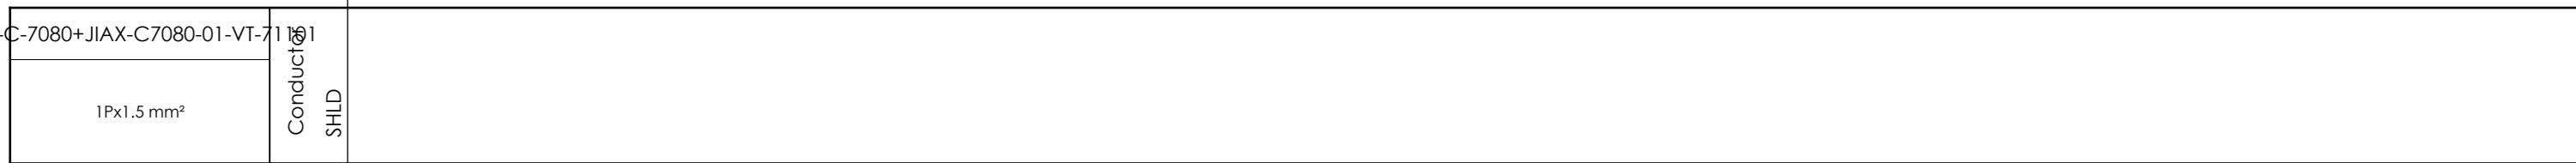

External targets






CLIENT DWG NO.	BU-20-VD-303-IN-DIG-0093
EQUIPMENT NO.	20-C-7080
EQUIPMENT LOCATION	Iran, Onshore
THIS DRAWING IS OWNED BY AIRPACK, AND SHALL NOT BE PRINTED OR COPIED IN ANY OTHER WAY THAN WITH AIRPACKS PERMISSION!	

SUBJECT		Cable-connection diagram =20-C-7080+JIAX-C7080-01-VT-71101	
ADAPTED TO P&ID REVISION	03	CLIENT	Bushehr Petrochemical Company (BUPC)
CLIENT REF.	Bushehr MEG Plant Project	AIRPACK REF.	17811-30B

DRAWN BY	RTR	=
CHECKED BY	RBE	+
LAST MODIFICATION DATE		CURRENT PAGE
AIRPACK DWG NO.	17811-30B	
REVISION	02	
TOTAL PAGE AMOUNT	18	

Internal targets

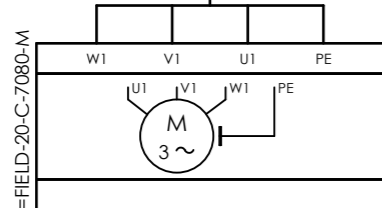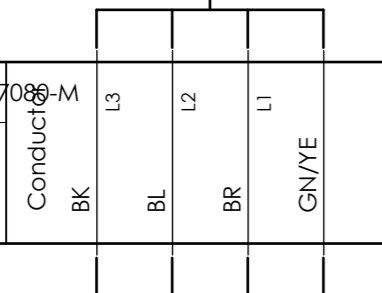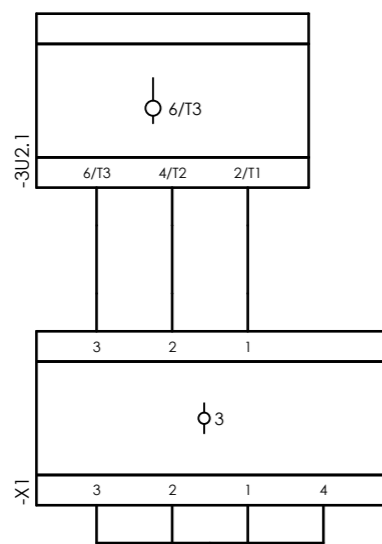

External targets

=20-C-7080+PD-C-7080-01-20-C-7080-M
4x6 sqmm
Conductors
L3 L2 L1
BK BL BR GN/YE




CLIENT DWG NO.	BU-20-VD-303-IN-DIG-0093
EQUIPMENT NO.	20-C-7080
EQUIPMENT LOCATION	Iran, Onshore
THIS DRAWING IS OWNED BY AIRPACK, AND SHALL NOT BE PRINTED OR COPIED IN ANY OTHER WAY THAN WITH AIRPACKS PERMISSION!	


SUBJECT Cable-connection diagram =20-C-7080+PD-C-7080-01-20-C-7080-M	
ADAPTED TO P&ID REVISION	03
CLIENT	Bushehr Petrochemical Company (BUPC)
CLIENT REF.	Bushehr MEG Plant Project
AIRPACK REF.	17811-30B

DRAWN BY	RTR	=
CHECKED BY	RBE	+
LAST MODIFICATION DATE		CURRENT PAGE
AIRPACK DWG NO.	17811-30B	
REVISION	02	
TOTAL PAGE AMOUNT	19	

Internal targets

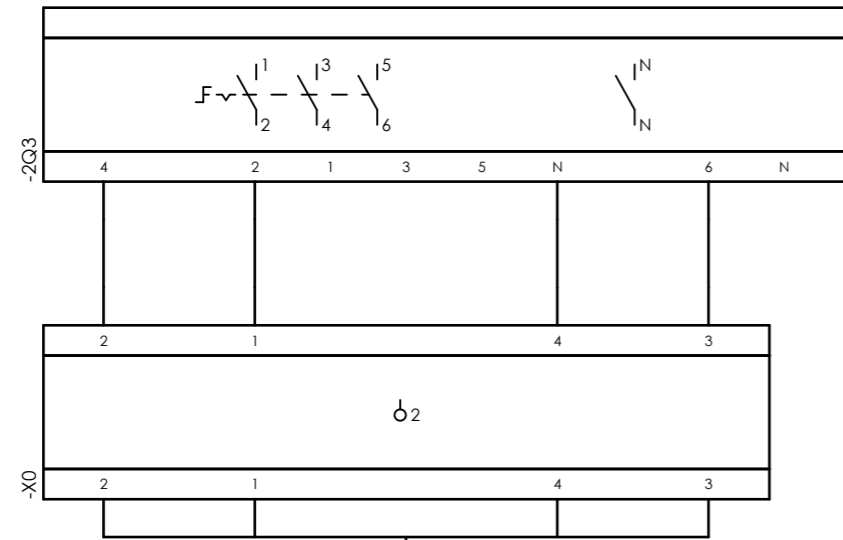


External targets

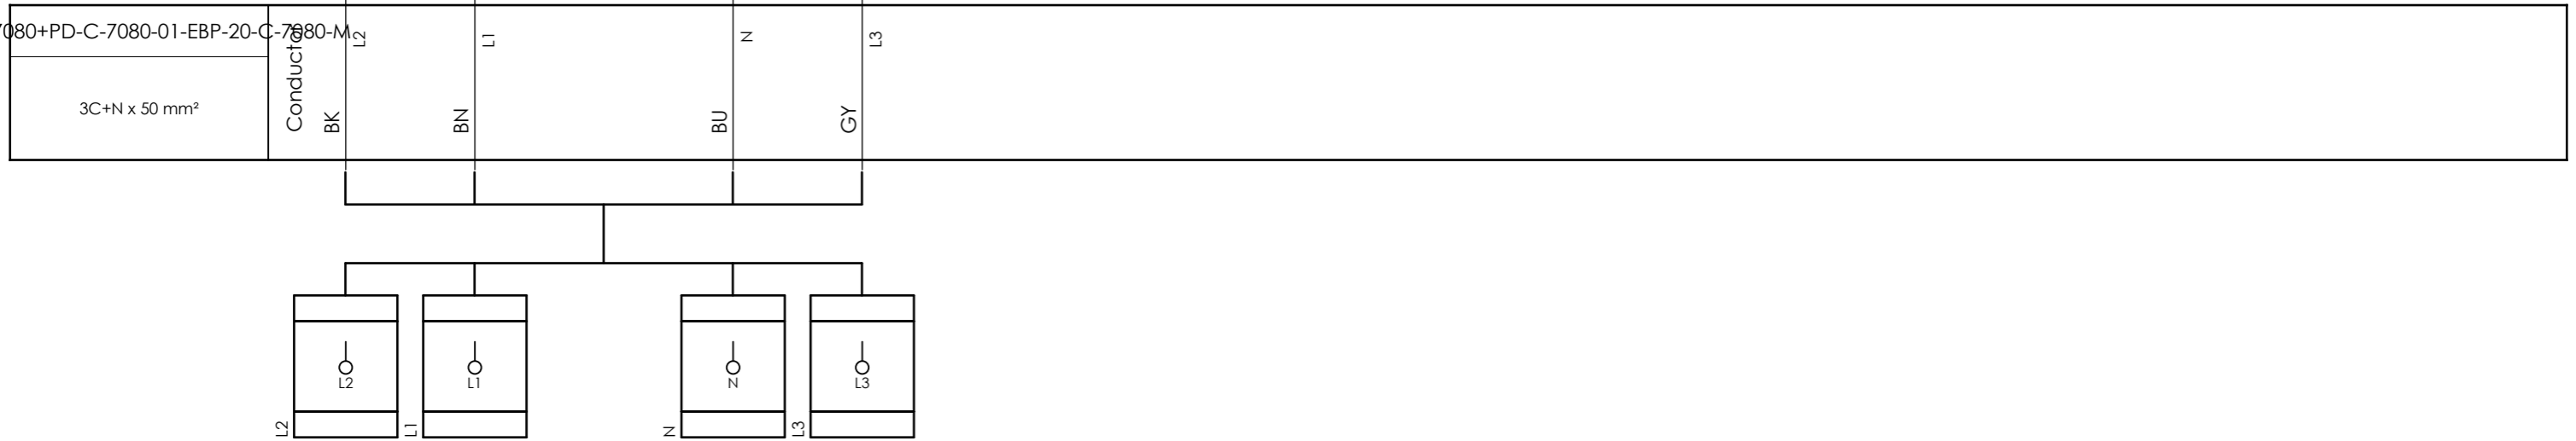

CLIENT DWG NO.	BU-20-VD-303-IN-DIG-0093
EQUIPMENT NO.	20-C-7080
EQUIPMENT LOCATION	Iran, Onshore
THIS DRAWING IS OWNED BY AIRPACK, AND SHALL NOT BE PRINTED OR COPIED IN ANY OTHER WAY THAN WITH AIRPACKS PERMISSION!	

SUBJECT		DRAWN BY	RTR	=
Cable-connection diagram =20-C-7080+PD-C-7080-01-EBP-20-C-7080-M		CHECKED BY	RBE	+
ADAPTED TO P&ID REVISION	03	LAST MODIFICATION DATE		CURRENT PAGE
CLIENT	Bushehr Petrochemical Company (BUPC)	AIRPACK DWG NO.	17811-30B	
CLIENT REF.	Bushehr MEG Plant Project	REVISION	02	
AIRPACK REF.	17811-30B	TOTAL PAGE AMOUNT	20	


Internal targets

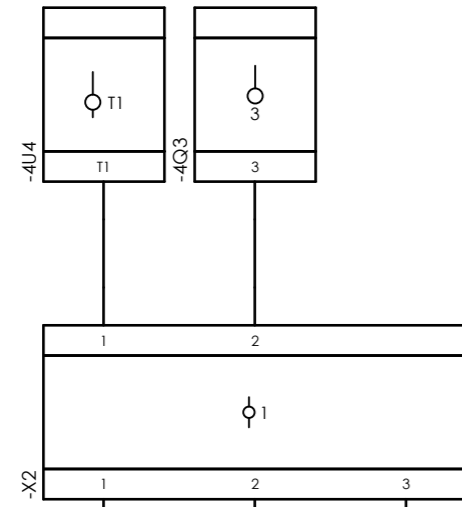

=20-C-7080+PD-C-7080-01-LG-71101



External targets

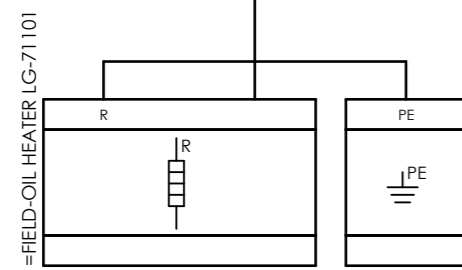

CLIENT DWG NO.	BU-20-VD-303-IN-DIG-0093
EQUIPMENT NO.	20-C-7080
EQUIPMENT LOCATION	Iran, Onshore
THIS DRAWING IS OWNED BY AIRPACK, AND SHALL NOT BE PRINTED OR COPIED IN ANY OTHER WAY THAN WITH AIRPACKS PERMISSION!	

SUBJECT		Cable-connection diagram =20-C-7080+PD-C-7080-01-LG-71101	
ADAPTED TO P&ID REVISION	03	CLIENT	Bushehr Petrochemical Company (BUPC)
CLIENT REF.	Bushehr MEG Plant Project	AIRPACK REF.	17811-30B

DRAWN BY	RTR	=
CHECKED BY	RBE	+
LAST MODIFICATION DATE		CURRENT PAGE
AIRPACK DWG NO.	17811-30B	
REVISION	02	
TOTAL PAGE AMOUNT	21	

