





OWNER:  شرکت سست و پتروشیمی آذربایجان (سهامی خاص)	BUSHEHR PETROCHEMICAL COMPANY MEG PLANT						EPC CONTRACTOR:  Chagalesh-Enerchimi-Steam Joint Venture BUPC-MEG PLANT PROJECT		
	LOOP DIAGRAM FOR NITROGEN GAS BOOSTER							 Netherlands	
MC :  شرکت سست و پتروشیمی آذربایجان (سهامی خاص)	Project	Area	Phase	Unit	Dis.	Doc.	Seq.	Contract No : 52-98/445	
Owner Document Number: 17811-30A	BU	20	VD	303	IN	DIG	0036	Rev.:	Page
								02	1 of 35

LOOP DIAGRAM FOR NITROGEN GAS BOOSTER

02	05/09/2022	Approved for Construction	RT	KP	JR	
01	15/07/2022	For approval	MG	RB	KP	
00	18/10/2021	For approval	HT	KP	JR	
Rev.	Date	Purpose of Issue	Prepared	Checked	Approved	AC Code
					Class: 1	Phase: P



Airpack B.V.

4301 RN Zierikzee
The Netherlands

PHONE: (31) (0) 111 - 415455

FAX: (31) (0) 111 - 413338

E-MAIL : AIRPACK@AIRPACK.NL

WEBPAGE : WWW.AIRPACK.NL

Client	:	Bushehr Petrochemical Company (BUPC)	
Equipment location	:	Iran, Onshore	
Client reference	:	Bushehr MEG Plant Project	
Client dwg. no.	:	BU-20-VD-303-IN-DIG-0043	
Airpack reference	:	17811-30A	
Airpack dwg. no.	:	17811-05	
Generation date	:	06-Nov-20	
E & I manager	:	RBE	Revision no. : 02
Last modifications	:	24-Aug-22	
Last modifications by	:	RTR	




CLIENT DWG NO.	BU-20-VD-303-IN-DIG-0043
EQUIPMENT NO.	20-C-1002
EQUIPMENT LOCATION	Iran, Onshore
THIS DRAWING IS OWNED BY AIRPACK, AND SHALL NOT BE PRINTED OR COPIED IN ANY OTHER WAY THAN WITH AIRPACKS PERMISSION!	


SUBJECT Title page / cover sheet	
ADAPTED TO P&ID REVISION	06
CLIENT	Bushehr Petrochemical Company (BUPC)
CLIENT REF.	Bushehr MEG Plant Project
AIRPACK REF.	17811-30A

DRAWN BY	RTR	=
CHECKED BY	RBE	+
LAST MODIFICATION DATE		CURRENT PAGE
AIRPACK DWG NO.	17811-05	
REVISION	02	
TOTAL PAGE AMOUNT	1	


Internal targets

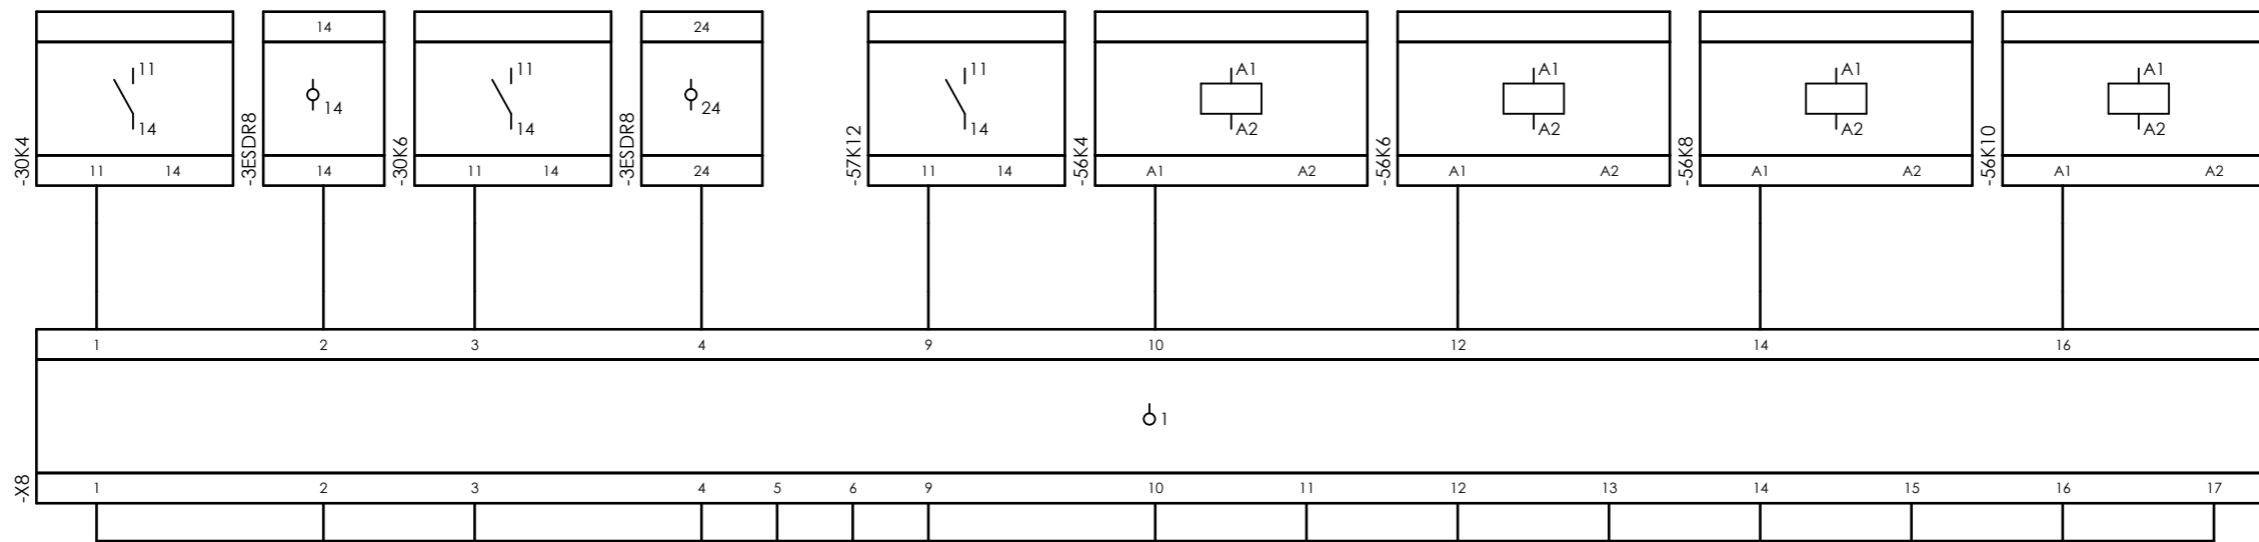

=20-C-1002+UCP-C1002-01-DB_COMA

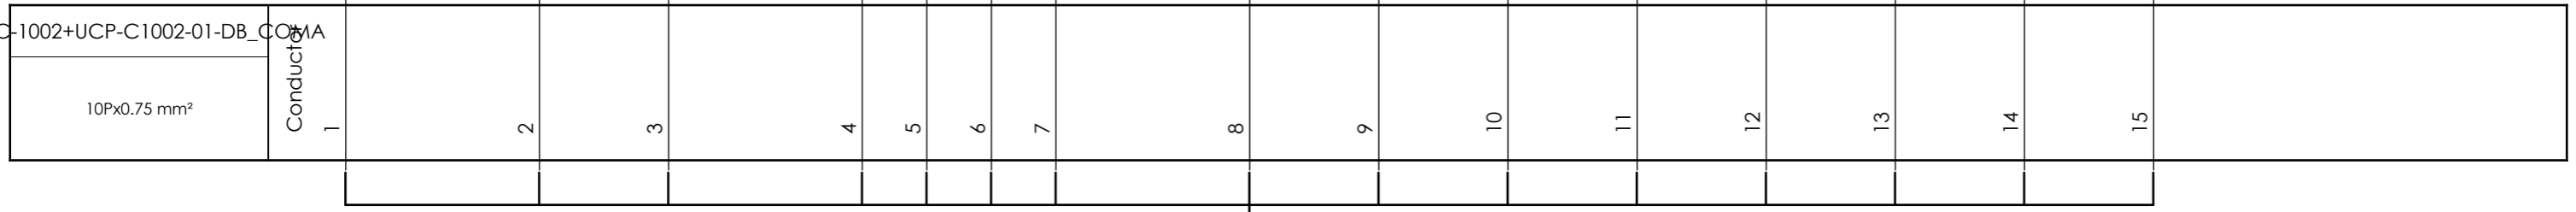

External targets

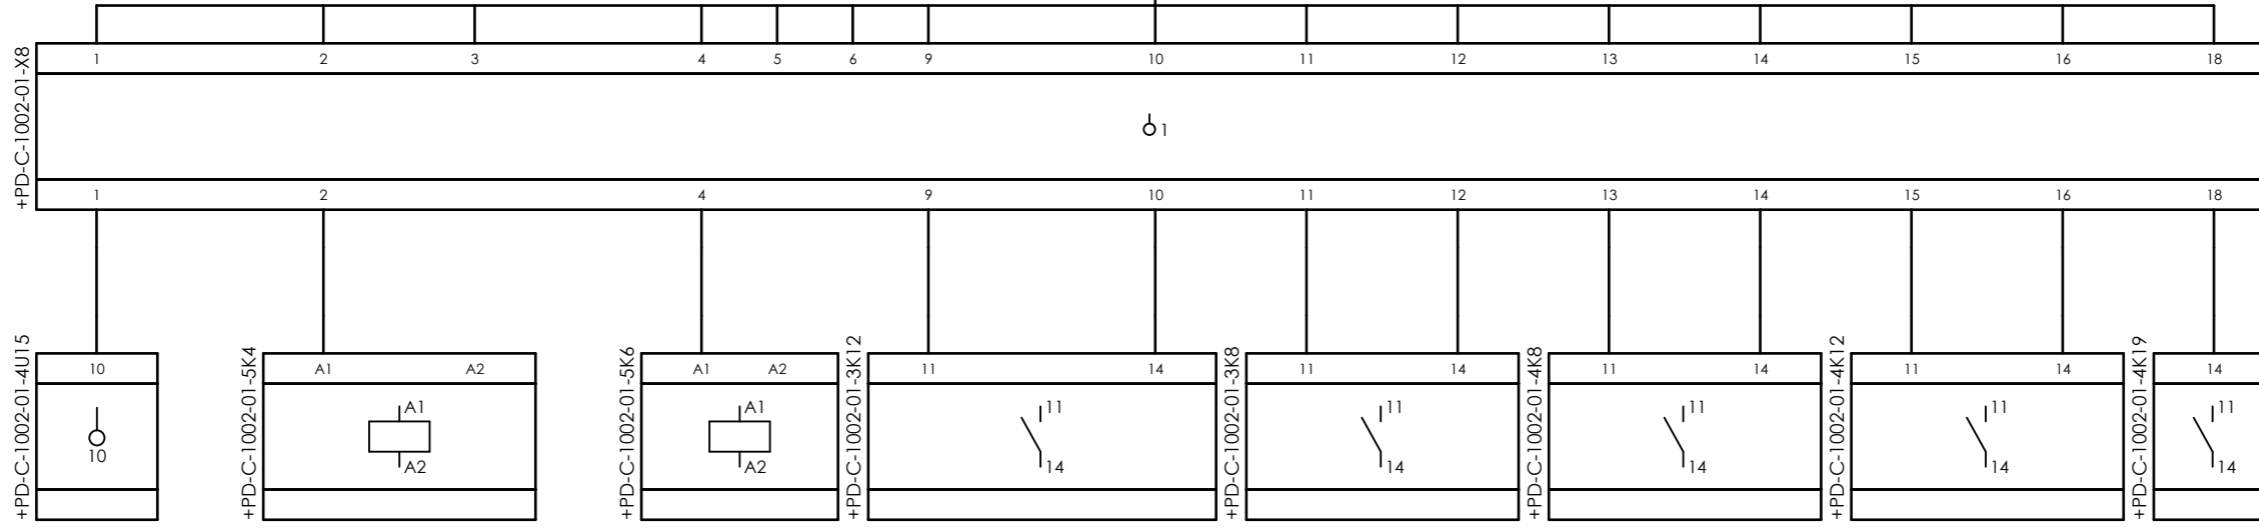


CLIENT DWG NO.	BU-20-VD-303-IN-DIG-0043
EQUIPMENT NO.	20-C-1002
EQUIPMENT LOCATION	Iran, Onshore
THIS DRAWING IS OWNED BY AIRPACK, AND SHALL NOT BE PRINTED OR COPIED IN ANY OTHER WAY THAN WITH AIRPACKS PERMISSION!	

SUBJECT		Cable-connection diagram =20-C-1002+UCP-C1002-01-DB_COMA	
ADAPTED TO P&ID REVISION	06		
CLIENT	Bushehr Petrochemical Company (BUPC)		
CLIENT REF.	Bushehr MEG Plant Project		
AIRPACK REF.	17811-30A		

DRAWN BY	RTR	=
CHECKED BY	RBE	+
LAST MODIFICATION DATE		
AIRPACK DWG NO.	17811-05	
REVISION	02	
TOTAL PAGE AMOUNT	2	

CURRENT PAGE	
2	


Internal targets

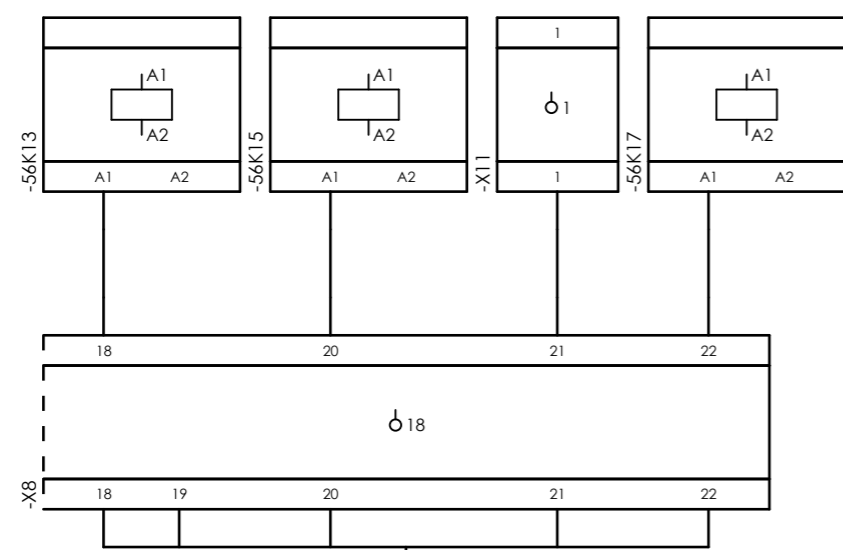

=20-C-1002+UCP-C1002-01-DB_COMA



External targets

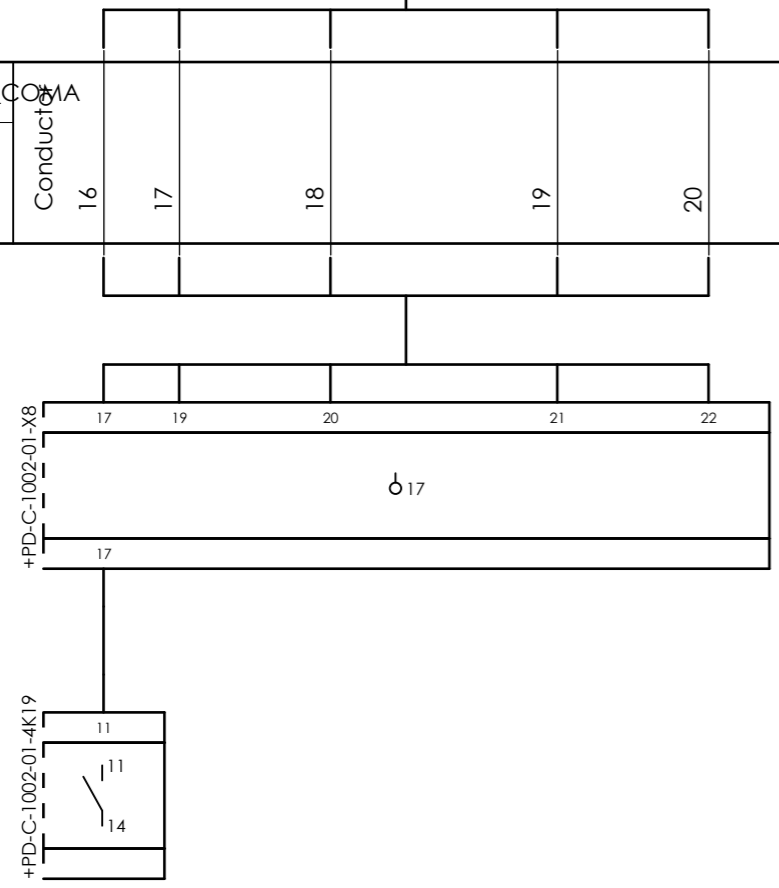


CLIENT DWG NO. BU-20-VD-303-IN-DIG-0043
 EQUIPMENT NO. 20-C-1002
 EQUIPMENT LOCATION Iran, Onshore
 THIS DRAWING IS OWNED BY AIRPACK, AND SHALL NOT BE PRINTED OR COPIED IN ANY OTHER WAY THAN WITH AIRPACKS PERMISSION!

SUBJECT Cable-connection diagram =20-C-1002+UCP-C1002-01-DB_COMA
 ADAPTED TO P&ID REVISION 06
 CLIENT Bushehr Petrochemical Company (BUPC)
 CLIENT REF. Bushehr MEG Plant Project
 AIRPACK REF. 17811-30A

DRAWN BY RTR
 CHECKED BY RBE
 LAST MODIFICATION DATE
 AIRPACK DWG NO. 17811-05
 REVISION 02
 TOTAL PAGE AMOUNT 3


=
 +
 CURRENT PAGE

Internal targets


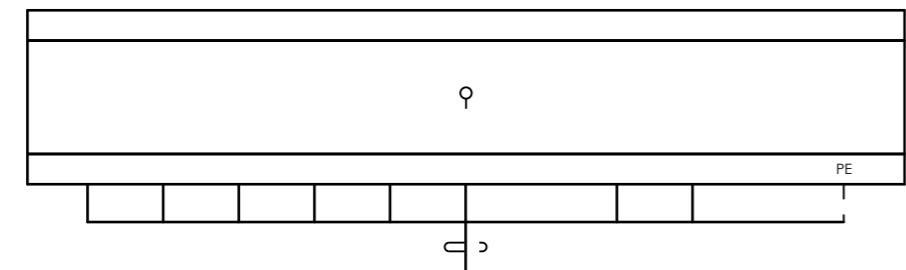


=20-C-1002+UCP-C1002-01-ESD

5Px0.75 mm² mm²

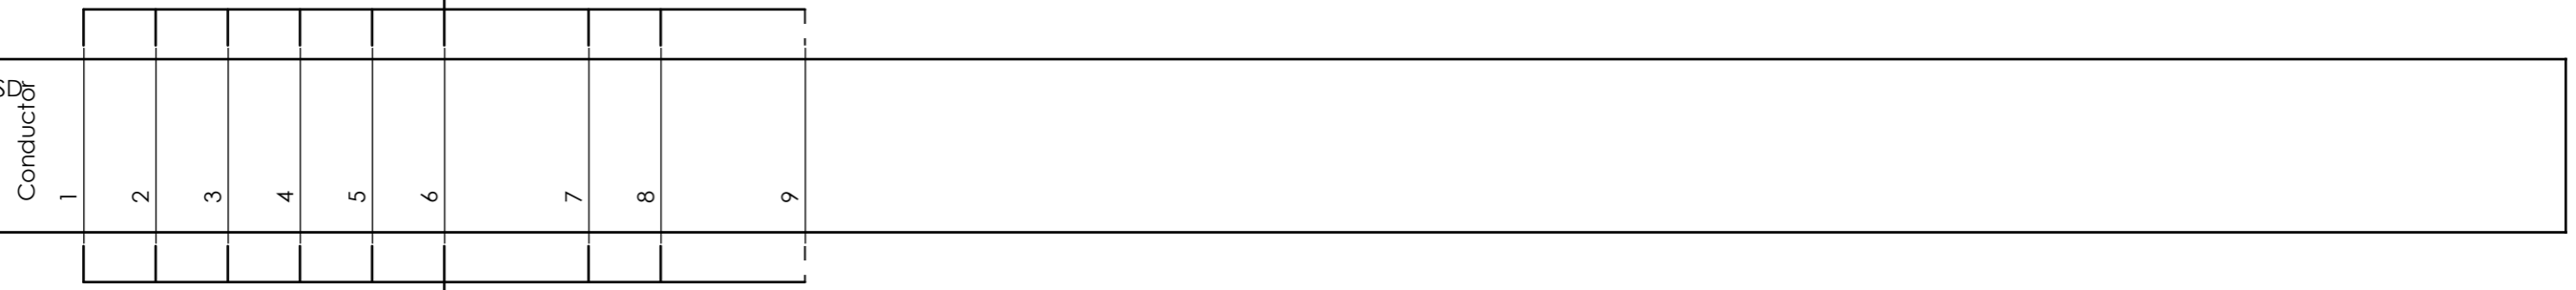

External targets

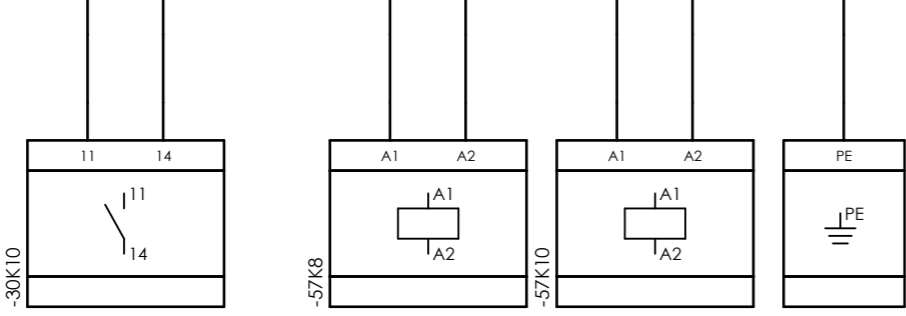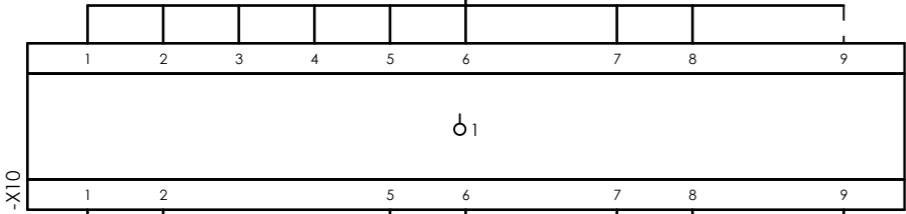


CLIENT DWG NO. BU-20-VD-303-IN-DIG-0043
 EQUIPMENT NO. 20-C-1002
 EQUIPMENT LOCATION Iran, Onshore
 THIS DRAWING IS OWNED BY AIRPACK, AND SHALL NOT BE PRINTED OR COPIED IN ANY OTHER WAY THAN WITH AIRPACKS PERMISSION!

SUBJECT Cable-connection diagram =20-C-1002+UCP-C1002-01-ESD
 ADAPTED TO P&ID REVISION 06
 CLIENT Bushehr Petrochemical Company (BUPC)
 CLIENT REF. Bushehr MEG Plant Project
 AIRPACK REF. 17811-30A


DRAWN BY RTR
 CHECKED BY RBE
 LAST MODIFICATION DATE
 AIRPACK DWG NO. 17811-05
 REVISION 02
 TOTAL PAGE AMOUNT 4

=
 +
 CURRENT PAGE

Internal targets



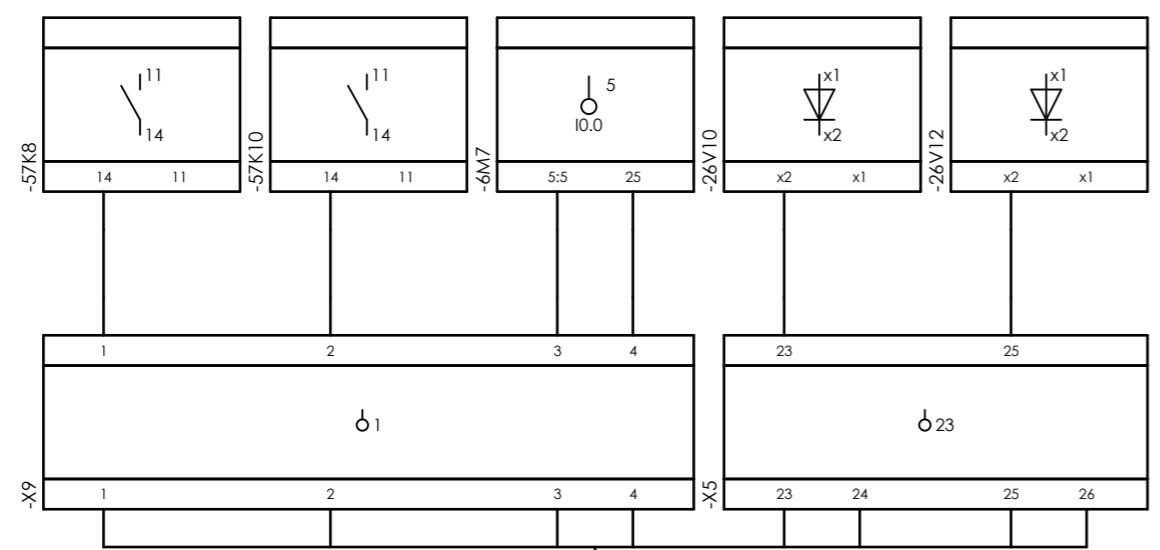


External targets


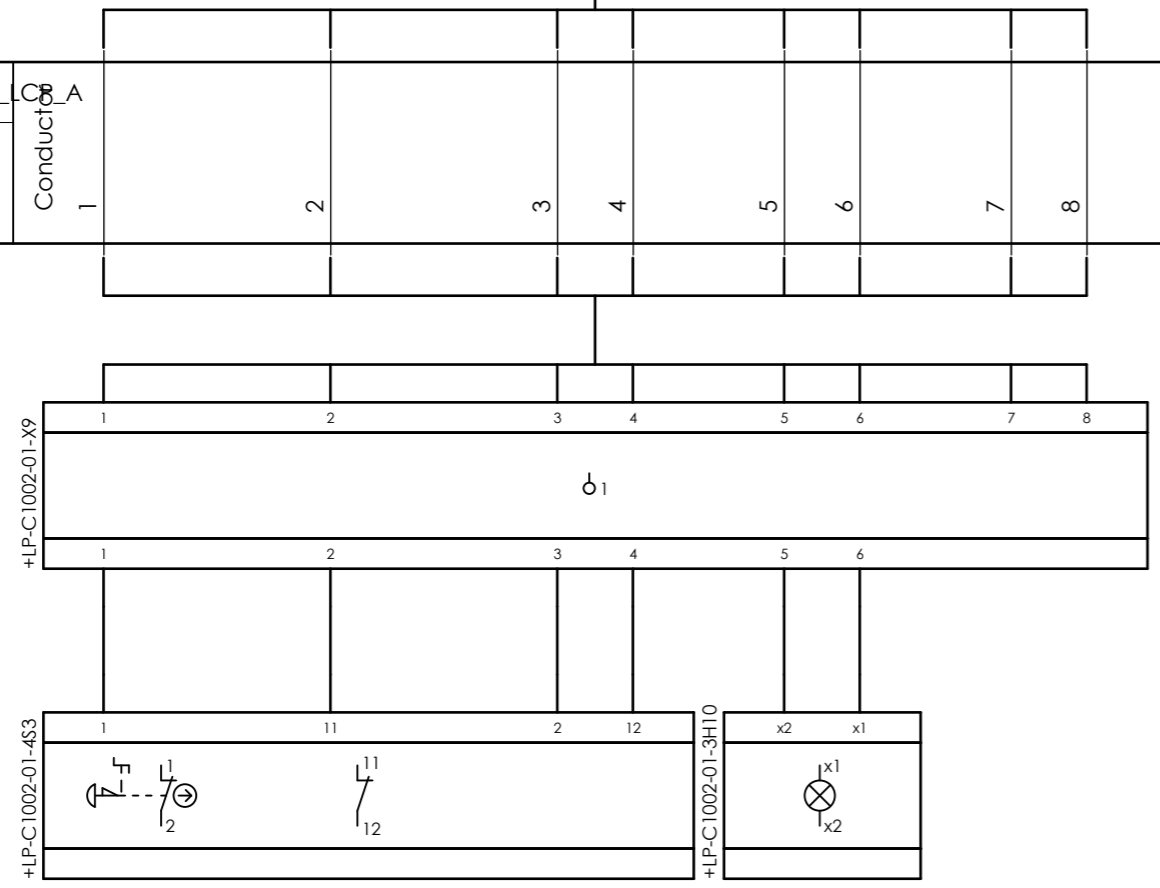


CLIENT DWG NO.	BU-20-VD-303-IN-DIG-0043	SUBJECT		DRAWN BY	RTR	=
EQUIPMENT NO.	20-C-1002	Cable-connection diagram =20-C-1002+UCP-C1002-01-ESD_LCP_A		CHECKED BY	RBE	+
EQUIPMENT LOCATION	Iran, Onshore	ADAPTED TO P&ID REVISION	06	LAST MODIFICATION DATE		CURRENT PAGE
THIS DRAWING IS OWNED BY AIRPACK, AND SHALL NOT BE PRINTED OR COPIED IN ANY OTHER WAY THAN WITH AIRPACKS PERMISSION!		CLIENT	Bushehr Petrochemical Company (BUPC)	AIRPACK DWG NO.	17811-05	
		CLIENT REF.	Bushehr MEG Plant Project	REVISION	02	
		AIRPACK REF.	17811-30A	TOTAL PAGE AMOUNT	5	

Internal targets

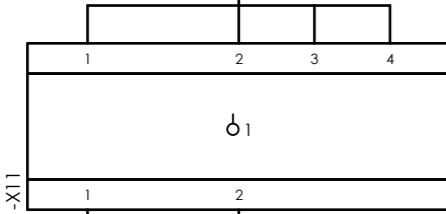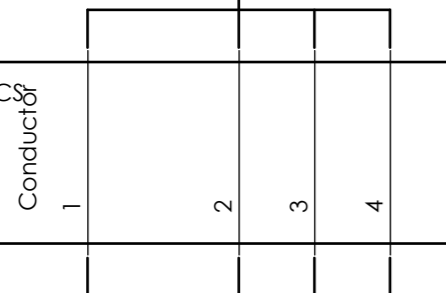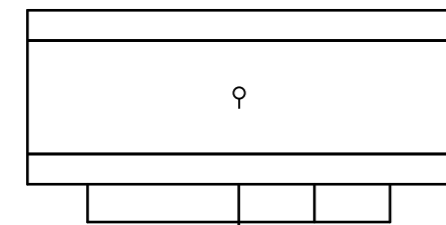

External targets

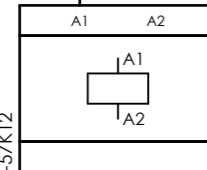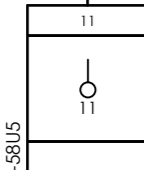

=20-C-1002+UCP-C1002-01-FCS
4Px1 mm² mm²
Conductors

-X11

-58U5

-57K12




CLIENT DWG NO.	BU-20-VD-303-IN-DIG-0043
EQUIPMENT NO.	20-C-1002
EQUIPMENT LOCATION	Iran, Onshore
THIS DRAWING IS OWNED BY AIRPACK, AND SHALL NOT BE PRINTED OR COPIED IN ANY OTHER WAY THAN WITH AIRPACKS PERMISSION!	


SUBJECT		Cable-connection diagram =20-C-1002+UCP-C1002-01-FCS	
ADAPTED TO P&ID REVISION	06	CLIENT	Bushehr Petrochemical Company (BUPC)
CLIENT REF.	Bushehr MEG Plant Project	AIRPACK REF.	17811-30A

DRAWN BY	RTR	=
CHECKED BY	RBE	+
LAST MODIFICATION DATE		CURRENT PAGE
AIRPACK DWG NO.	17811-05	
REVISION	02	
TOTAL PAGE AMOUNT	6	

Internal targets

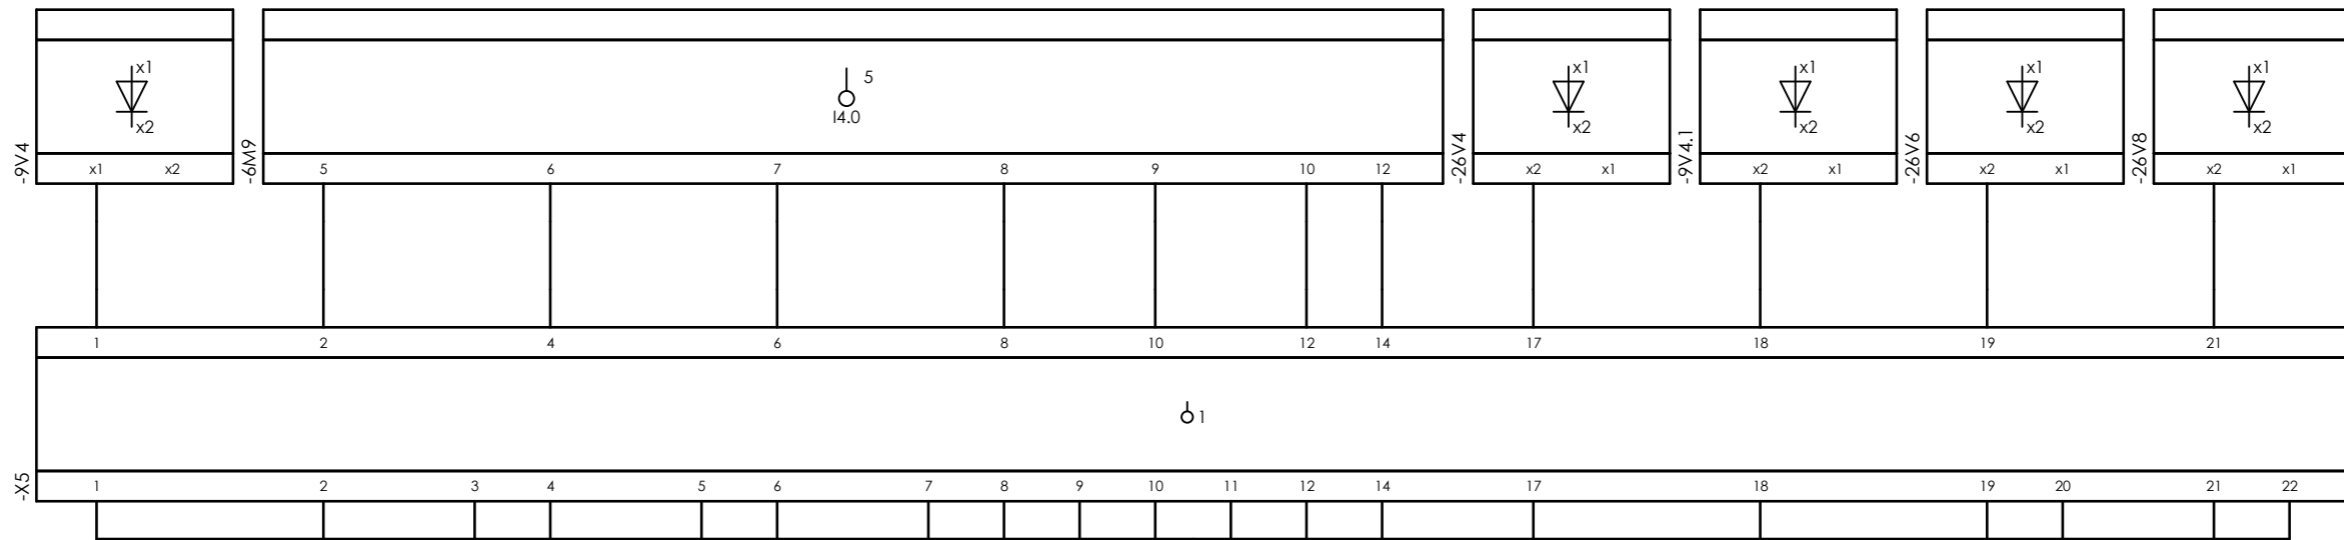

External targets

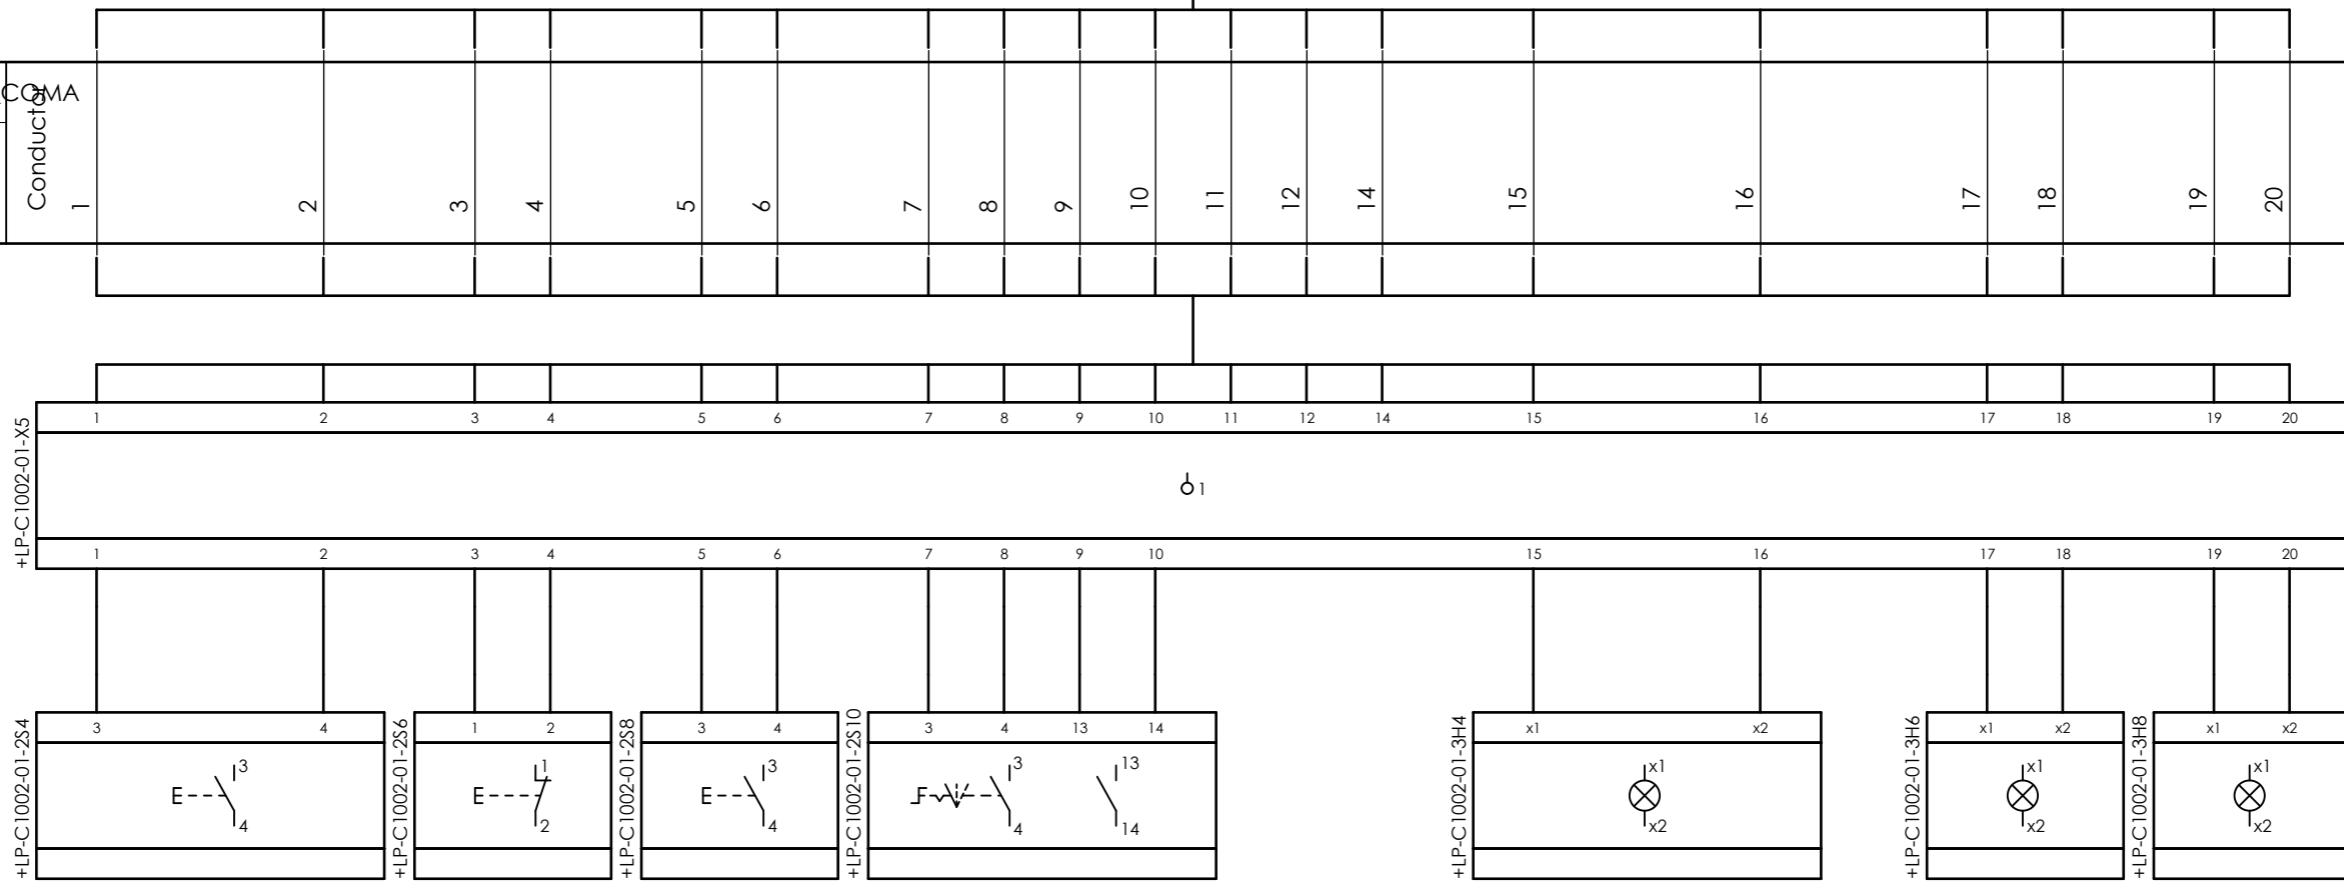


CLIENT DWG NO. BU-20-VD-303-IN-DIG-0043
 EQUIPMENT NO. 20-C-1002
 EQUIPMENT LOCATION Iran, Onshore
 THIS DRAWING IS OWNED BY AIRPACK, AND SHALL NOT BE PRINTED OR COPIED IN ANY OTHER WAY THAN WITH AIRPACKS PERMISSION!

SUBJECT Cable-connection diagram =20-C-1002+UCP-C1002-01-LCP_COMA
 ADAPTED TO P&ID REVISION 06
 CLIENT Bushehr Petrochemical Company (BUPC)
 CLIENT REF. Bushehr MEG Plant Project
 AIRPACK REF. 17811-30A


DRAWN BY RTR
 CHECKED BY RBE
 LAST MODIFICATION DATE
 AIRPACK DWG NO. 17811-05
 REVISION 02
 TOTAL PAGE AMOUNT 7

=
 +
 CURRENT PAGE
 7


Internal targets

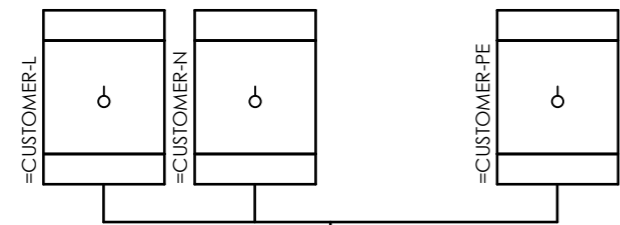

=20-C-1002+UCP-C1002-01-PS_00
3x2.5 sqmm

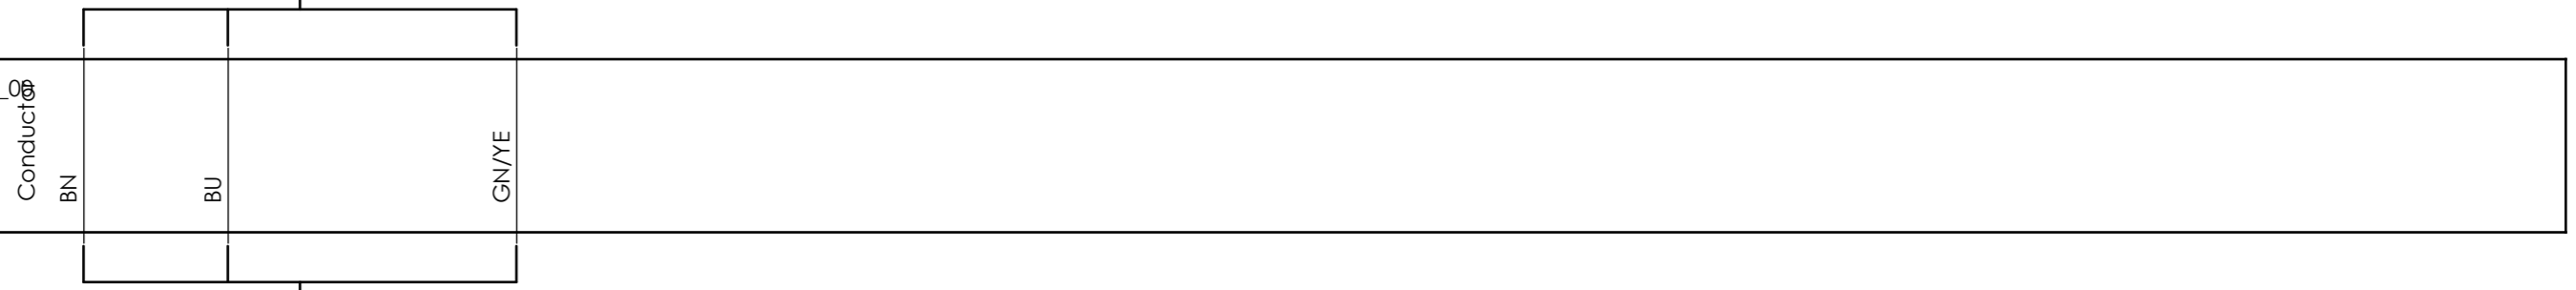


External targets

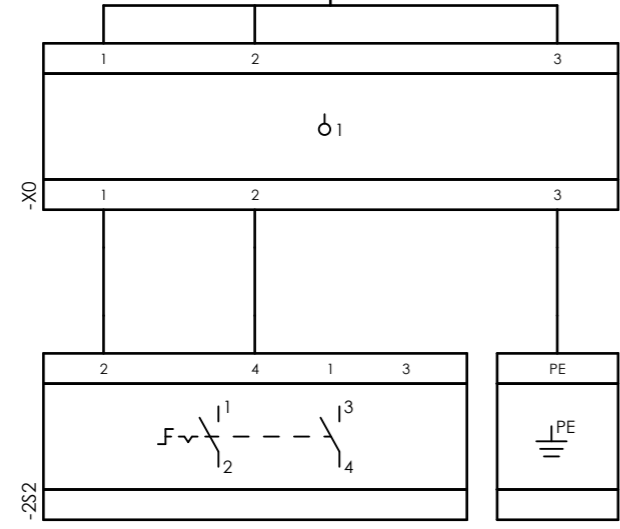


CLIENT DWG NO.	BU-20-VD-303-IN-DIG-0043
EQUIPMENT NO.	20-C-1002
EQUIPMENT LOCATION	Iran, Onshore
THIS DRAWING IS OWNED BY AIRPACK, AND SHALL NOT BE PRINTED OR COPIED IN ANY OTHER WAY THAN WITH AIRPACKS PERMISSION!	

SUBJECT		DRAWN BY	RTR	=
Cable-connection diagram =20-C-1002+UCP-C1002-01-PS_00		CHECKED BY	RBE	+
ADAPTED TO P&ID REVISION	06	LAST MODIFICATION DATE		CURRENT PAGE
CLIENT	Bushehr Petrochemical Company (BUPC)	AIRPACK DWG NO.	17811-05	
CLIENT REF.	Bushehr MEG Plant Project	REVISION	02	
AIRPACK REF.	17811-30A	TOTAL PAGE AMOUNT	8	


Internal targets

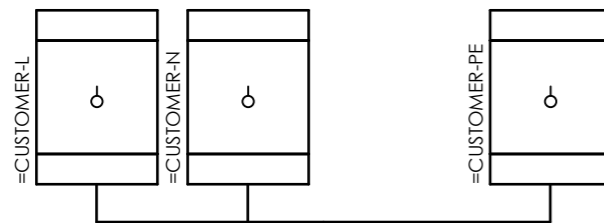

=20-C-1002+UCP-C1002-01-PS_01
3x2.5 sqmm

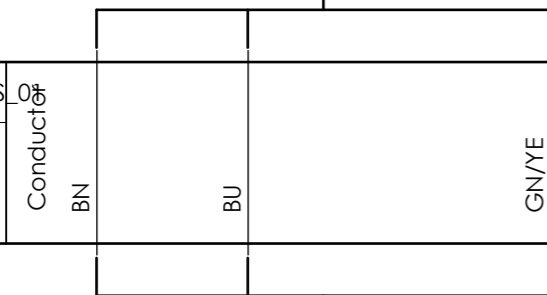

External targets

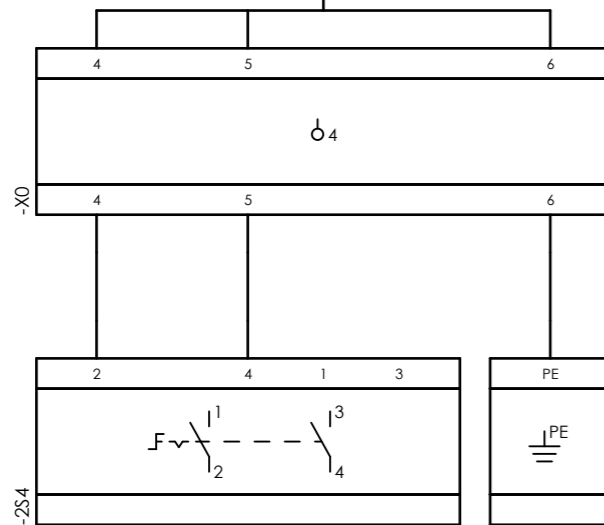


CLIENT DWG NO.	BU-20-VD-303-IN-DIG-0043
EQUIPMENT NO.	20-C-1002
EQUIPMENT LOCATION	Iran, Onshore
THIS DRAWING IS OWNED BY AIRPACK, AND SHALL NOT BE PRINTED OR COPIED IN ANY OTHER WAY THAN WITH AIRPACKS PERMISSION!	


SUBJECT		Cable-connection diagram =20-C-1002+UCP-C1002-01-PS_01	
ADAPTED TO P&ID REVISION	06	CLIENT	Bushehr Petrochemical Company (BUPC)
CLIENT REF.	Bushehr MEG Plant Project	AIRPACK REF.	17811-30A

DRAWN BY	RTR	=
CHECKED BY	RBE	+
LAST MODIFICATION DATE		CURRENT PAGE
AIRPACK DWG NO.	17811-05	
REVISION	02	
TOTAL PAGE AMOUNT	9	


Internal targets

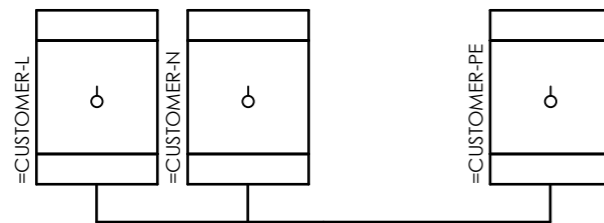

=20-C-1002+UCP-C1002-01-PS_02
3x2.5 sqmm

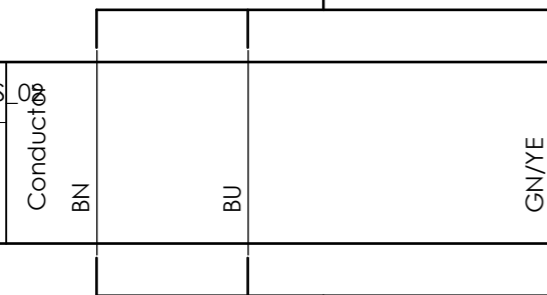

External targets

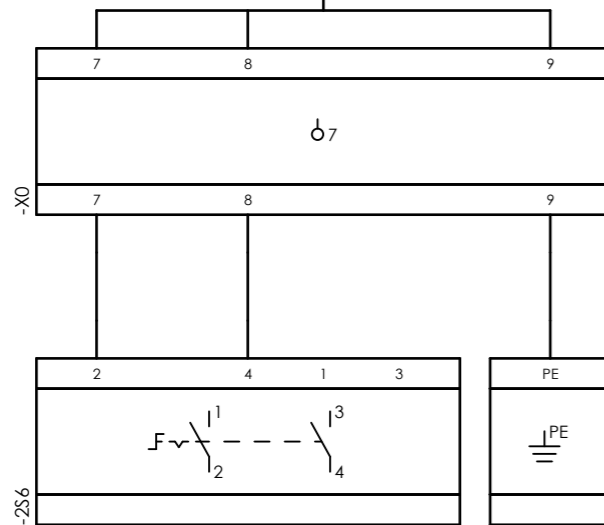


CLIENT DWG NO.	BU-20-VD-303-IN-DIG-0043
EQUIPMENT NO.	20-C-1002
EQUIPMENT LOCATION	Iran, Onshore
THIS DRAWING IS OWNED BY AIRPACK, AND SHALL NOT BE PRINTED OR COPIED IN ANY OTHER WAY THAN WITH AIRPACKS PERMISSION!	

SUBJECT Cable-connection diagram =20-C-1002+UCP-C1002-01-PS_02	
ADAPTED TO P&ID REVISION	06
CLIENT	Bushehr Petrochemical Company (BUPC)
CLIENT REF.	Bushehr MEG Plant Project
AIRPACK REF.	17811-30A

DRAWN BY	RTR	=
CHECKED BY	RBE	+
LAST MODIFICATION DATE		CURRENT PAGE
AIRPACK DWG NO.	17811-05	
REVISION	02	
TOTAL PAGE AMOUNT	10	

Internal targets



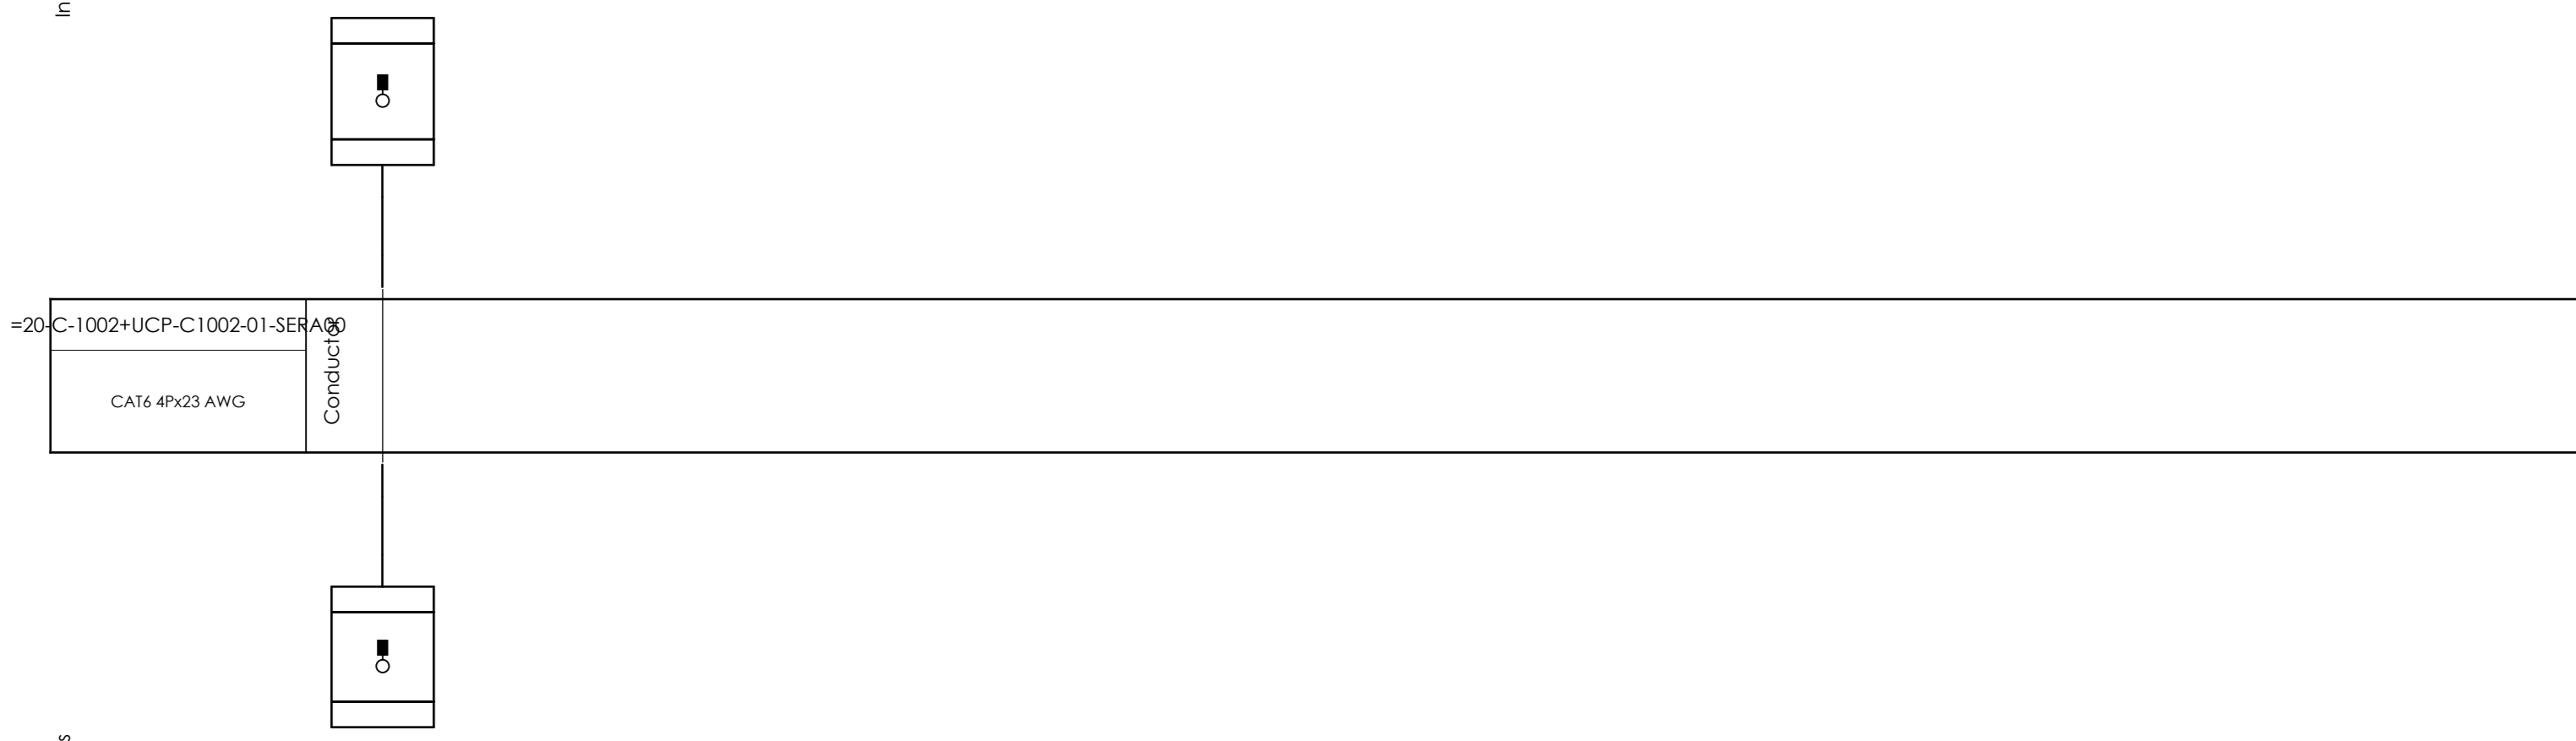


External targets



CLIENT DWG NO.	BU-20-VD-303-IN-DIG-0043	SUBJECT		DRAWN BY	RTR	=
EQUIPMENT NO.	20-C-1002	Cable-connection diagram =20-C-1002+UCP-C1002-01-SERA00		CHECKED BY	RBE	+
EQUIPMENT LOCATION	Iran, Onshore	ADAPTED TO P&ID REVISION	06	LAST MODIFICATION DATE		CURRENT PAGE
THIS DRAWING IS OWNED BY AIRPACK, AND SHALL NOT BE PRINTED OR COPIED IN ANY OTHER WAY THAN WITH AIRPACKS PERMISSION!		CLIENT	Bushehr Petrochemical Company (BUPC)	AIRPACK DWG NO.	17811-05	
		CLIENT REF.	Bushehr MEG Plant Project	REVISION	02	
		AIRPACK REF.	17811-30A	TOTAL PAGE AMOUNT	11	

Internal targets

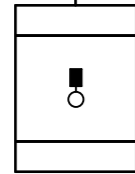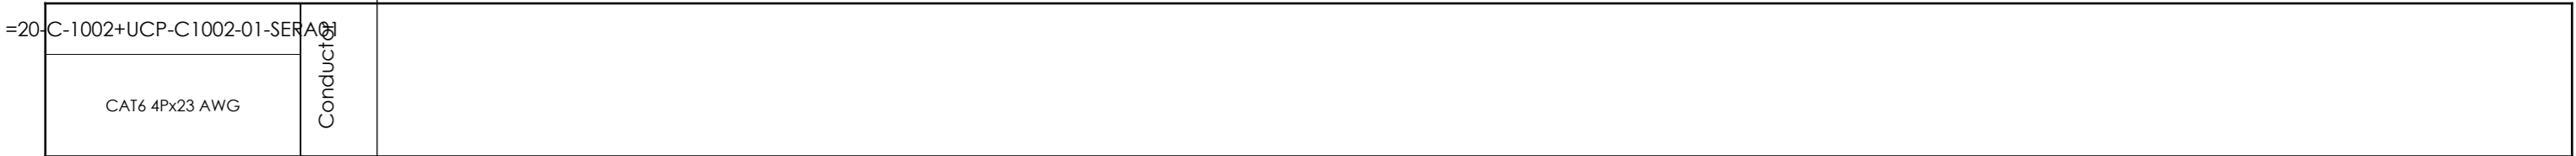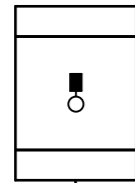

External targets



CLIENT DWG NO.	BU-20-VD-303-IN-DIG-0043
EQUIPMENT NO.	20-C-1002
EQUIPMENT LOCATION	Iran, Onshore

SUBJECT	
Cable-connection diagram =20-C-1002+UCP-C1002-01-SERA01	
ADAPTED TO P&ID REVISION	06

DRAWN BY	RTR	=
CHECKED BY	RBE	+
LAST MODIFICATION DATE		


THIS DRAWING IS OWNED BY AIRPACK, AND SHALL NOT BE PRINTED OR COPIED IN ANY OTHER WAY THAN WITH AIRPACKS PERMISSION!

CLIENT	Bushehr Petrochemical Company (BUPC)
CLIENT REF.	Bushehr MEG Plant Project
AIRPACK REF.	17811-30A


AIRPACK DWG NO.	17811-05
REVISION	02
TOTAL PAGE AMOUNT	12

CURRENT PAGE

Internal targets

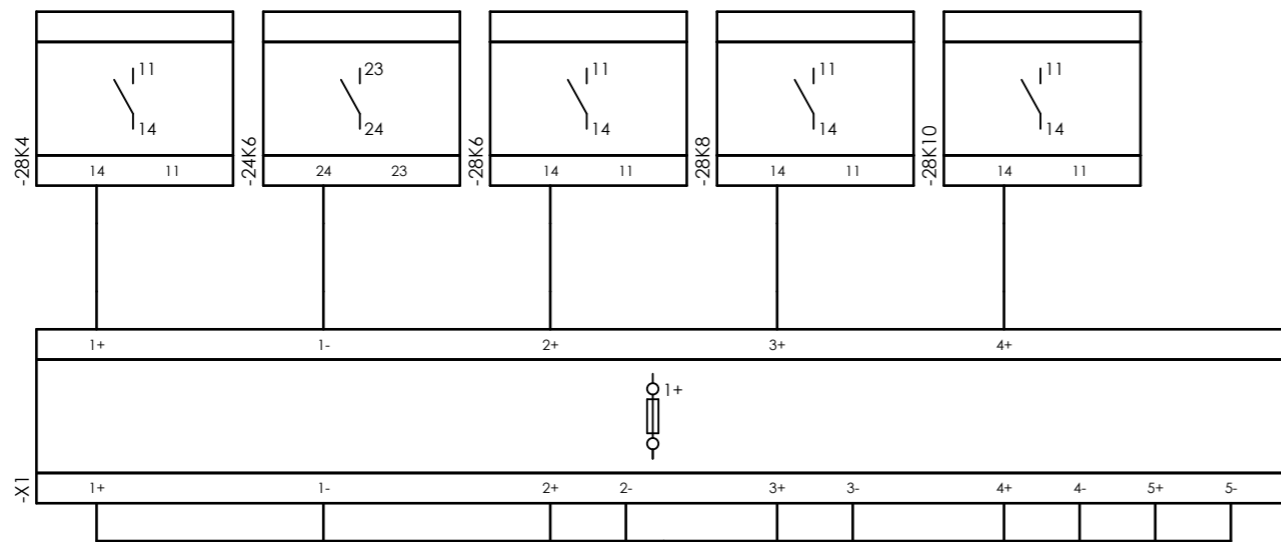

External targets

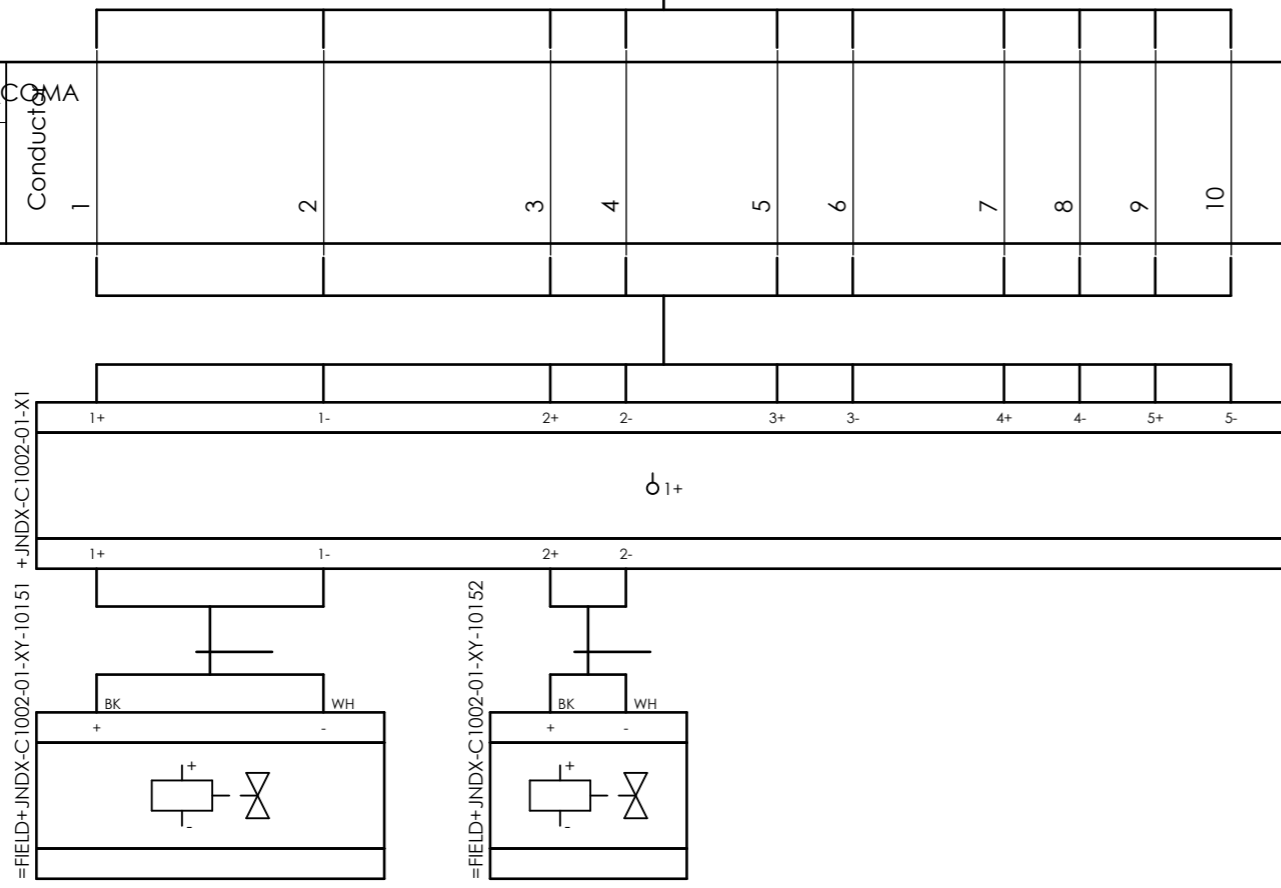


CLIENT DWG NO.	BU-20-VD-303-IN-DIG-0043
EQUIPMENT NO.	20-C-1002
EQUIPMENT LOCATION	Iran, Onshore
THIS DRAWING IS OWNED BY AIRPACK, AND SHALL NOT BE PRINTED OR COPIED IN ANY OTHER WAY THAN WITH AIRPACKS PERMISSION!	


SUBJECT Cable-connection diagram =20-C-1002+UCP-C1002-01-SOL_COMA	
ADAPTED TO P&ID REVISION	06
CLIENT	Bushehr Petrochemical Company (BUPC)
CLIENT REF.	Bushehr MEG Plant Project
AIRPACK REF.	17811-30A

DRAWN BY	RTR	=
CHECKED BY	RBE	+
LAST MODIFICATION DATE		CURRENT PAGE
AIRPACK DWG NO.	17811-05	
REVISION	02	
TOTAL PAGE AMOUNT	13	


Internal targets

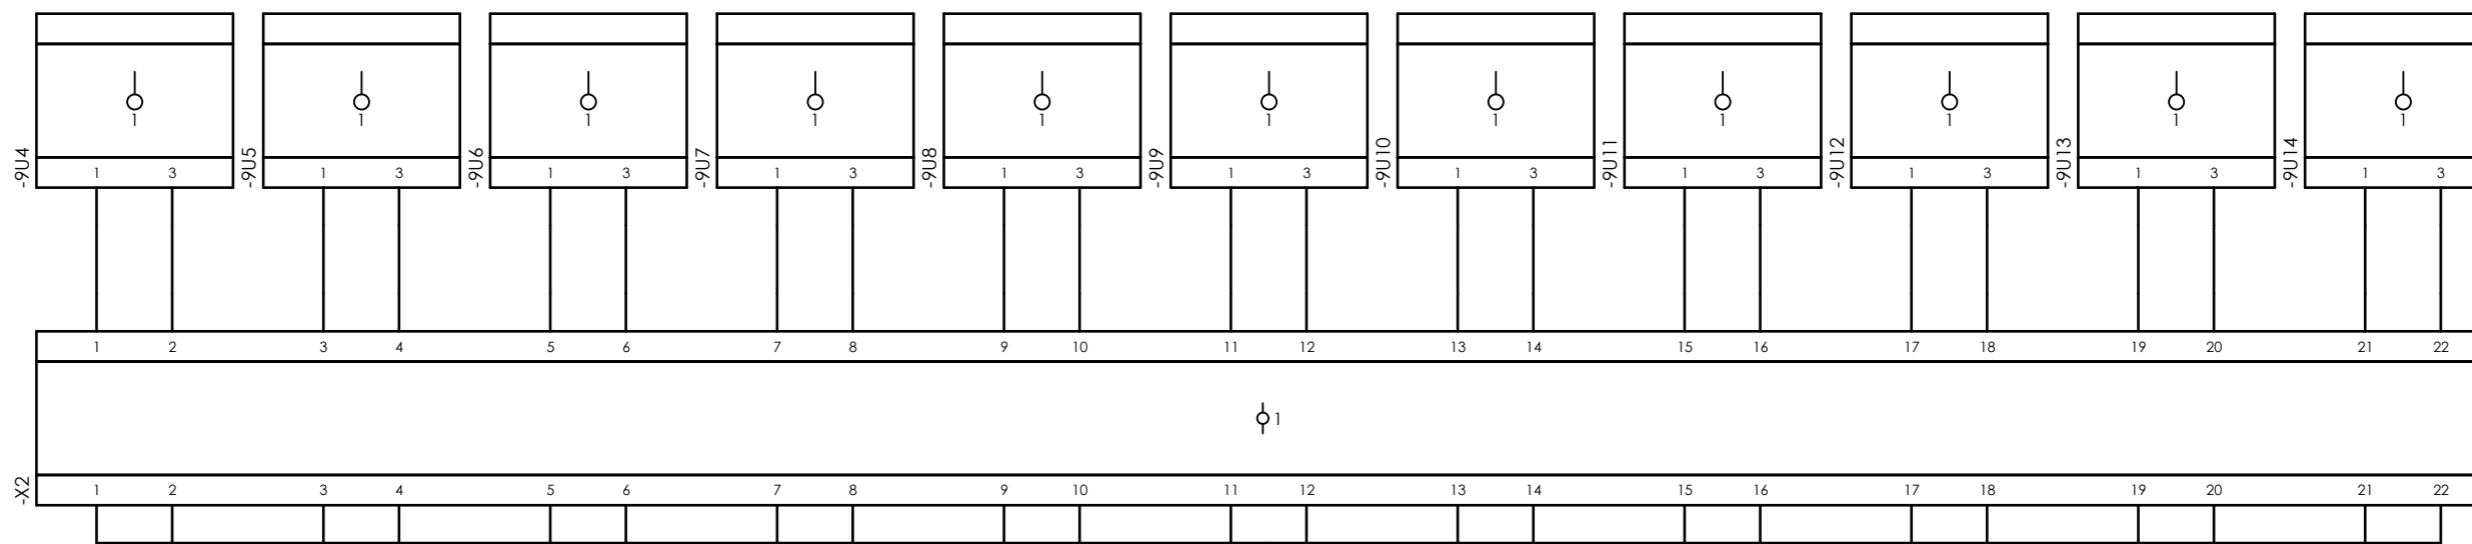

=20-C-1002+UCP-C1002-01-TR_COMA

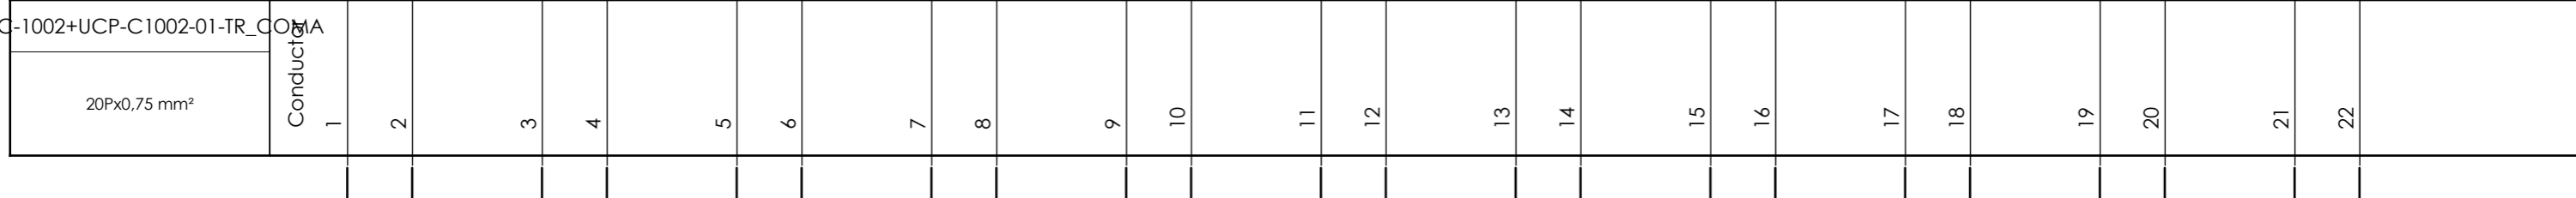

External targets

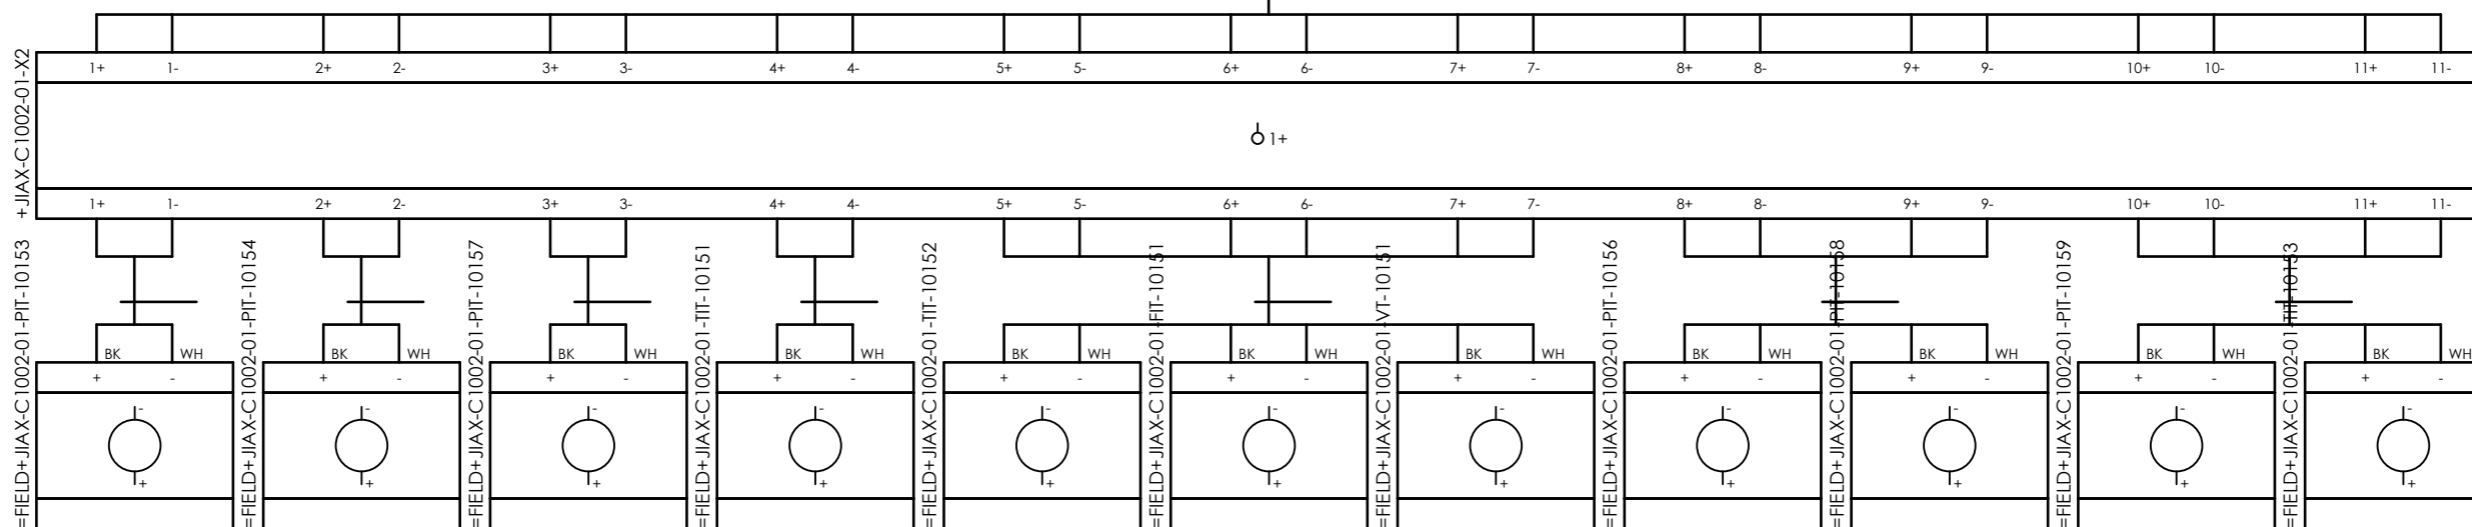


CLIENT DWG NO.	BU-20-VD-303-IN-DIG-0043
EQUIPMENT NO.	20-C-1002
EQUIPMENT LOCATION	Iran, Onshore
THIS DRAWING IS OWNED BY AIRPACK, AND SHALL NOT BE PRINTED OR COPIED IN ANY OTHER WAY THAN WITH AIRPACKS PERMISSION!	


SUBJECT		Cable-connection diagram =20-C-1002+UCP-C1002-01-TR_COMA	
ADAPTED TO P&ID REVISION	06		
CLIENT	Bushehr Petrochemical Company (BUPC)		
CLIENT REF.	Bushehr MEG Plant Project		
AIRPACK REF.	17811-30A		

DRAWN BY	RTR	CURRENT PAGE
CHECKED BY	RBE	
LAST MODIFICATION DATE		
AIRPACK DWG NO.	17811-05	
REVISION	02	
TOTAL PAGE AMOUNT	14	


Internal targets

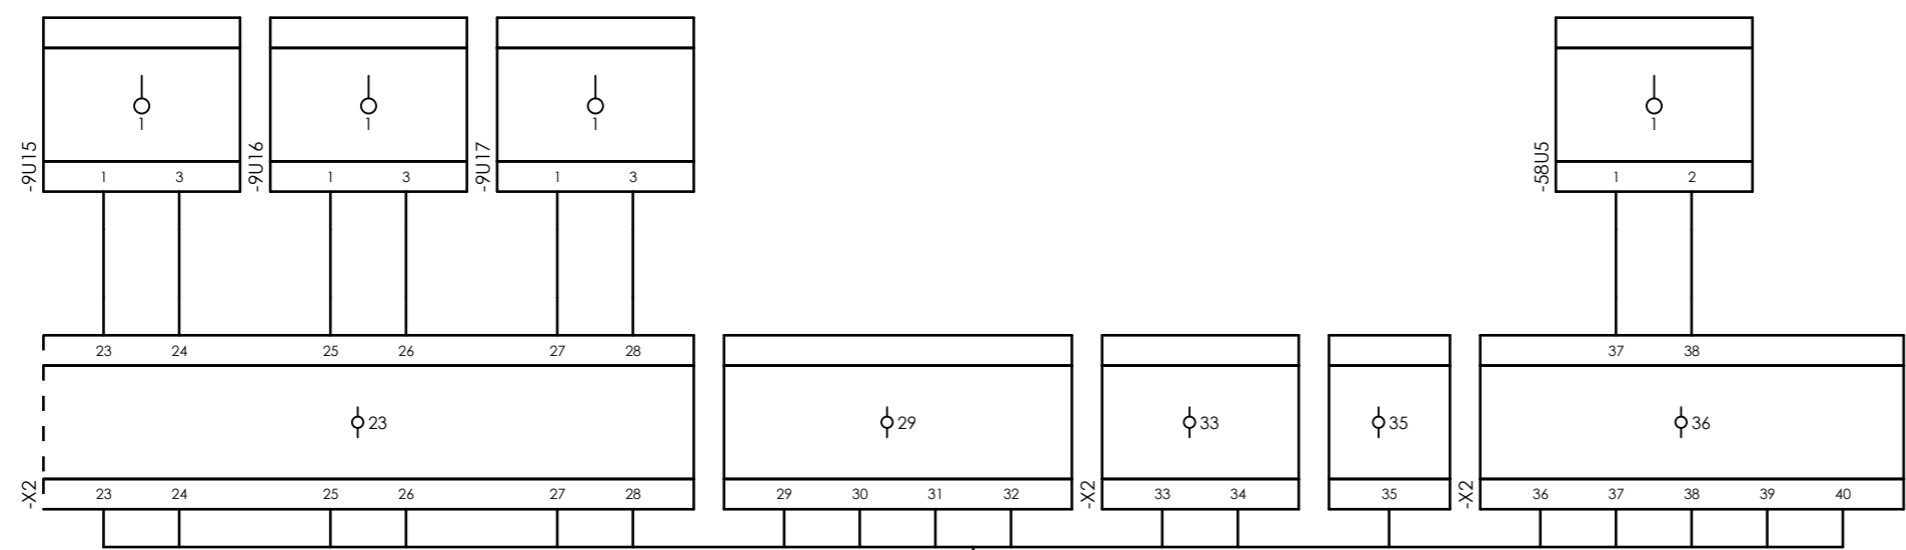

=20-C-1002+UCP-C1002-01-TR_COMA

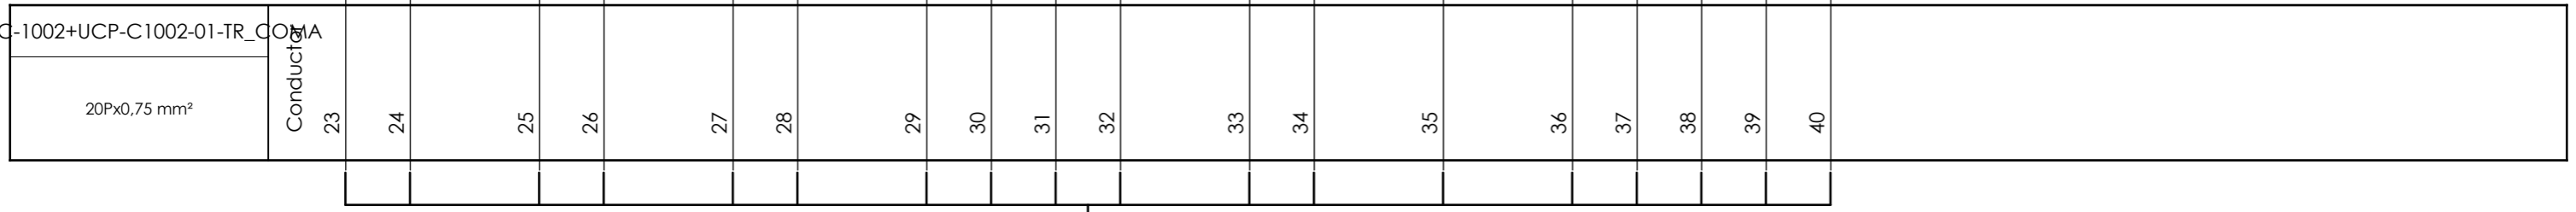


External targets

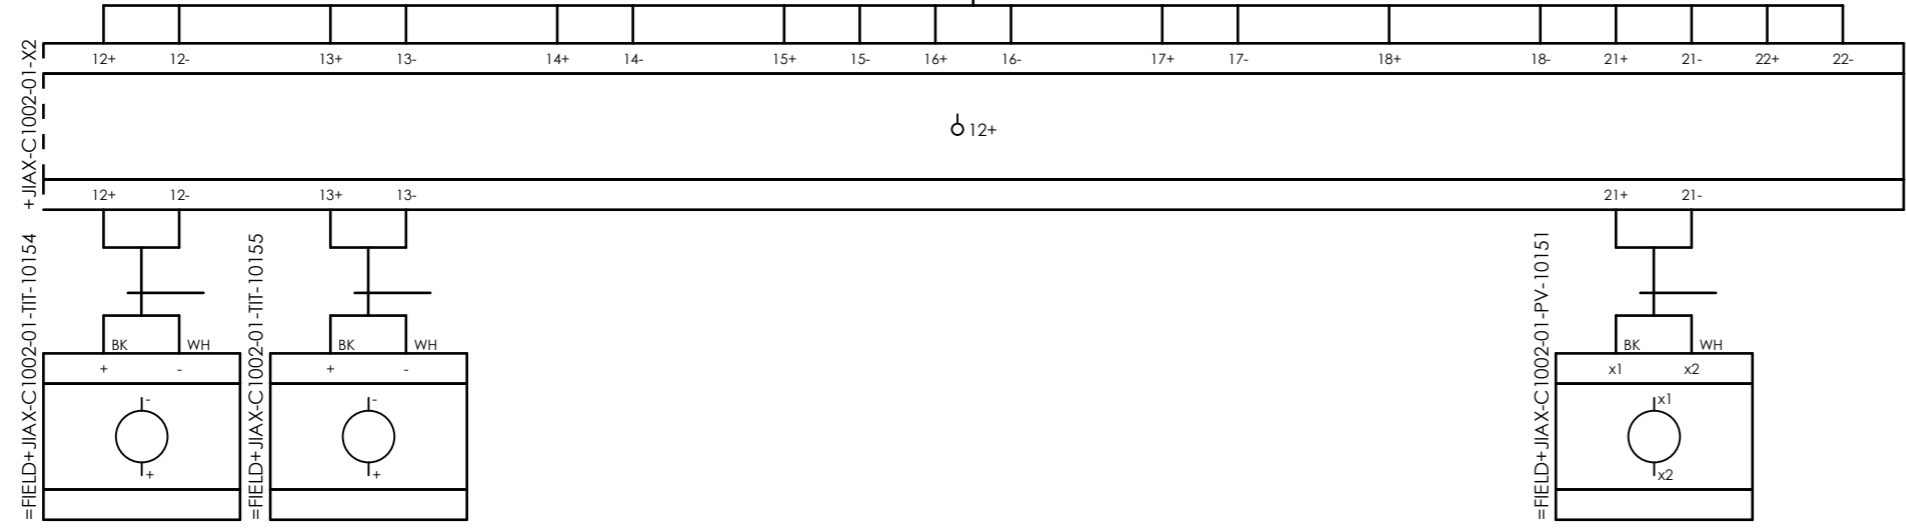

CLIENT DWG NO.	BU-20-VD-303-IN-DIG-0043	SUBJECT	Cable-connection diagram =20-C-1002+UCP-C1002-01-TR_COMA
EQUIPMENT NO.	20-C-1002	ADAPTED TO P&ID REVISION	06
EQUIPMENT LOCATION	Iran, Onshore	CLIENT	Bushehr Petrochemical Company (BUPC)
THIS DRAWING IS OWNED BY AIRPACK, AND SHALL NOT BE PRINTED OR COPIED IN ANY OTHER WAY THAN WITH AIRPACKS PERMISSION!		CLIENT REF.	Bushehr MEG Plant Project
		AIRPACK REF.	17811-30A

DRAWN BY	RTR	=
CHECKED BY	RBE	+
LAST MODIFICATION DATE		CURRENT PAGE
AIRPACK DWG NO.	17811-05	
REVISION	02	
TOTAL PAGE AMOUNT	15	

Internal targets

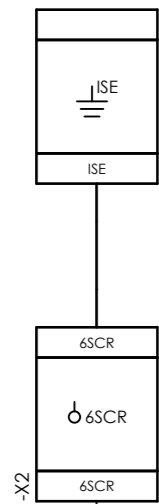


-X2



=20-C-1002+JIAX-C1002-01-FIT-10151



-FIT-10001

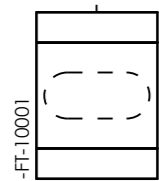

External targets




CLIENT DWG NO.	BU-20-VD-303-IN-DIG-0043
EQUIPMENT NO.	20-C-1002
EQUIPMENT LOCATION	Iran, Onshore
THIS DRAWING IS OWNED BY AIRPACK, AND SHALL NOT BE PRINTED OR COPIED IN ANY OTHER WAY THAN WITH AIRPACKS PERMISSION!	

SUBJECT Cable-connection diagram =20-C-1002+JIAX-C1002-01-FIT-10151	
ADAPTED TO P&ID REVISION	06
CLIENT	Bushehr Petrochemical Company (BUPC)
CLIENT REF.	Bushehr MEG Plant Project
AIRPACK REF.	17811-30A

DRAWN BY	RTR	=
CHECKED BY	RBE	+
LAST MODIFICATION DATE		CURRENT PAGE
AIRPACK DWG NO.	17811-05	
REVISION	02	
TOTAL PAGE AMOUNT	16	


Internal targets

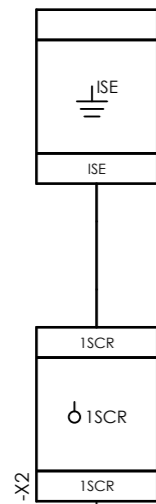


-X2



=20-C-1002+JIAX-C1002-01-PIT-10153

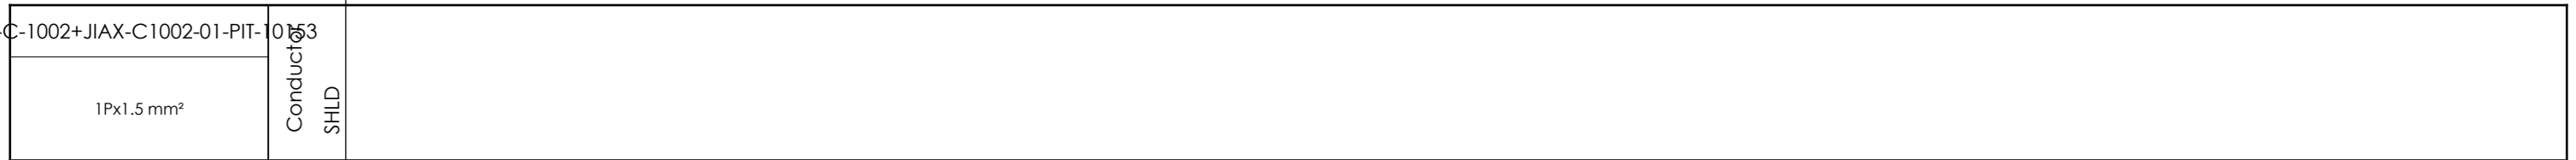

-PIT-10003

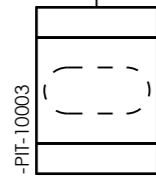

External targets





CLIENT DWG NO.	BU-20-VD-303-IN-DIG-0043
EQUIPMENT NO.	20-C-1002
EQUIPMENT LOCATION	Iran, Onshore

THIS DRAWING IS OWNED BY AIRPACK, AND SHALL NOT BE PRINTED OR COPIED IN ANY OTHER WAY THAN WITH AIRPACKS PERMISSION!



SUBJECT		Cable-connection diagram =20-C-1002+JIAX-C1002-01-PIT-10153	
ADAPTED TO P&ID REVISION	06	CLIENT	Bushehr Petrochemical Company (BUPC)
CLIENT REF.	Bushehr MEG Plant Project	AIRPACK REF.	17811-30A

DRAWN BY	RTR	=
CHECKED BY	RBE	+
LAST MODIFICATION DATE		CURRENT PAGE
AIRPACK DWG NO.	17811-05	
REVISION	02	
TOTAL PAGE AMOUNT	17	

 Internal targets

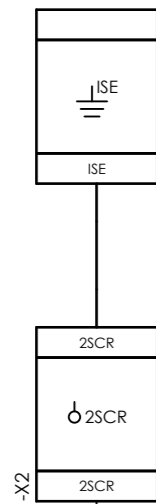

=20-C-1002+JIAX-C1002-01-PIT-10154

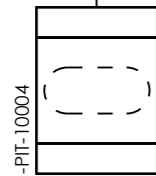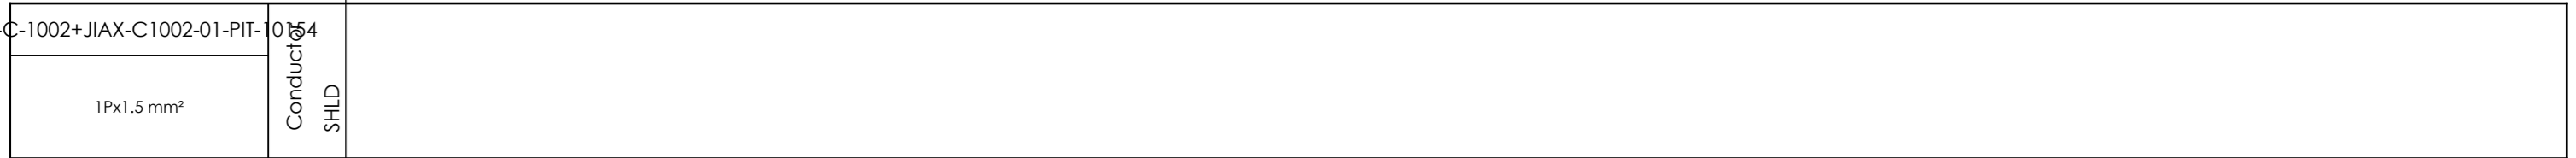

External targets




CLIENT DWG NO.	BU-20-VD-303-IN-DIG-0043
EQUIPMENT NO.	20-C-1002
EQUIPMENT LOCATION	Iran, Onshore
THIS DRAWING IS OWNED BY AIRPACK, AND SHALL NOT BE PRINTED OR COPIED IN ANY OTHER WAY THAN WITH AIRPACKS PERMISSION!	



SUBJECT Cable-connection diagram =20-C-1002+JIAX-C1002-01-PIT-10154	
ADAPTED TO P&ID REVISION	06
CLIENT	Bushehr Petrochemical Company (BUPC)
CLIENT REF.	Bushehr MEG Plant Project
AIRPACK REF.	17811-30A

DRAWN BY	RTR	=
CHECKED BY	RBE	+
LAST MODIFICATION DATE		CURRENT PAGE
AIRPACK DWG NO.	17811-05	
REVISION	02	
TOTAL PAGE AMOUNT	18	

Internal targets

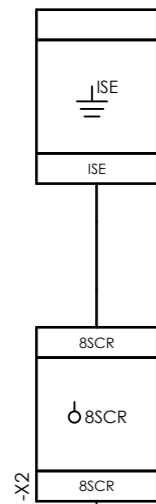

-X2

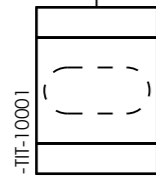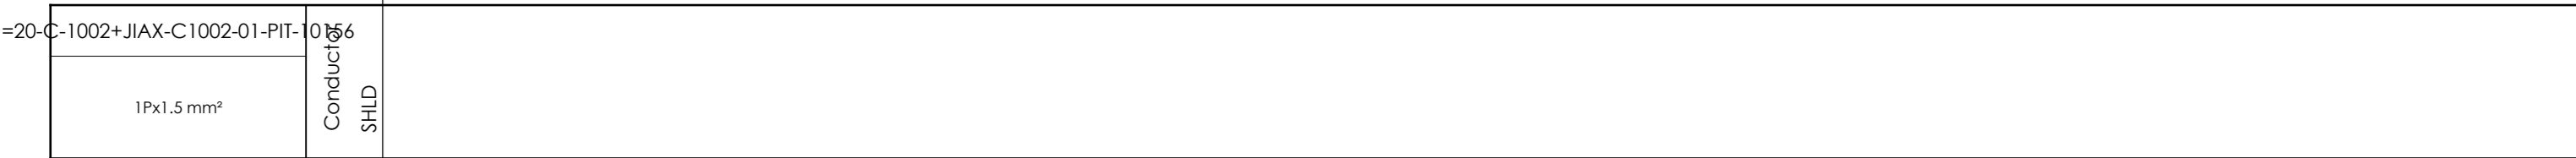

External targets




CLIENT DWG NO.	BU-20-VD-303-IN-DIG-0043
EQUIPMENT NO.	20-C-1002
EQUIPMENT LOCATION	Iran, Onshore

THIS DRAWING IS OWNED BY AIRPACK, AND SHALL NOT BE PRINTED OR COPIED IN ANY OTHER WAY THAN WITH AIRPACKS PERMISSION!


SUBJECT		Cable-connection diagram =20-C-1002+JIAX-C1002-01-PIT-10156	
ADAPTED TO P&ID REVISION	06	CLIENT	Bushehr Petrochemical Company (BUPC)
CLIENT REF.	Bushehr MEG Plant Project	AIRPACK REF.	17811-30A

DRAWN BY	RTR	=
CHECKED BY	RBE	+
LAST MODIFICATION DATE		CURRENT PAGE
AIRPACK DWG NO.	17811-05	
REVISION	02	
TOTAL PAGE AMOUNT	19	

Internal targets

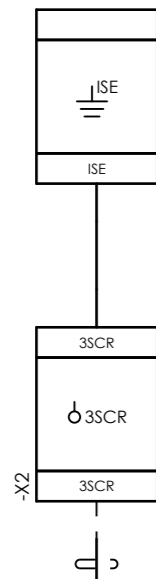

External targets

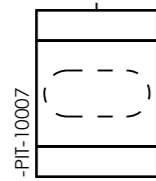



CLIENT DWG NO.	BU-20-VD-303-IN-DIG-0043
EQUIPMENT NO.	20-C-1002
EQUIPMENT LOCATION	Iran, Onshore

THIS DRAWING IS OWNED BY AIRPACK, AND SHALL NOT BE PRINTED OR COPIED IN ANY OTHER WAY THAN WITH AIRPACKS PERMISSION!



SUBJECT		Cable-connection diagram =20-C-1002+JIAX-C1002-01-PIT-10157	
ADAPTED TO P&ID REVISION	06	CLIENT	Bushehr Petrochemical Company (BUPC)
CLIENT REF.	Bushehr MEG Plant Project	AIRPACK REF.	17811-30A

DRAWN BY	RTR	=
CHECKED BY	RBE	+
LAST MODIFICATION DATE		CURRENT PAGE
AIRPACK DWG NO.	17811-05	
REVISION	02	
TOTAL PAGE AMOUNT	20	

 Internal targets

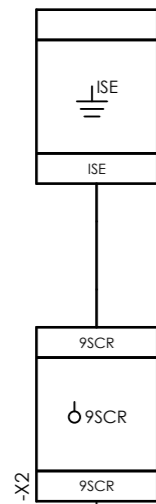

=20-C-1002+JIAX-C1002-01-PIT-10158

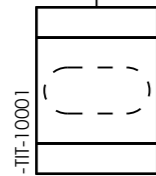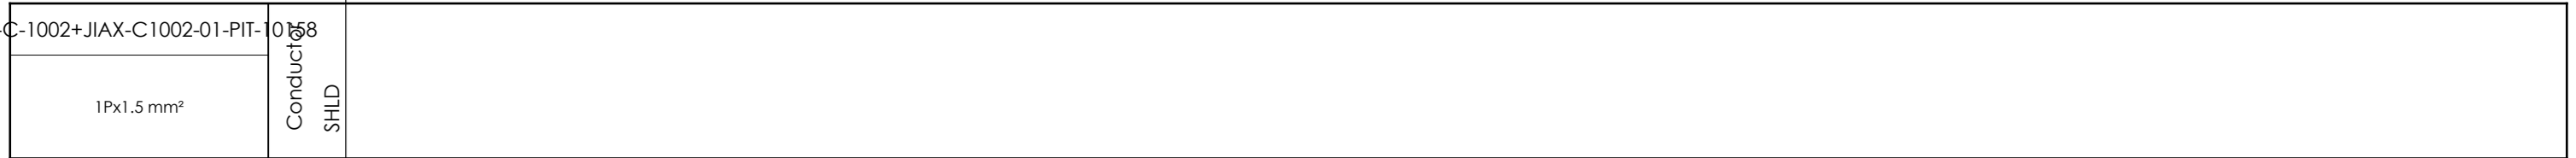

External targets




CLIENT DWG NO.	BU-20-VD-303-IN-DIG-0043
EQUIPMENT NO.	20-C-1002
EQUIPMENT LOCATION	Iran, Onshore
THIS DRAWING IS OWNED BY AIRPACK, AND SHALL NOT BE PRINTED OR COPIED IN ANY OTHER WAY THAN WITH AIRPACKS PERMISSION!	

SUBJECT		Cable-connection diagram =20-C-1002+JIAX-C1002-01-PIT-10158	
ADAPTED TO P&ID REVISION	06	CLIENT	Bushehr Petrochemical Company (BUPC)
CLIENT REF.	Bushehr MEG Plant Project	AIRPACK REF.	17811-30A

DRAWN BY	RTR	=
CHECKED BY	RBE	+
LAST MODIFICATION DATE		CURRENT PAGE
AIRPACK DWG NO.	17811-05	
REVISION	02	
TOTAL PAGE AMOUNT	21	


Internal targets

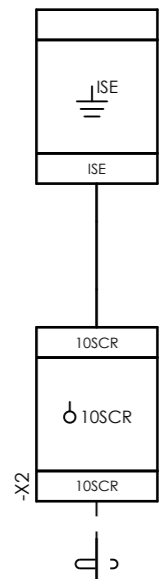

=20-C-1002+JIAX-C1002-01-PIT-10159



External targets

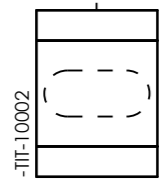


CLIENT DWG NO.	BU-20-VD-303-IN-DIG-0043
EQUIPMENT NO.	20-C-1002
EQUIPMENT LOCATION	Iran, Onshore
THIS DRAWING IS OWNED BY AIRPACK, AND SHALL NOT BE PRINTED OR COPIED IN ANY OTHER WAY THAN WITH AIRPACKS PERMISSION!	


SUBJECT		Cable-connection diagram =20-C-1002+JIAX-C1002-01-PIT-10159	
ADAPTED TO P&ID REVISION	06	CLIENT	Bushehr Petrochemical Company (BUPC)
CLIENT REF.	Bushehr MEG Plant Project	AIRPACK REF.	17811-30A

DRAWN BY	RTR	=
CHECKED BY	RBE	+
LAST MODIFICATION DATE		CURRENT PAGE
AIRPACK DWG NO.	17811-05	
REVISION	02	
TOTAL PAGE AMOUNT	22	

Internal targets

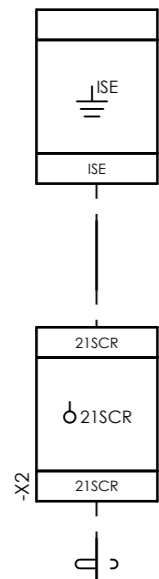

=20-C-1002+JIAX-C1002-01-PV-10151

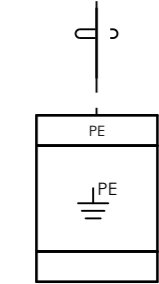

External targets





CLIENT DWG NO.	BU-20-VD-303-IN-DIG-0043
EQUIPMENT NO.	20-C-1002
EQUIPMENT LOCATION	Iran, Onshore
THIS DRAWING IS OWNED BY AIRPACK, AND SHALL NOT BE PRINTED OR COPIED IN ANY OTHER WAY THAN WITH AIRPACKS PERMISSION!	

SUBJECT		Cable-connection diagram =20-C-1002+JIAX-C1002-01-PV-10151
ADAPTED TO P&ID REVISION	06	
CLIENT	Bushehr Petrochemical Company (BUPC)	
CLIENT REF.	Bushehr MEG Plant Project	
AIRPACK REF.	17811-30A	




DRAWN BY	RTR	=
CHECKED BY	RBE	+
LAST MODIFICATION DATE		
AIRPACK DWG NO.	17811-05	
REVISION	02	
TOTAL PAGE AMOUNT	23	

CURRENT PAGE	
--------------	--

 Internal targets

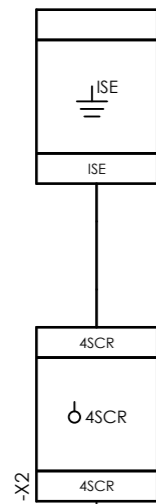

=20-C-1002+JIAX-C1002-01-TIT-10151

 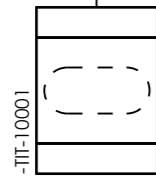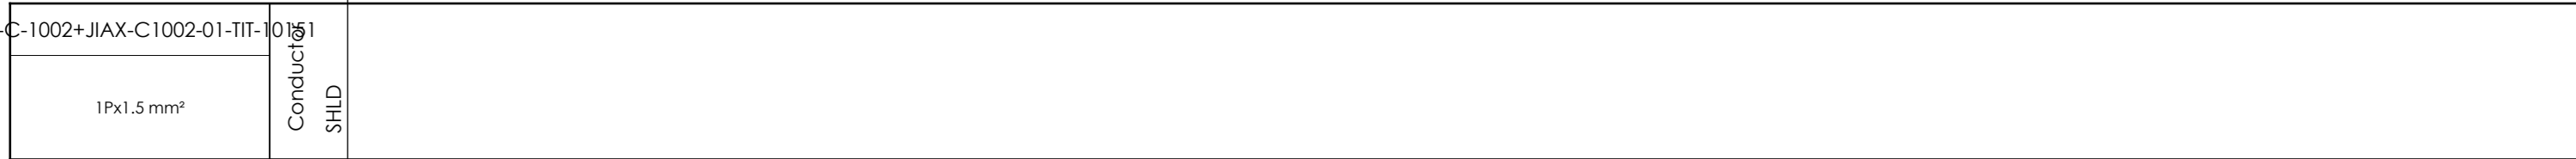

External targets



CLIENT DWG NO.	BU-20-VD-303-IN-DIG-0043
EQUIPMENT NO.	20-C-1002
EQUIPMENT LOCATION	Iran, Onshore

SUBJECT	
Cable-connection diagram =20-C-1002+JIAX-C1002-01-TIT-10151	
ADAPTED TO P&ID REVISION	06

DRAWN BY	RTR	=
CHECKED BY	RBE	+
LAST MODIFICATION DATE		


THIS DRAWING IS OWNED BY AIRPACK, AND SHALL NOT BE PRINTED OR COPIED IN ANY OTHER WAY THAN WITH AIRPACKS PERMISSION!

CLIENT	Bushehr Petrochemical Company (BUPC)
CLIENT REF.	Bushehr MEG Plant Project
AIRPACK REF.	17811-30A

AIRPACK DWG NO.	17811-05
REVISION	02
TOTAL PAGE AMOUNT	24


CURRENT PAGE

Internal targets

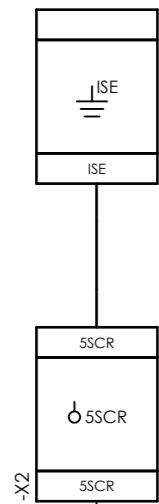


-X2

=20-C-1002+JIAX-C1002-01-TIT-10152

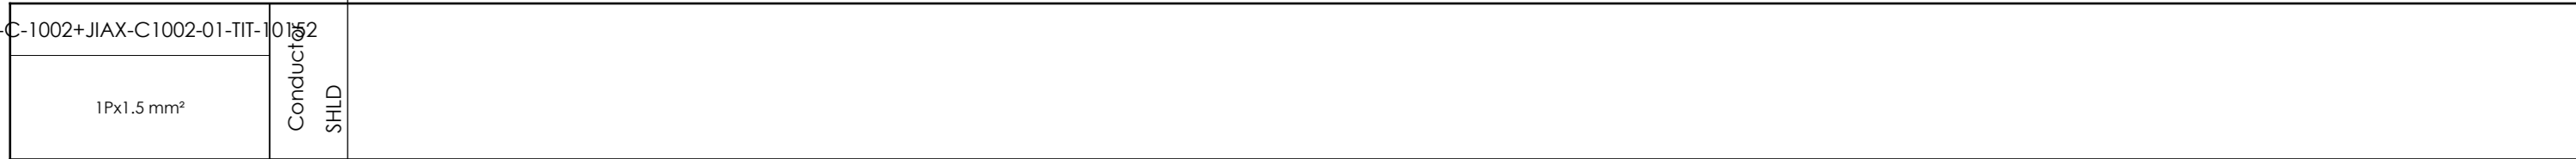

-X2

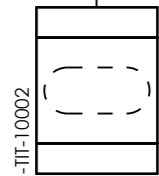

External targets




CLIENT DWG NO.	BU-20-VD-303-IN-DIG-0043
EQUIPMENT NO.	20-C-1002
EQUIPMENT LOCATION	Iran, Onshore
THIS DRAWING IS OWNED BY AIRPACK, AND SHALL NOT BE PRINTED OR COPIED IN ANY OTHER WAY THAN WITH AIRPACKS PERMISSION!	

SUBJECT	
Cable-connection diagram =20-C-1002+JIAX-C1002-01-TIT-10152	
ADAPTED TO P&ID REVISION	06
CLIENT	Bushehr Petrochemical Company (BUPC)
CLIENT REF.	Bushehr MEG Plant Project
AIRPACK REF.	17811-30A

DRAWN BY	RTR	=
CHECKED BY	RBE	+
LAST MODIFICATION DATE		CURRENT PAGE
AIRPACK DWG NO.	17811-05	
REVISION	02	
TOTAL PAGE AMOUNT	25	


Internal targets

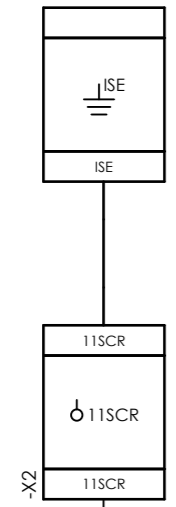

-X2





External targets



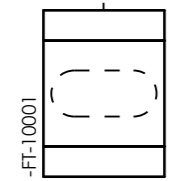


CLIENT DWG NO.	BU-20-VD-303-IN-DIG-0043	SUBJECT		DRAWN BY	RTR	=
EQUIPMENT NO.	20-C-1002	Cable-connection diagram =20-C-1002+JIAX-C1002-01-TIT-10153		CHECKED BY	RBE	+
EQUIPMENT LOCATION	Iran, Onshore	ADAPTED TO P&ID REVISION	06	LAST MODIFICATION DATE		CURRENT PAGE
THIS DRAWING IS OWNED BY AIRPACK, AND SHALL NOT BE PRINTED OR COPIED IN ANY OTHER WAY THAN WITH AIRPACKS PERMISSION!		CLIENT	Bushehr Petrochemical Company (BUPC)	AIRPACK DWG NO.	17811-05	
		CLIENT REF.	Bushehr MEG Plant Project	REVISION	02	
		AIRPACK REF.	17811-30A	TOTAL PAGE AMOUNT	26	

 Internal targets

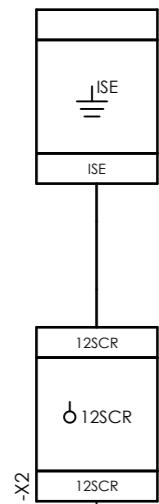

=20-C-1002+JIAX-C1002-01-TIT-10154

 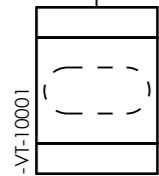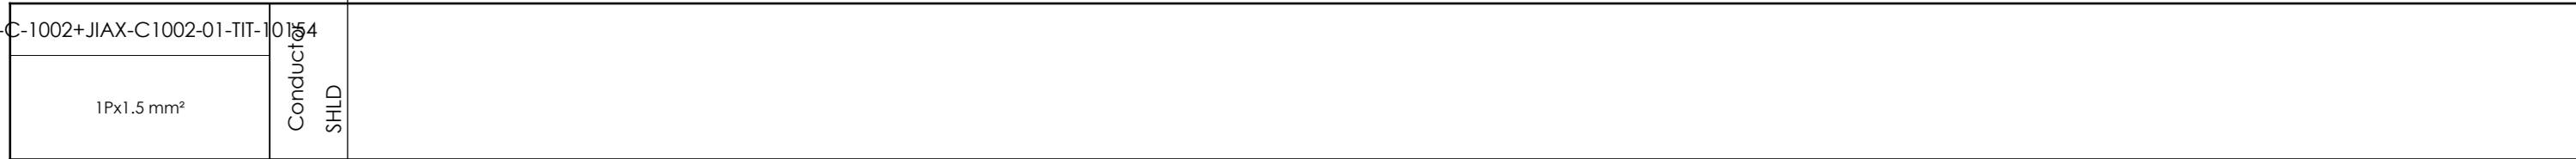

External targets



CLIENT DWG NO.	BU-20-VD-303-IN-DIG-0043
EQUIPMENT NO.	20-C-1002
EQUIPMENT LOCATION	Iran, Onshore

SUBJECT	
Cable-connection diagram =20-C-1002+JIAX-C1002-01-TIT-10154	
ADAPTED TO P&ID REVISION	06



DRAWN BY	RTR	=
CHECKED BY	RBE	+
LAST MODIFICATION DATE		CURRENT PAGE

THIS DRAWING IS OWNED BY AIRPACK, AND SHALL NOT BE PRINTED OR COPIED IN ANY OTHER WAY THAN WITH AIRPACKS PERMISSION!



CLIENT	Bushehr Petrochemical Company (BUPC)
CLIENT REF.	Bushehr MEG Plant Project
AIRPACK REF.	17811-30A

AIRPACK DWG NO.	17811-05
REVISION	02
TOTAL PAGE AMOUNT	27

 Internal targets

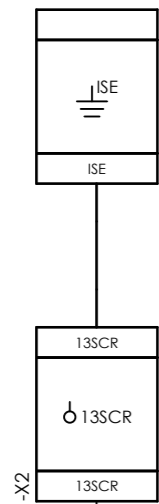

=20-C-1002+JIAX-C1002-01-TIT-10155

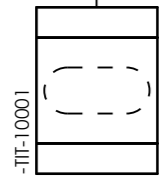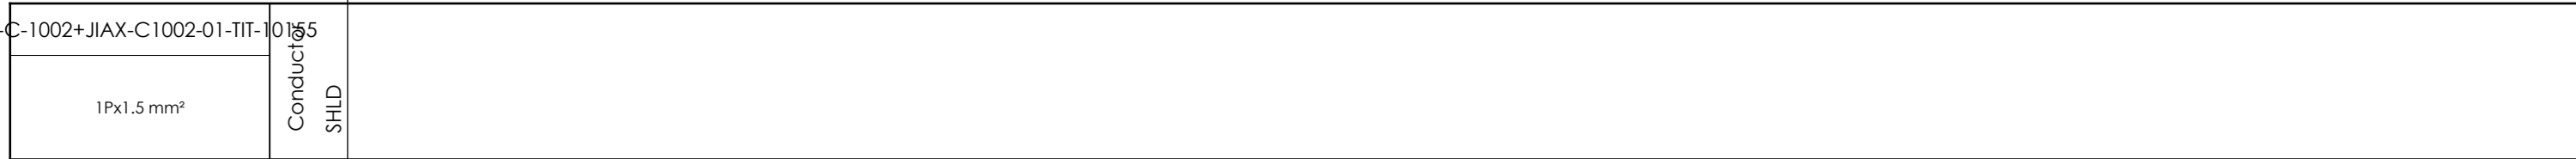

External targets




CLIENT DWG NO.	BU-20-VD-303-IN-DIG-0043
EQUIPMENT NO.	20-C-1002
EQUIPMENT LOCATION	Iran, Onshore
THIS DRAWING IS OWNED BY AIRPACK, AND SHALL NOT BE PRINTED OR COPIED IN ANY OTHER WAY THAN WITH AIRPACKS PERMISSION!	

SUBJECT Cable-connection diagram =20-C-1002+JIAX-C1002-01-TIT-10155	
ADAPTED TO P&ID REVISION	06
CLIENT	Bushehr Petrochemical Company (BUPC)
CLIENT REF.	Bushehr MEG Plant Project
AIRPACK REF.	17811-30A


DRAWN BY	RTR	=
CHECKED BY	RBE	+
LAST MODIFICATION DATE		CURRENT PAGE
AIRPACK DWG NO.	17811-05	
REVISION	02	
TOTAL PAGE AMOUNT	28	

Internal targets

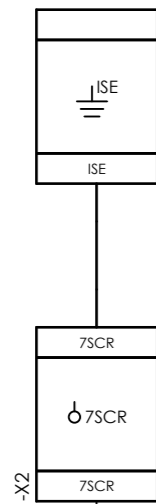


-X2

=20-C-1002+JIAX-C1002-01-VT-10151

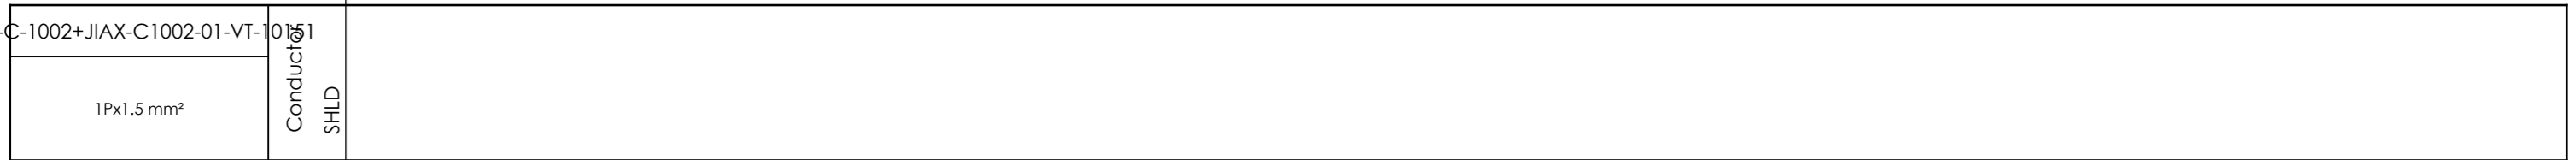

-X2

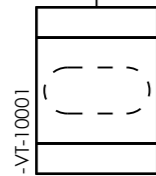

External targets




CLIENT DWG NO.	BU-20-VD-303-IN-DIG-0043
EQUIPMENT NO.	20-C-1002
EQUIPMENT LOCATION	Iran, Onshore
THIS DRAWING IS OWNED BY AIRPACK, AND SHALL NOT BE PRINTED OR COPIED IN ANY OTHER WAY THAN WITH AIRPACKS PERMISSION!	

SUBJECT Cable-connection diagram =20-C-1002+JIAX-C1002-01-VT-10151	
ADAPTED TO P&ID REVISION	06
CLIENT	Bushehr Petrochemical Company (BUPC)
CLIENT REF.	Bushehr MEG Plant Project
AIRPACK REF.	17811-30A

DRAWN BY	RTR	=
CHECKED BY	RBE	+
LAST MODIFICATION DATE		CURRENT PAGE
AIRPACK DWG NO.	17811-05	
REVISION	02	
TOTAL PAGE AMOUNT	29	


Internal targets

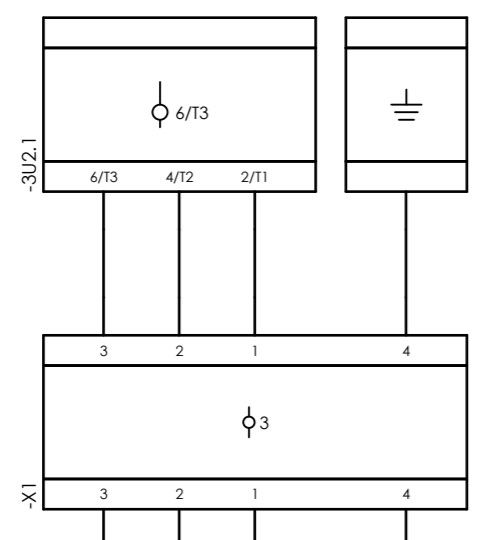

=20-C-1002+PD-C-1002-01-20-C-1002-M




External targets

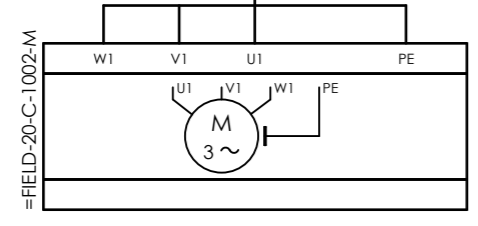


CLIENT DWG NO.	BU-20-VD-303-IN-DIG-0043
EQUIPMENT NO.	20-C-1002
EQUIPMENT LOCATION	Iran, Onshore
THIS DRAWING IS OWNED BY AIRPACK, AND SHALL NOT BE PRINTED OR COPIED IN ANY OTHER WAY THAN WITH AIRPACKS PERMISSION!	

SUBJECT		DRAWN BY		RTR		=	
Cable-connection diagram =20-C-1002+PD-C-1002-01-20-C-1002-M		CHECKED BY		RBE		+	
ADAPTED TO P&ID REVISION	06	LAST MODIFICATION DATE				CURRENT PAGE	
CLIENT	Bushehr Petrochemical Company (BUPC)	AIRPACK DWG NO.		17811-05			
CLIENT REF.	Bushehr MEG Plant Project	REVISION		02			
AIRPACK REF.	17811-30A	TOTAL PAGE AMOUNT		30			

Internal targets

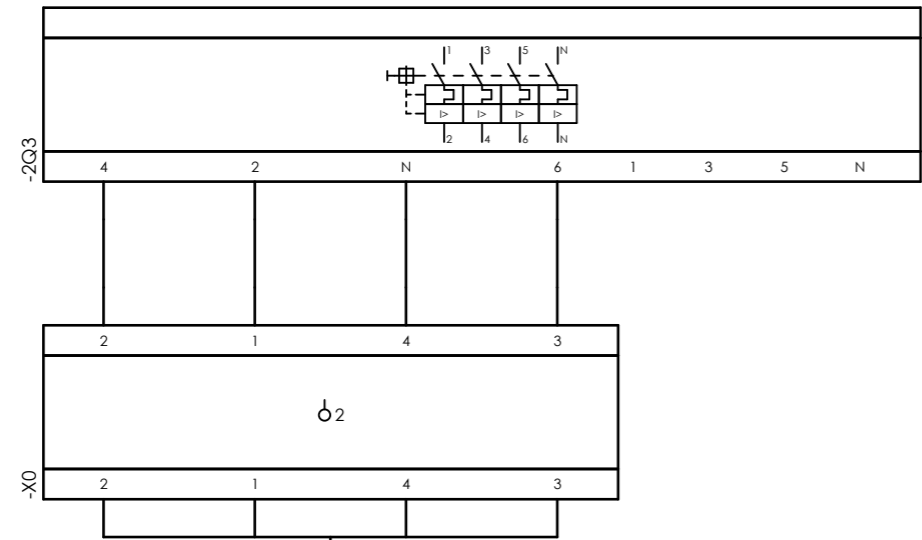

External targets

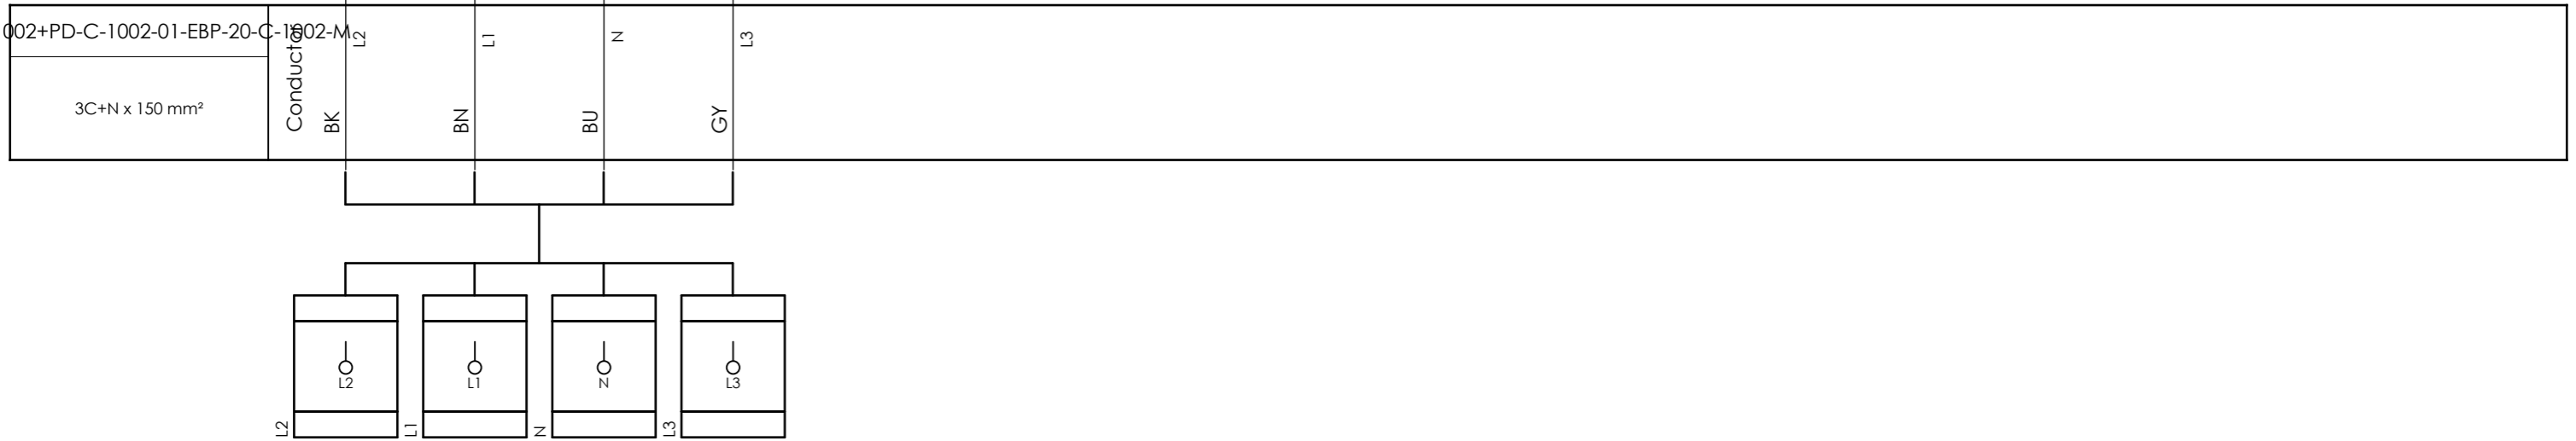


CLIENT DWG NO.	BU-20-VD-303-IN-DIG-0043
EQUIPMENT NO.	20-C-1002
EQUIPMENT LOCATION	Iran, Onshore
THIS DRAWING IS OWNED BY AIRPACK, AND SHALL NOT BE PRINTED OR COPIED IN ANY OTHER WAY THAN WITH AIRPACKS PERMISSION!	


SUBJECT		Cable-connection diagram =20-C-1002+PD-C-1002-01-EBP-20-C-1002-M	
ADAPTED TO P&ID REVISION	06	CLIENT	Bushehr Petrochemical Company (BUPC)
CLIENT REF.	Bushehr MEG Plant Project	AIRPACK REF.	17811-30A

DRAWN BY	RTR	=
CHECKED BY	RBE	+
LAST MODIFICATION DATE		CURRENT PAGE
AIRPACK DWG NO.	17811-05	
REVISION	02	
TOTAL PAGE AMOUNT	31	


Internal targets

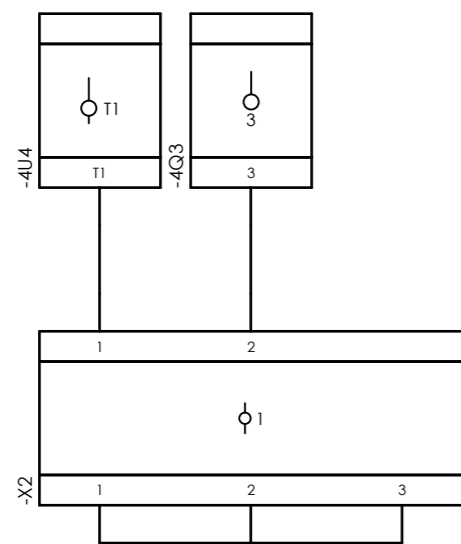

=20-C-1002+PD-C-1002-01-LG-10151

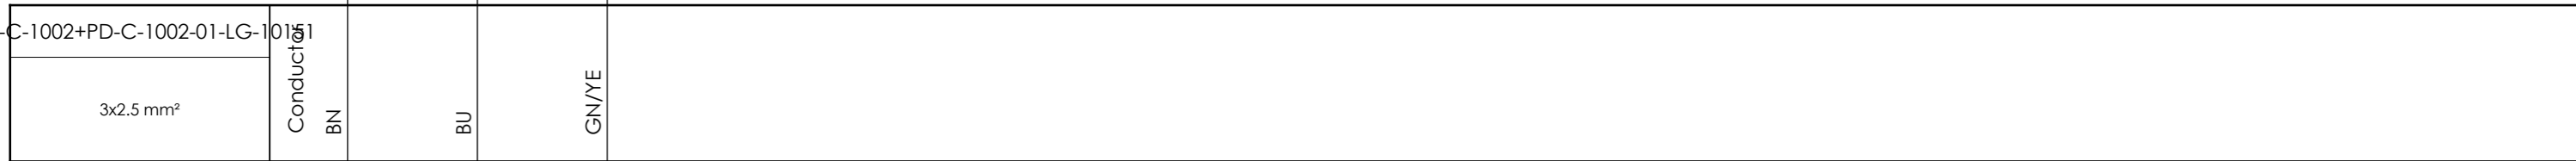

External targets

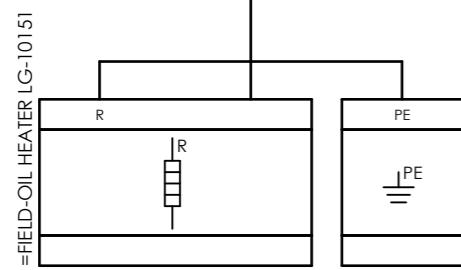

CLIENT DWG NO.	BU-20-VD-303-IN-DIG-0043
EQUIPMENT NO.	20-C-1002
EQUIPMENT LOCATION	Iran, Onshore
THIS DRAWING IS OWNED BY AIRPACK, AND SHALL NOT BE PRINTED OR COPIED IN ANY OTHER WAY THAN WITH AIRPACKS PERMISSION!	

SUBJECT		Cable-connection diagram =20-C-1002+PD-C-1002-01-LG-10151	
ADAPTED TO P&ID REVISION	06	CLIENT	Bushehr Petrochemical Company (BUPC)
CLIENT REF.	Bushehr MEG Plant Project	AIRPACK REF.	17811-30A

DRAWN BY	RTR	=
CHECKED BY	RBE	+
LAST MODIFICATION DATE		CURRENT PAGE
AIRPACK DWG NO.	17811-05	
REVISION	02	
TOTAL PAGE AMOUNT	32	

