





OWNER:  شرکت سست و نوبی توسعه ایرانلیان (سهامی منتهی الیه)	BUSHEHR PETROCHEMICAL COMPANY MEG PLANT						EPC CONTRACTOR:  Chagalesh-Enerchimi-Steam Joint Venture BUPC-MEG PLANT PROJECT		
	LOOP DIAGRAM FOR NITROGEN GAS BOOSTER								
MC :  شرکت سست و نوبی توسعه ایرانلیان (سهامی منتهی الیه)							Project	Area	Phase
Owner Document Number: 17811-30A	BU	20	VD	303	IN	DIG	0036	Rev.:	Page
								01	1 of 35

LOOP DIAGRAM FOR NITROGEN GAS BOOSTER

01	15/07/2022	For approval	MG	RB	KP	
00	18/10/2021	For approval	HT	KP	JR	
Rev.	Date	Purpose of Issue	Prepared	Checked	Approved	AC Code
					Class: 1	Phase: P



Airpack B.V.

4301 RN Zierikzee
The Netherlands

PHONE: (31) (0) 111 - 415455

FAX: (31) (0) 111 - 413338

E-MAIL : AIRPACK@AIRPACK.NL

WEBPAGE : WWW.AIRPACK.NL

Client : Bushehr Petrochemical Company (BUPC)

Equipment location : Iran, Onshore

Client reference : Bushehr MEG Plant Project

Client dwg. no. : BU-20-VD-303-IN-DIG-0043

Airpack reference : 17811-30A

Airpack dwg. no. : 17811-05

Generation date : 6-11-2020

E & I manager : RBE

Last modifications : 14-7-2022


Last modifications by : MaGo

Revision no. : 01




CLIENT DWG NO.	BU-20-VD-303-IN-DIG-0043	SUBJECT	DRAWN BY	MaGo	=
EQUIPMENT NO.	20-C-1002	Title page / cover sheet	CHECKED BY	RBE	+
EQUIPMENT LOCATION	Iran, Onshore	ADAPTED TO P&ID REVISION	LAST MODIFICATION DATE		CURRENT PAGE
THIS DRAWING IS OWNED BY AIRPACK, AND SHALL NOT BE PRINTED OR COPIED IN ANY OTHER WAY THAN WITH AIRPACKS PERMISSION!		05	AIRPACK DWG NO.	17811-05	
	CLIENT	Bushehr Petrochemical Company (BUPC)	REVISION	01	
	CLIENT REF.	Bushehr MEG Plant Project	TOTAL PAGE AMOUNT	1	
	AIRPACK REF.	17811-30A			


Internal targets

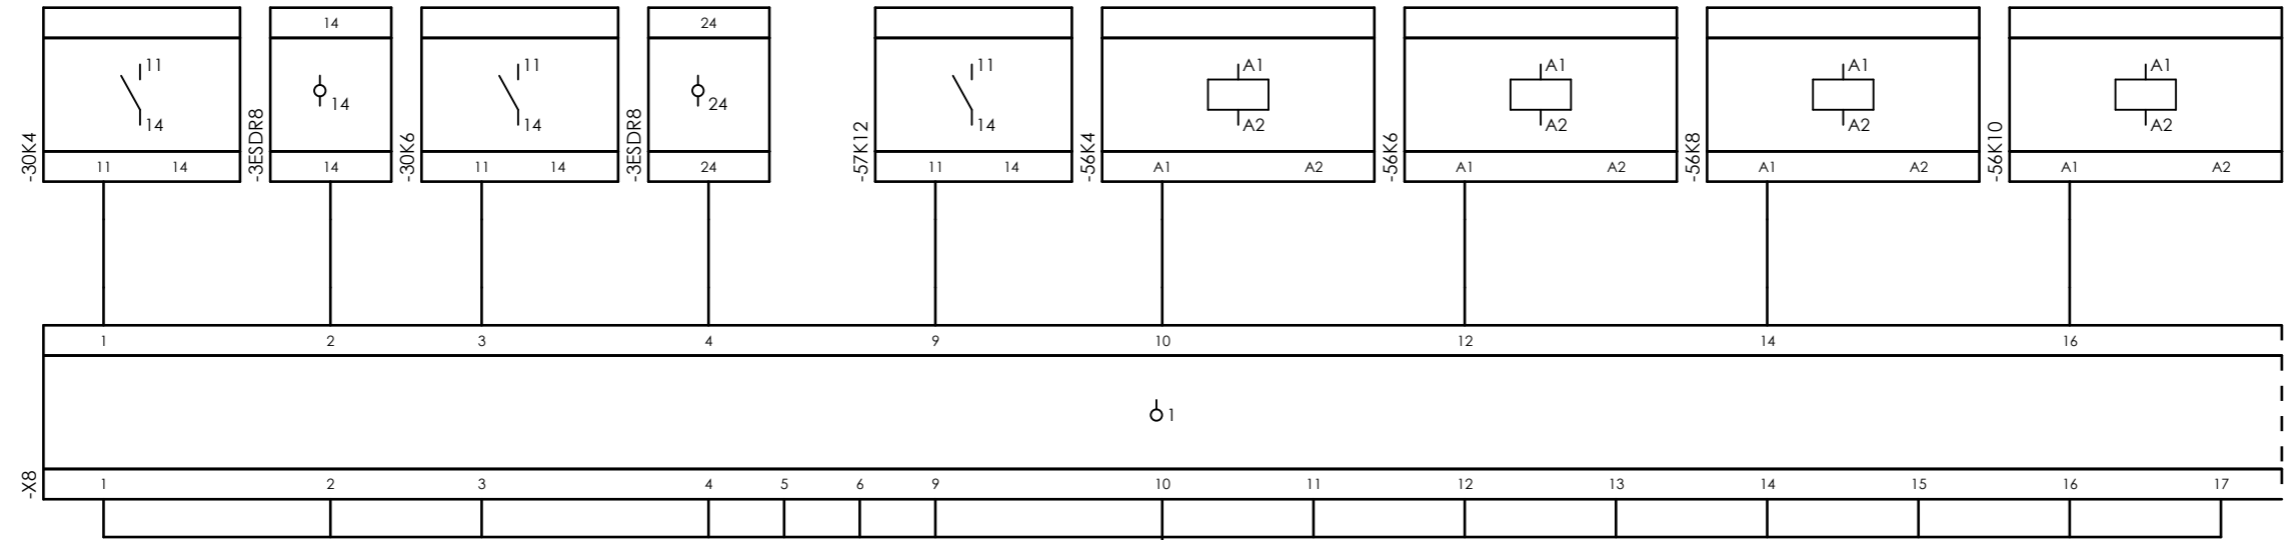

=20-C-1002+UCP-C1002-01-DB_COMA

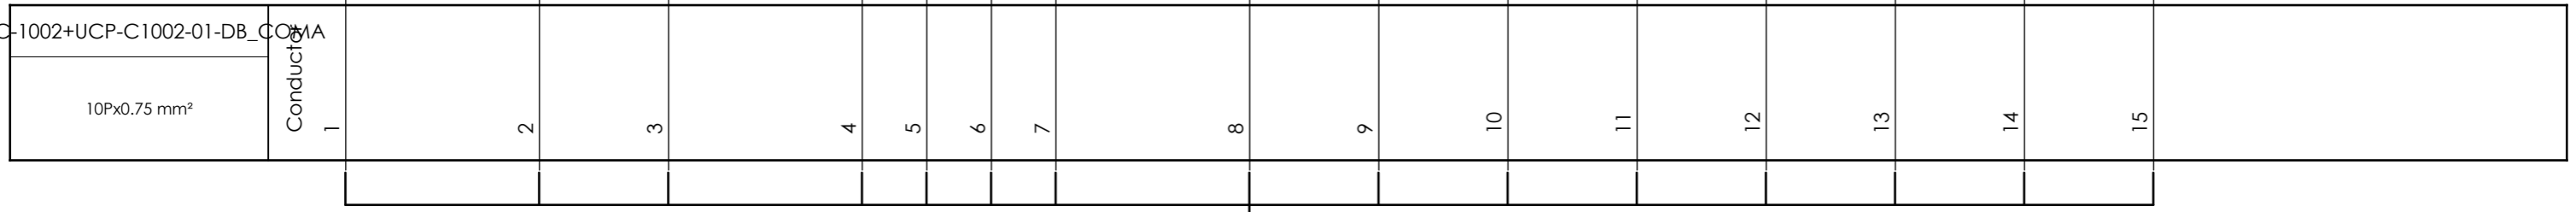

External targets

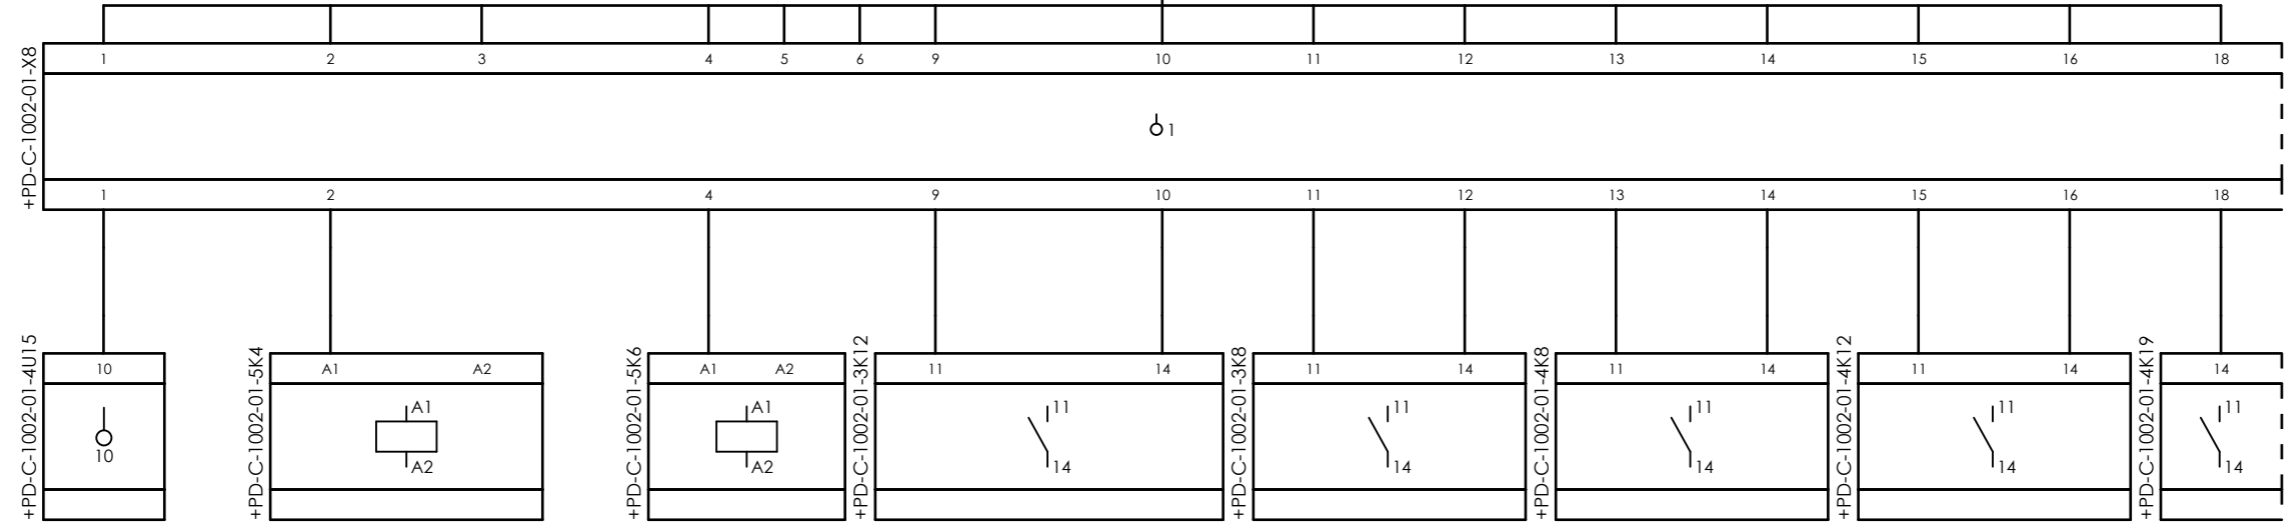


CLIENT DWG NO. BU-20-VD-303-IN-DIG-0043
 EQUIPMENT NO. 20-C-1002
 EQUIPMENT LOCATION Iran, Onshore
 THIS DRAWING IS OWNED BY AIRPACK, AND SHALL NOT BE PRINTED OR COPIED IN ANY OTHER WAY THAN WITH AIRPACKS PERMISSION!

SUBJECT Cable-connection diagram =20-C-1002+UCP-C1002-01-DB_COMA
 ADAPTED TO P&ID REVISION 05
 CLIENT Bushehr Petrochemical Company (BUPC)
 CLIENT REF. Bushehr MEG Plant Project
 AIRPACK REF. 17811-30A

DRAWN BY MaGo
 CHECKED BY RBE
 LAST MODIFICATION DATE
 AIRPACK DWG NO. 17811-05
 REVISION 01
 TOTAL PAGE AMOUNT 2

=
 +
 CURRENT PAGE
 2


Internal targets

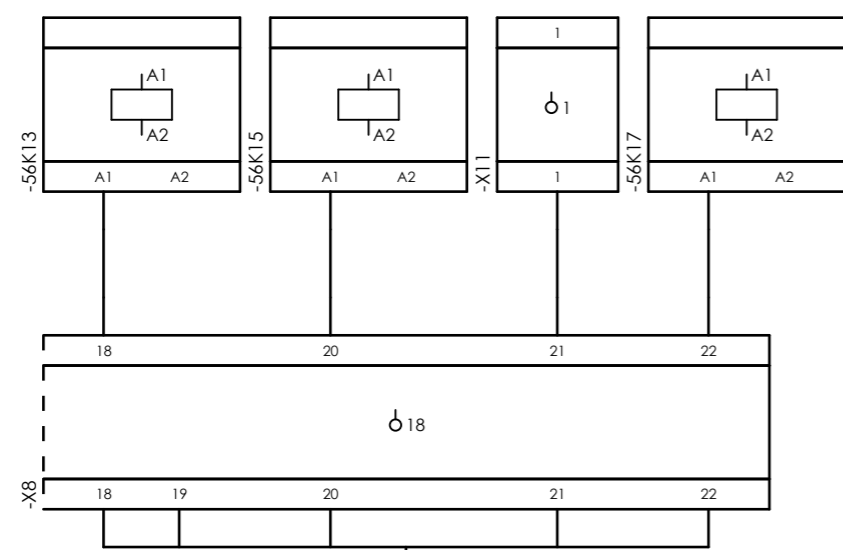

=20-C-1002+UCP-C1002-01-DB_COMA



External targets

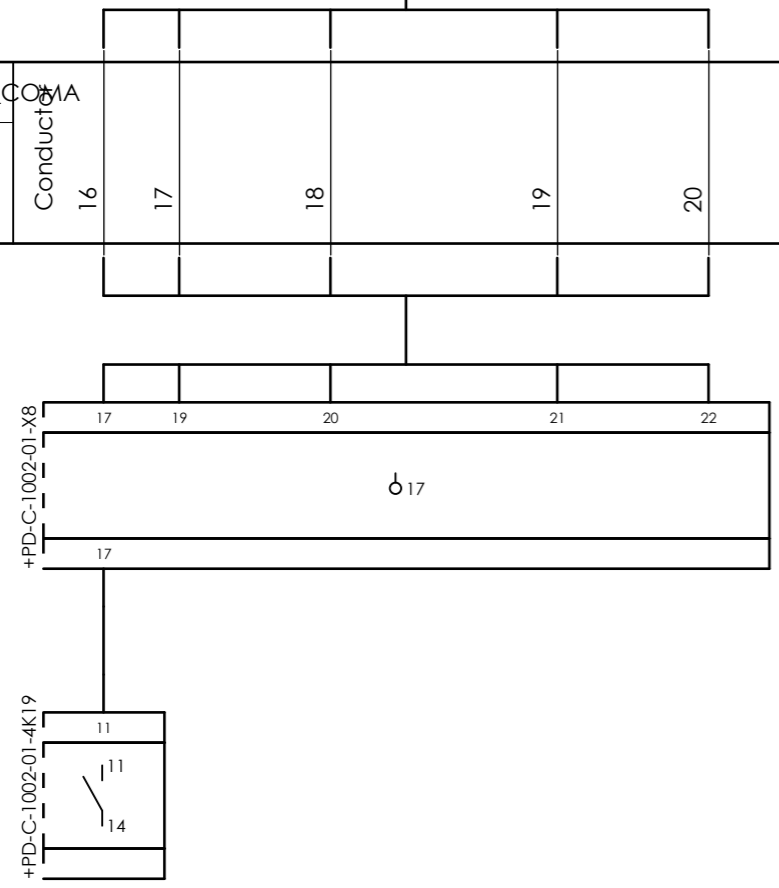


CLIENT DWG NO. BU-20-VD-303-IN-DIG-0043
 EQUIPMENT NO. 20-C-1002
 EQUIPMENT LOCATION Iran, Onshore
 THIS DRAWING IS OWNED BY AIRPACK, AND SHALL NOT BE PRINTED OR COPIED IN ANY OTHER WAY THAN WITH AIRPACKS PERMISSION!

SUBJECT Cable-connection diagram =20-C-1002+UCP-C1002-01-DB_COMA
 ADAPTED TO P&ID REVISION 05
 CLIENT Bushehr Petrochemical Company (BUPC)
 CLIENT REF. Bushehr MEG Plant Project
 AIRPACK REF. 17811-30A

DRAWN BY MaGo
 CHECKED BY RBE
 LAST MODIFICATION DATE
 AIRPACK DWG NO. 17811-05
 REVISION 01
 TOTAL PAGE AMOUNT 3


=
 +
 CURRENT PAGE
 3

Internal targets





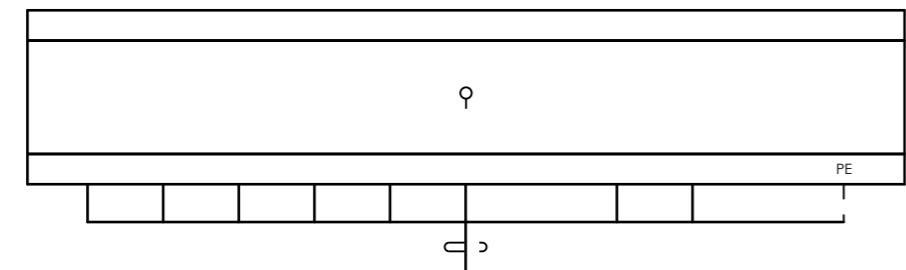


=20-C-1002+UCP-C1002-01-ESD

5Px0.75 mm² mm²

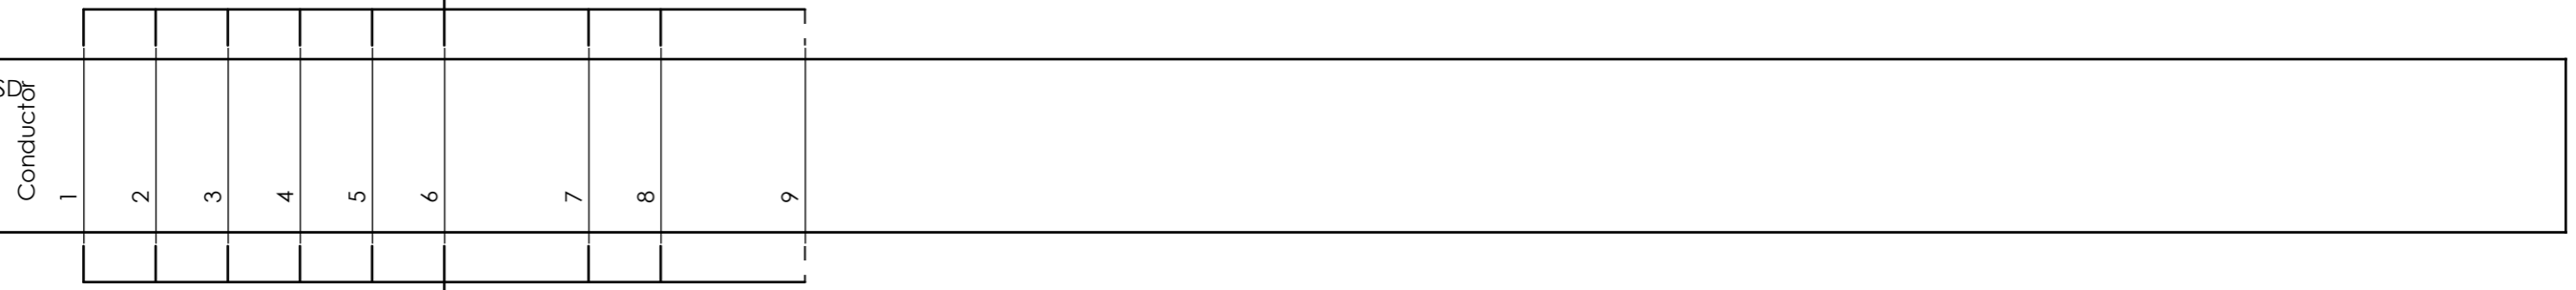

External targets

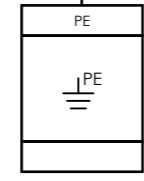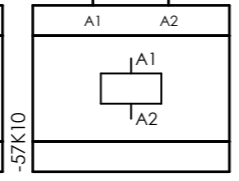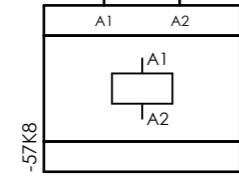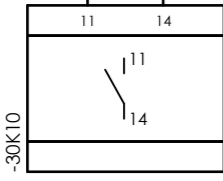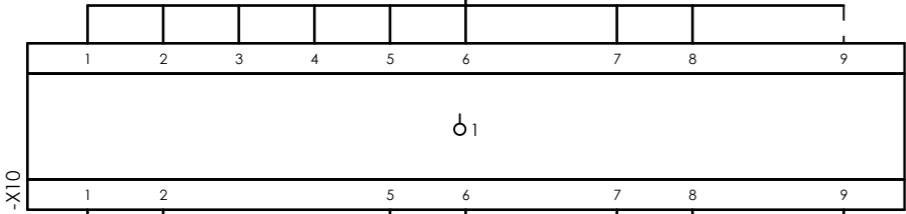


CLIENT DWG NO. BU-20-VD-303-IN-DIG-0043
 EQUIPMENT NO. 20-C-1002
 EQUIPMENT LOCATION Iran, Onshore
 THIS DRAWING IS OWNED BY AIRPACK, AND SHALL NOT BE PRINTED OR COPIED IN ANY OTHER WAY THAN WITH AIRPACKS PERMISSION!

SUBJECT Cable-connection diagram =20-C-1002+UCP-C1002-01-ESD
 ADAPTED TO P&ID REVISION 05
 CLIENT Bushehr Petrochemical Company (BUPC)
 CLIENT REF. Bushehr MEG Plant Project
 AIRPACK REF. 17811-30A


DRAWN BY MaGo
 CHECKED BY RBE
 LAST MODIFICATION DATE
 AIRPACK DWG NO. 17811-05
 REVISION 01
 TOTAL PAGE AMOUNT 4

=
 +
 CURRENT PAGE

Internal targets





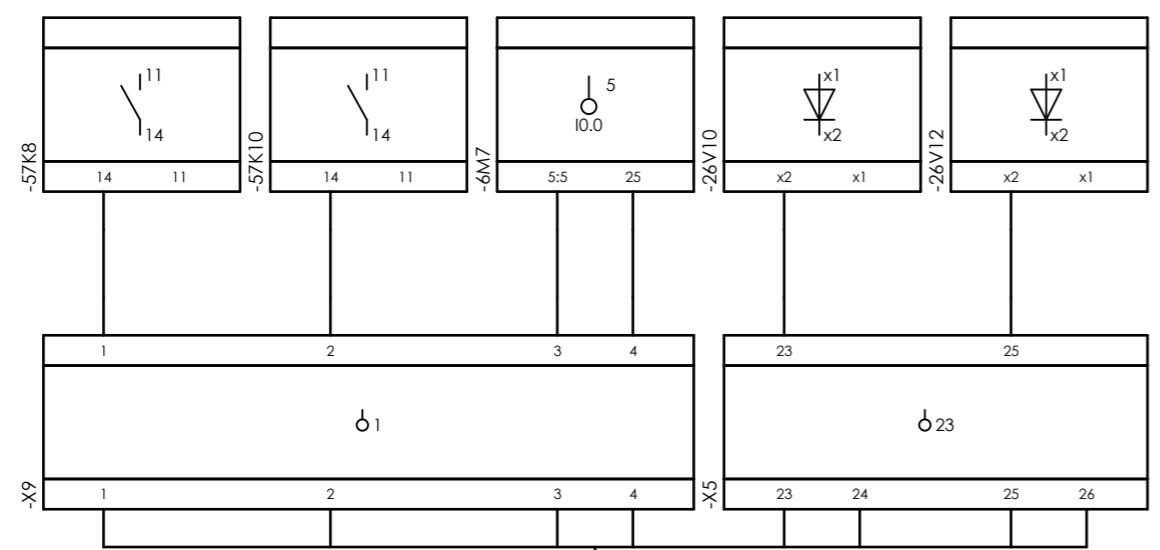


External targets

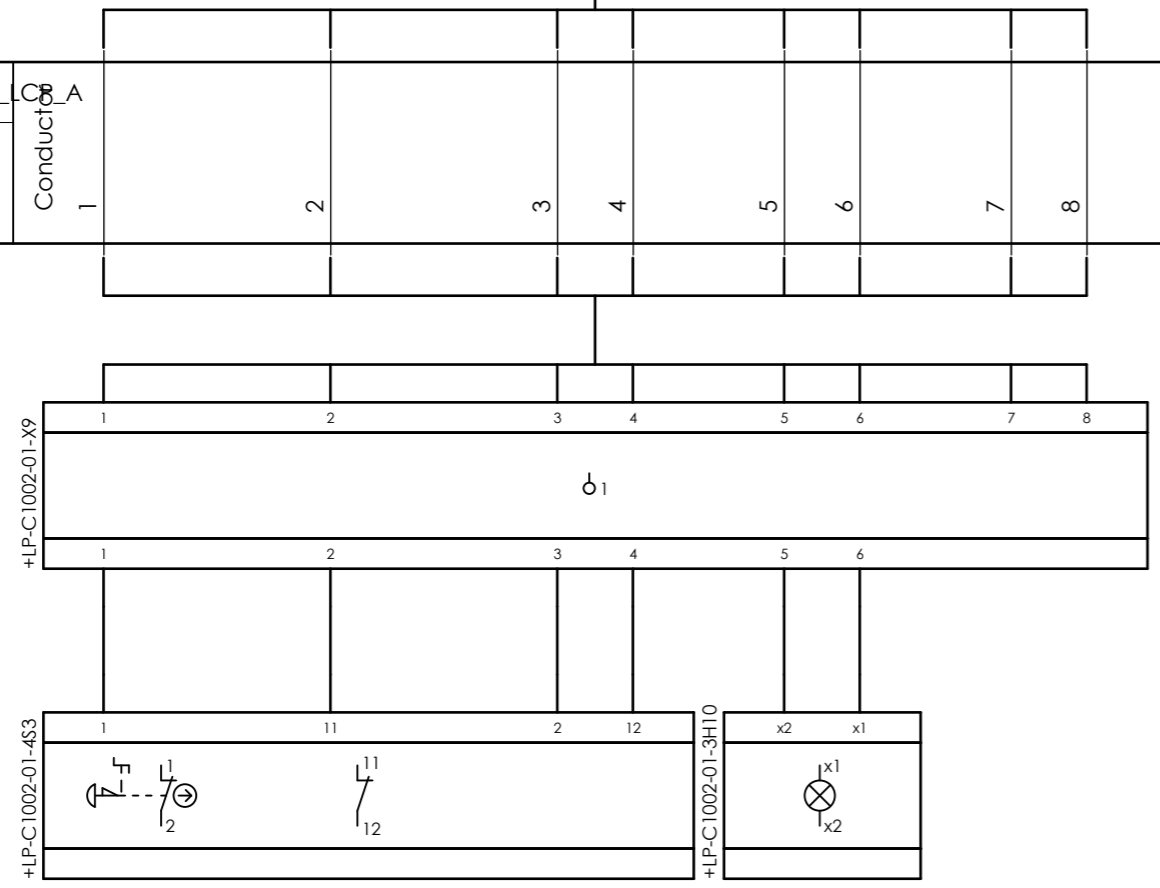

CLIENT DWG NO.	BU-20-VD-303-IN-DIG-0043	SUBJECT		DRAWN BY	MaGo	=
EQUIPMENT NO.	20-C-1002	Cable-connection diagram =20-C-1002+UCP-C1002-01-ESD_LCP_A		CHECKED BY	RBE	+
EQUIPMENT LOCATION	Iran, Onshore	ADAPTED TO P&ID REVISION	05	LAST MODIFICATION DATE		CURRENT PAGE
THIS DRAWING IS OWNED BY AIRPACK, AND SHALL NOT BE PRINTED OR COPIED IN ANY OTHER WAY THAN WITH AIRPACKS PERMISSION!		CLIENT	Bushehr Petrochemical Company (BUPC)	AIRPACK DWG NO.	17811-05	
		CLIENT REF.	Bushehr MEG Plant Project	REVISION	01	
		AIRPACK REF.	17811-30A	TOTAL PAGE AMOUNT	5	

Internal targets

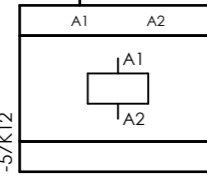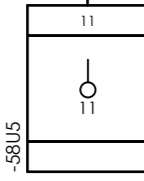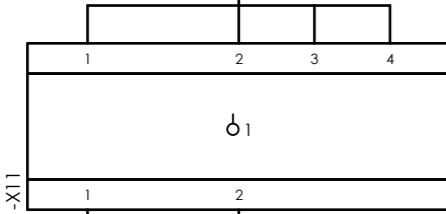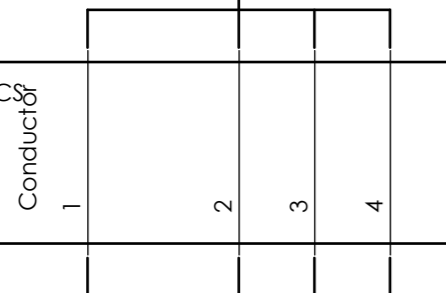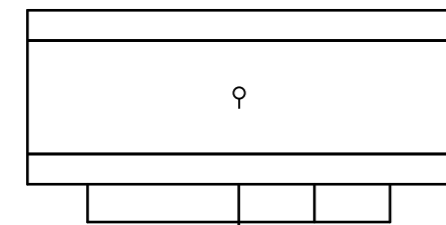

=20-C-1002+UCP-C1002-01-FCS
4Px1 mm² mm²
Conductors

External targets




CLIENT DWG NO.	BU-20-VD-303-IN-DIG-0043
EQUIPMENT NO.	20-C-1002
EQUIPMENT LOCATION	Iran, Onshore
THIS DRAWING IS OWNED BY AIRPACK, AND SHALL NOT BE PRINTED OR COPIED IN ANY OTHER WAY THAN WITH AIRPACKS PERMISSION!	

SUBJECT		Cable-connection diagram =20-C-1002+UCP-C1002-01-FCS	
ADAPTED TO P&ID REVISION	05	CLIENT	Bushehr Petrochemical Company (BUPC)
CLIENT REF.	Bushehr MEG Plant Project	AIRPACK REF.	17811-30A


DRAWN BY	MaGo
CHECKED BY	RBE
LAST MODIFICATION DATE	
AIRPACK DWG NO.	17811-05
REVISION	01
TOTAL PAGE AMOUNT	6

=
+
CURRENT PAGE

Internal targets

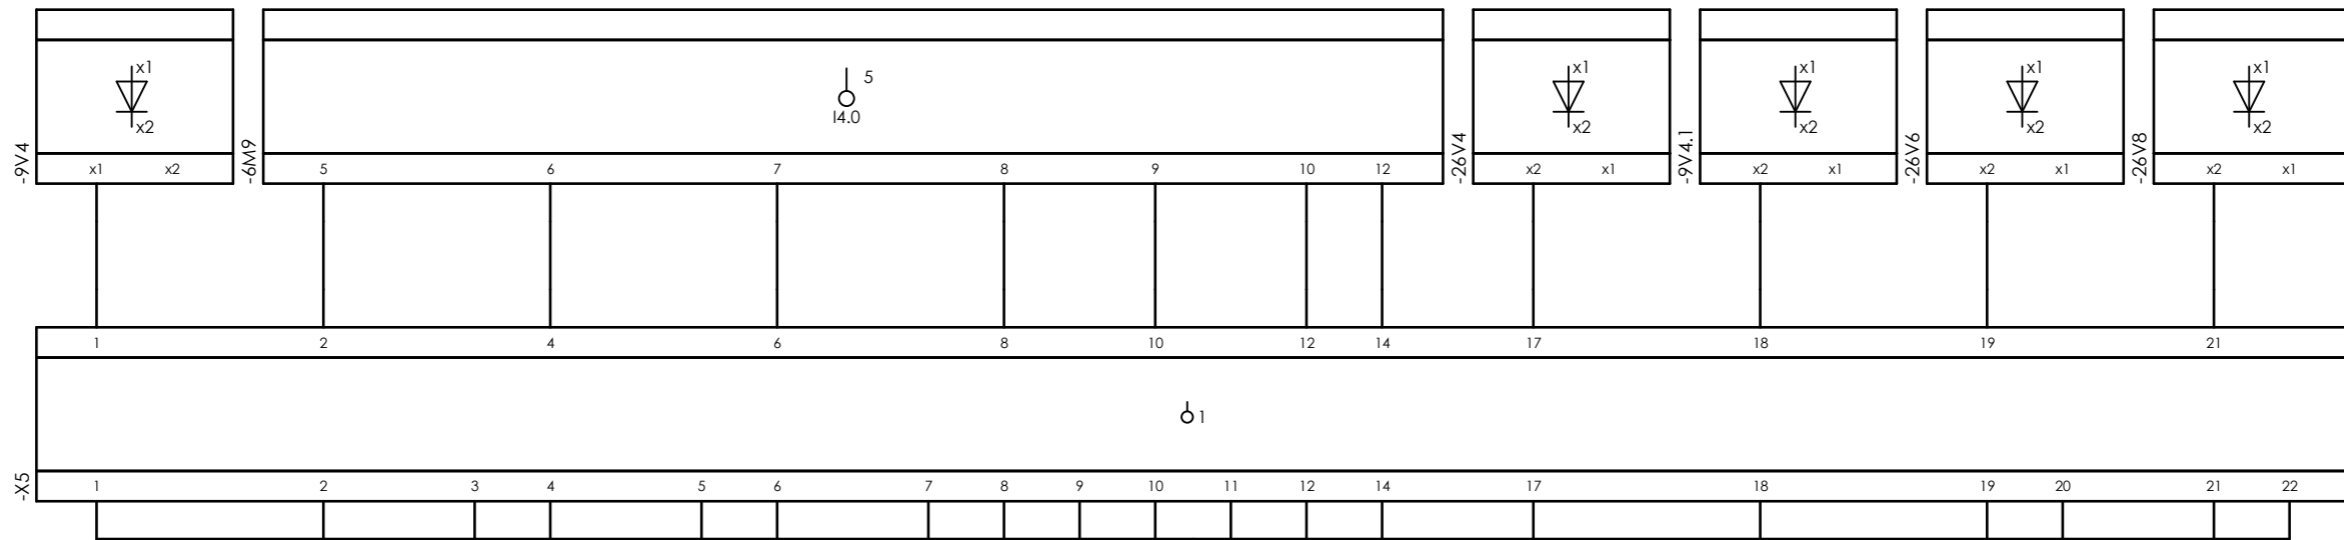

External targets

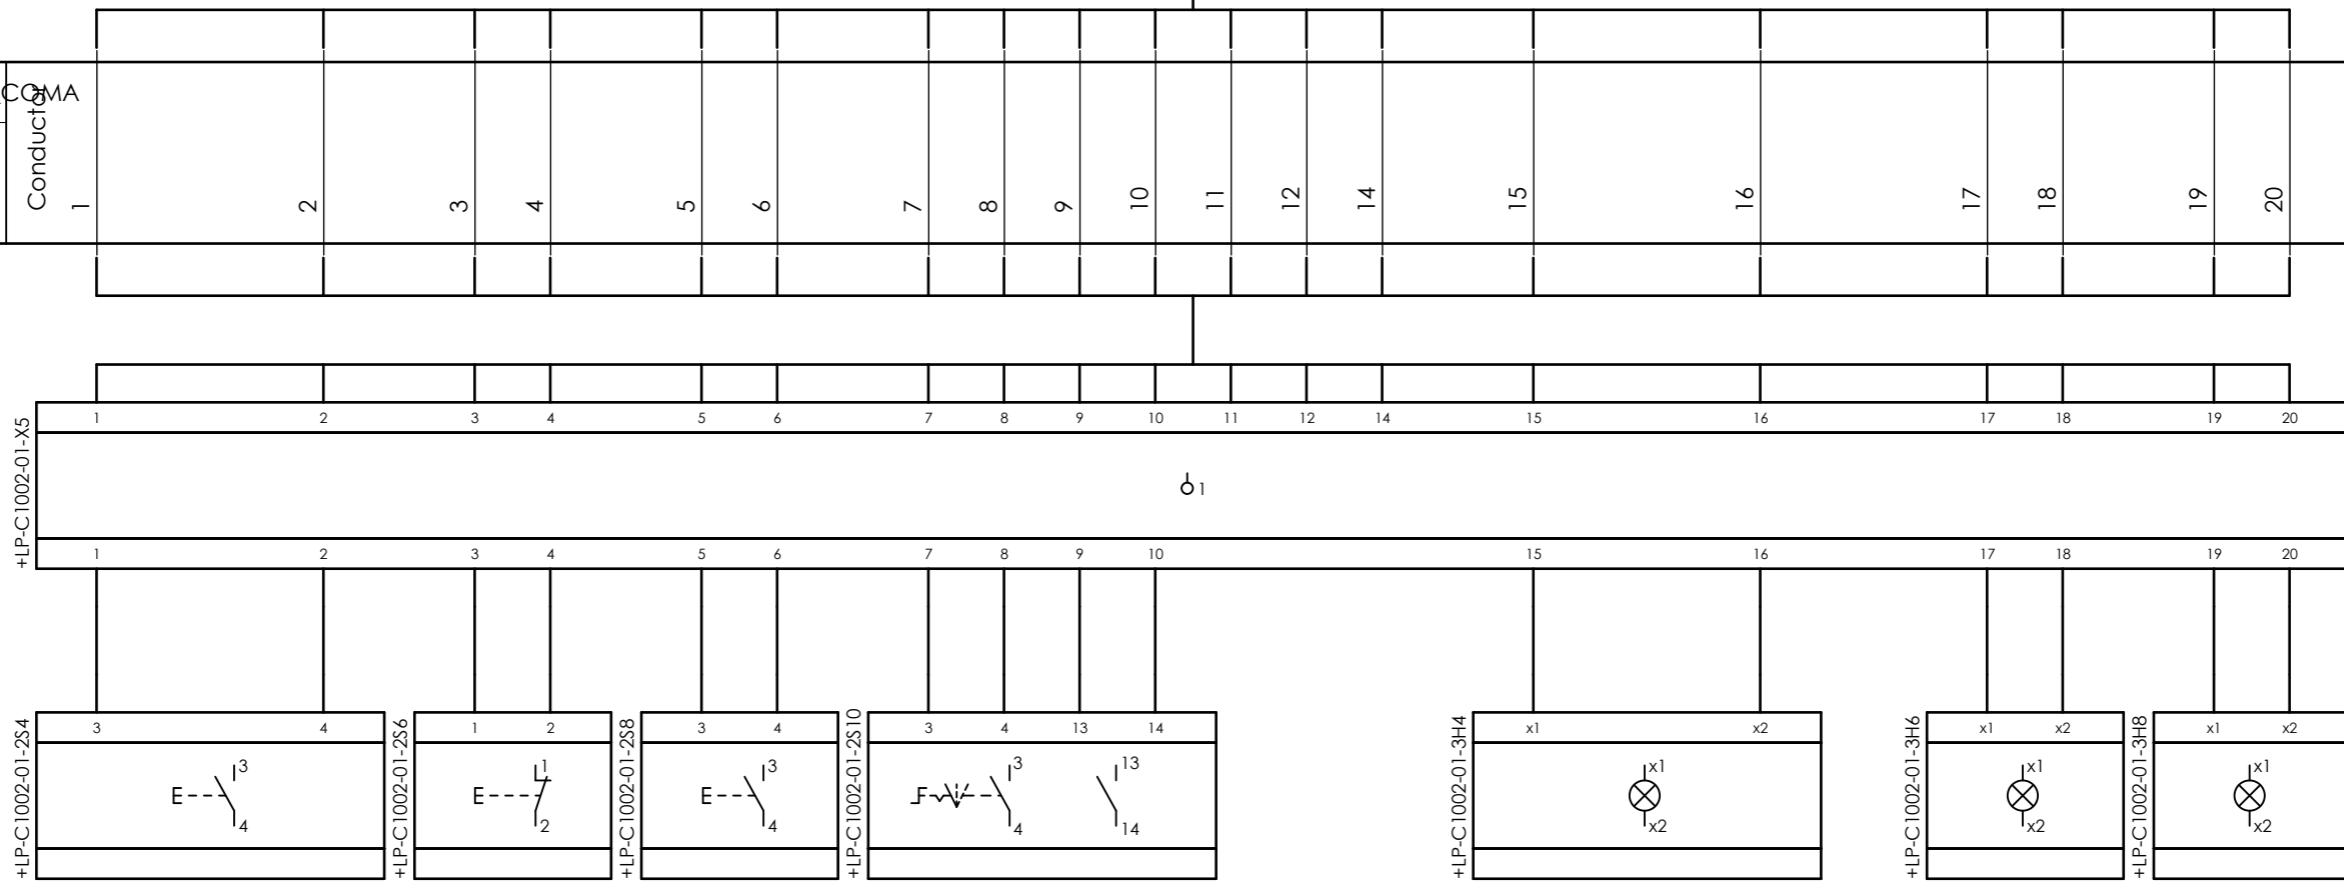


CLIENT DWG NO. BU-20-VD-303-IN-DIG-0043
 EQUIPMENT NO. 20-C-1002
 EQUIPMENT LOCATION Iran, Onshore
 THIS DRAWING IS OWNED BY AIRPACK, AND SHALL NOT BE PRINTED OR COPIED IN ANY OTHER WAY THAN WITH AIRPACKS PERMISSION!

SUBJECT Cable-connection diagram =20-C-1002+UCP-C1002-01-LCP_COMA
 ADAPTED TO P&ID REVISION 05
 CLIENT Bushehr Petrochemical Company (BUPC)
 CLIENT REF. Bushehr MEG Plant Project
 AIRPACK REF. 17811-30A


DRAWN BY MaGo
 CHECKED BY RBE
 LAST MODIFICATION DATE
 AIRPACK DWG NO. 17811-05
 REVISION 01
 TOTAL PAGE AMOUNT 7

=
 +
 CURRENT PAGE
 7


Internal targets

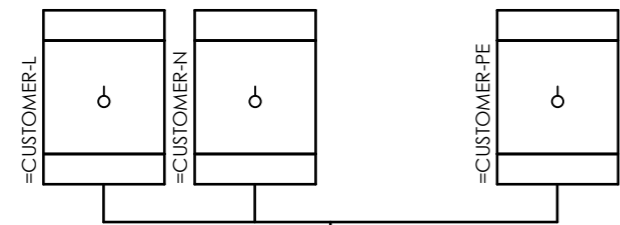

=20-C-1002+UCP-C1002-01-PS_00
3x2.5 sqmm

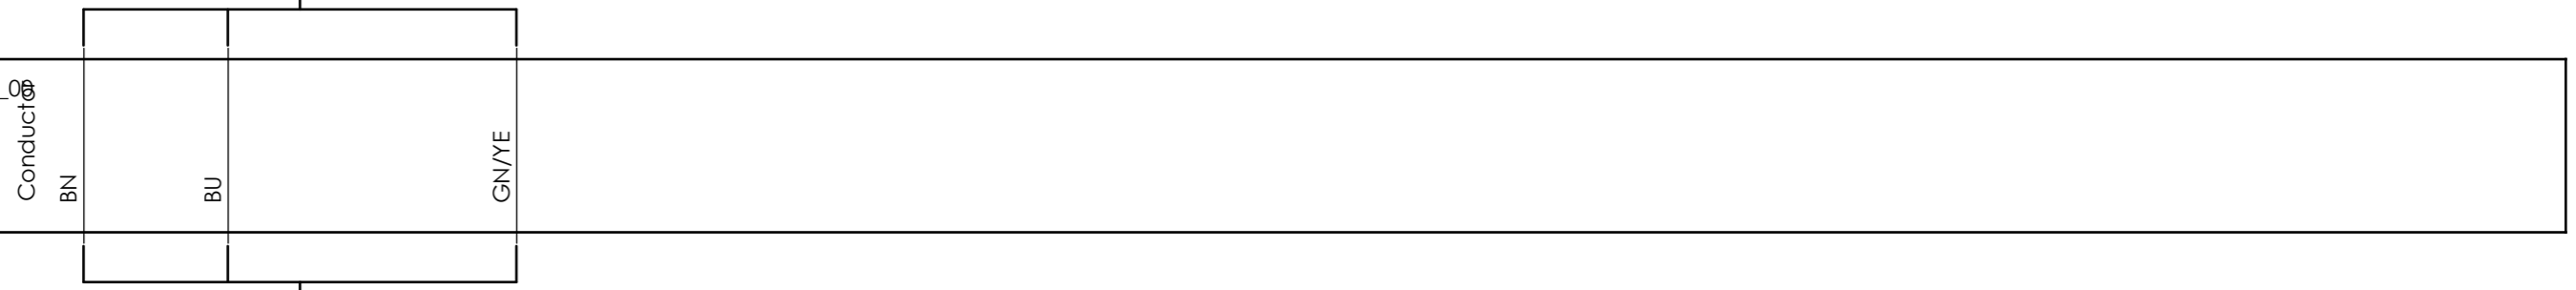

External targets

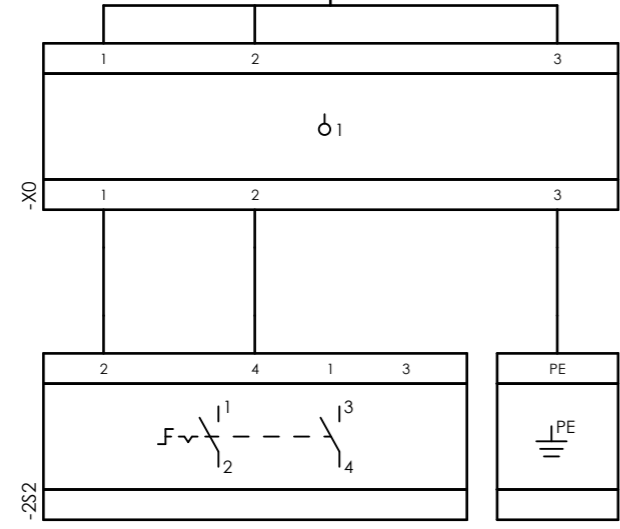


CLIENT DWG NO.	BU-20-VD-303-IN-DIG-0043
EQUIPMENT NO.	20-C-1002
EQUIPMENT LOCATION	Iran, Onshore
THIS DRAWING IS OWNED BY AIRPACK, AND SHALL NOT BE PRINTED OR COPIED IN ANY OTHER WAY THAN WITH AIRPACKS PERMISSION!	

SUBJECT		Cable-connection diagram =20-C-1002+UCP-C1002-01-PS_00	
ADAPTED TO P&ID REVISION	05	CLIENT	Bushehr Petrochemical Company (BUPC)
CLIENT REF.	Bushehr MEG Plant Project	AIRPACK REF.	17811-30A

DRAWN BY	MaGo
CHECKED BY	RBE
LAST MODIFICATION DATE	
AIRPACK DWG NO.	17811-05
REVISION	01
TOTAL PAGE AMOUNT	8

=	
+	
CURRENT PAGE	


Internal targets

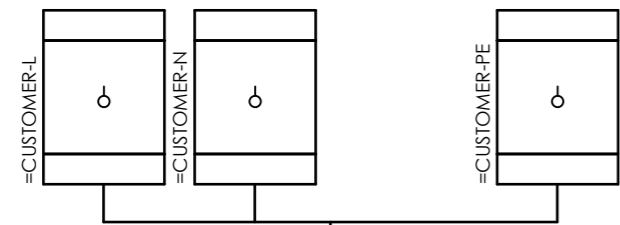

=20-C-1002+UCP-C1002-01-PS_01



External targets

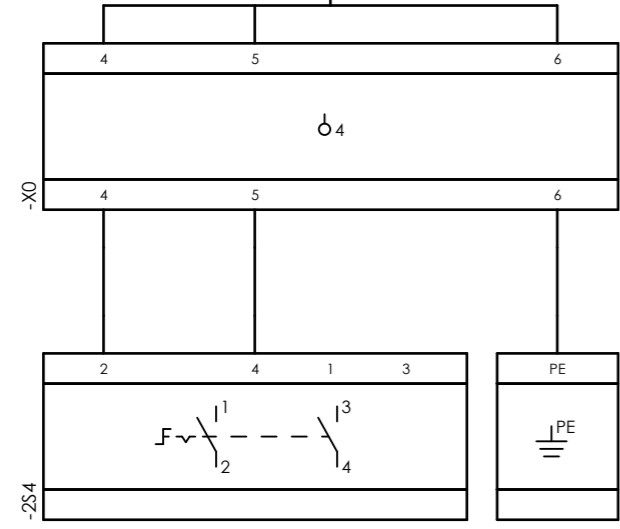


CLIENT DWG NO.	BU-20-VD-303-IN-DIG-0043
EQUIPMENT NO.	20-C-1002
EQUIPMENT LOCATION	Iran, Onshore
THIS DRAWING IS OWNED BY AIRPACK, AND SHALL NOT BE PRINTED OR COPIED IN ANY OTHER WAY THAN WITH AIRPACKS PERMISSION!	

SUBJECT		Cable-connection diagram =20-C-1002+UCP-C1002-01-PS_01	
ADAPTED TO P&ID REVISION	05	CLIENT	Bushehr Petrochemical Company (BUPC)
CLIENT REF.	Bushehr MEG Plant Project	AIRPACK REF.	17811-30A


DRAWN BY	MaGo
CHECKED BY	RBE
LAST MODIFICATION DATE	
AIRPACK DWG NO.	17811-05
REVISION	01
TOTAL PAGE AMOUNT	9

=	
+	
CURRENT PAGE	


Internal targets

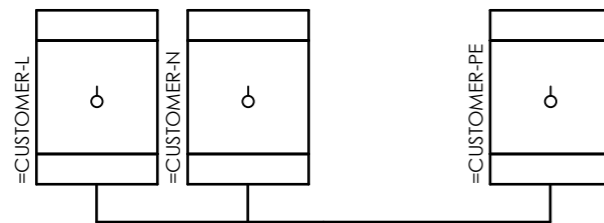

=20-C-1002+UCP-C1002-01-PS_02
3x2.5 sqmm

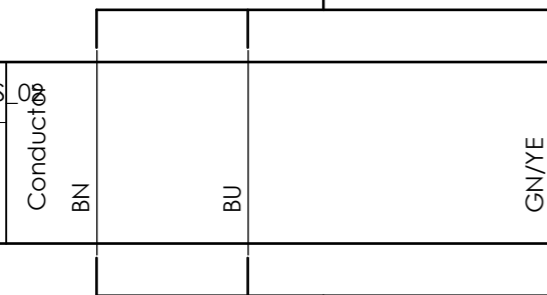

External targets

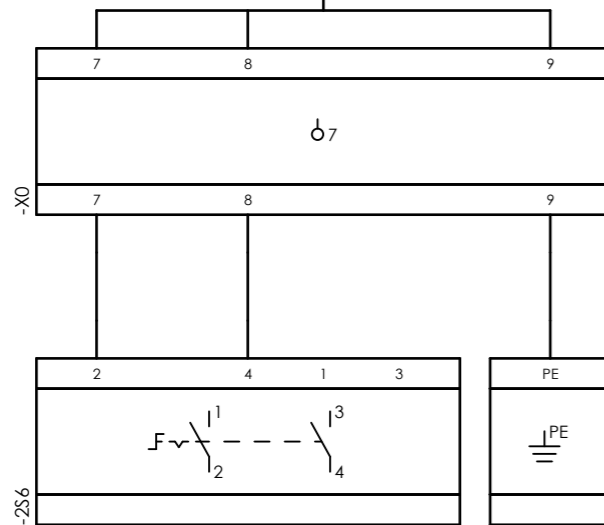


CLIENT DWG NO.	BU-20-VD-303-IN-DIG-0043
EQUIPMENT NO.	20-C-1002
EQUIPMENT LOCATION	Iran, Onshore
THIS DRAWING IS OWNED BY AIRPACK, AND SHALL NOT BE PRINTED OR COPIED IN ANY OTHER WAY THAN WITH AIRPACKS PERMISSION!	

SUBJECT		Cable-connection diagram =20-C-1002+UCP-C1002-01-PS_02	
ADAPTED TO P&ID REVISION	05	CLIENT	Bushehr Petrochemical Company (BUPC)
CLIENT REF.	Bushehr MEG Plant Project	AIRPACK REF.	17811-30A

DRAWN BY	MaGo
CHECKED BY	RBE
LAST MODIFICATION DATE	
AIRPACK DWG NO.	17811-05
REVISION	01
TOTAL PAGE AMOUNT	10

=	
+	
CURRENT PAGE	

Internal targets

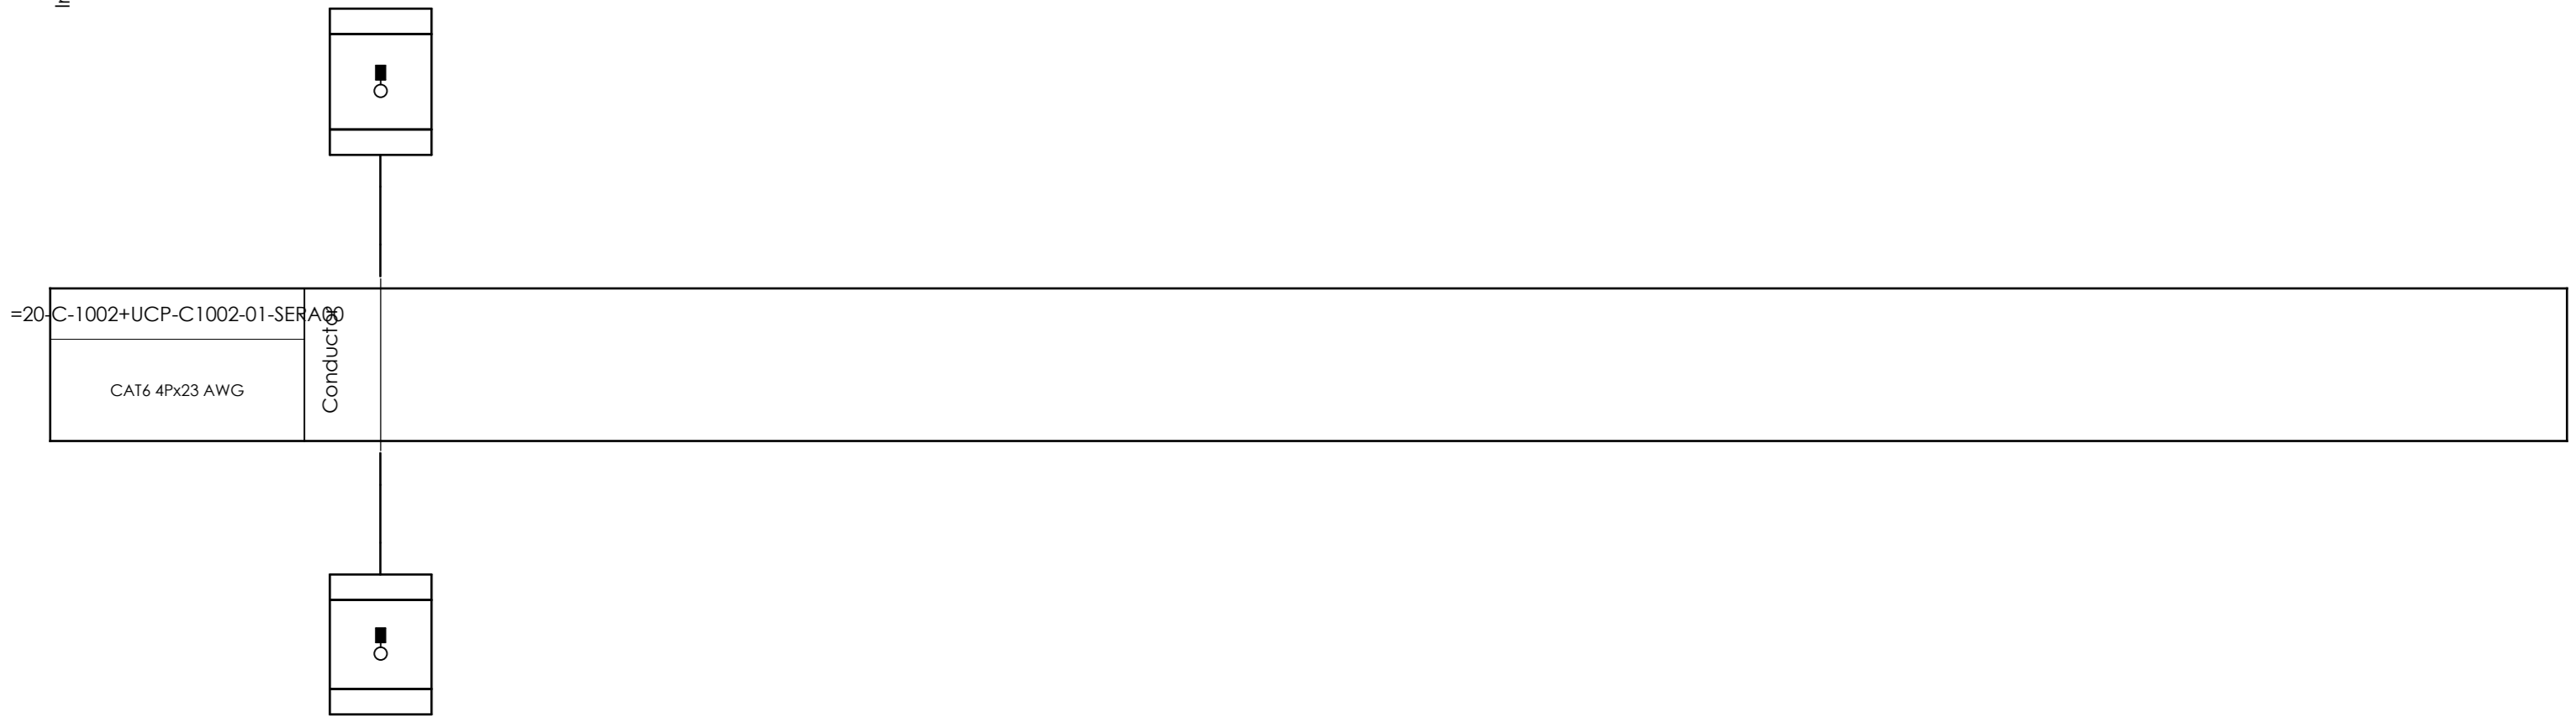


External targets



CLIENT DWG NO.	BU-20-VD-303-IN-DIG-0043	SUBJECT		DRAWN BY	MaGo	=
EQUIPMENT NO.	20-C-1002	Cable-connection diagram =20-C-1002+UCP-C1002-01-SERA00		CHECKED BY	RBE	+
EQUIPMENT LOCATION	Iran, Onshore	ADAPTED TO P&ID REVISION	05	LAST MODIFICATION DATE		CURRENT PAGE
THIS DRAWING IS OWNED BY AIRPACK, AND SHALL NOT BE PRINTED OR COPIED IN ANY OTHER WAY THAN WITH AIRPACKS PERMISSION!		CLIENT	Bushehr Petrochemical Company (BUPC)	AIRPACK DWG NO.	17811-05	
		CLIENT REF.	Bushehr MEG Plant Project	REVISION	01	
		AIRPACK REF.	17811-30A	TOTAL PAGE AMOUNT	11	

Internal targets

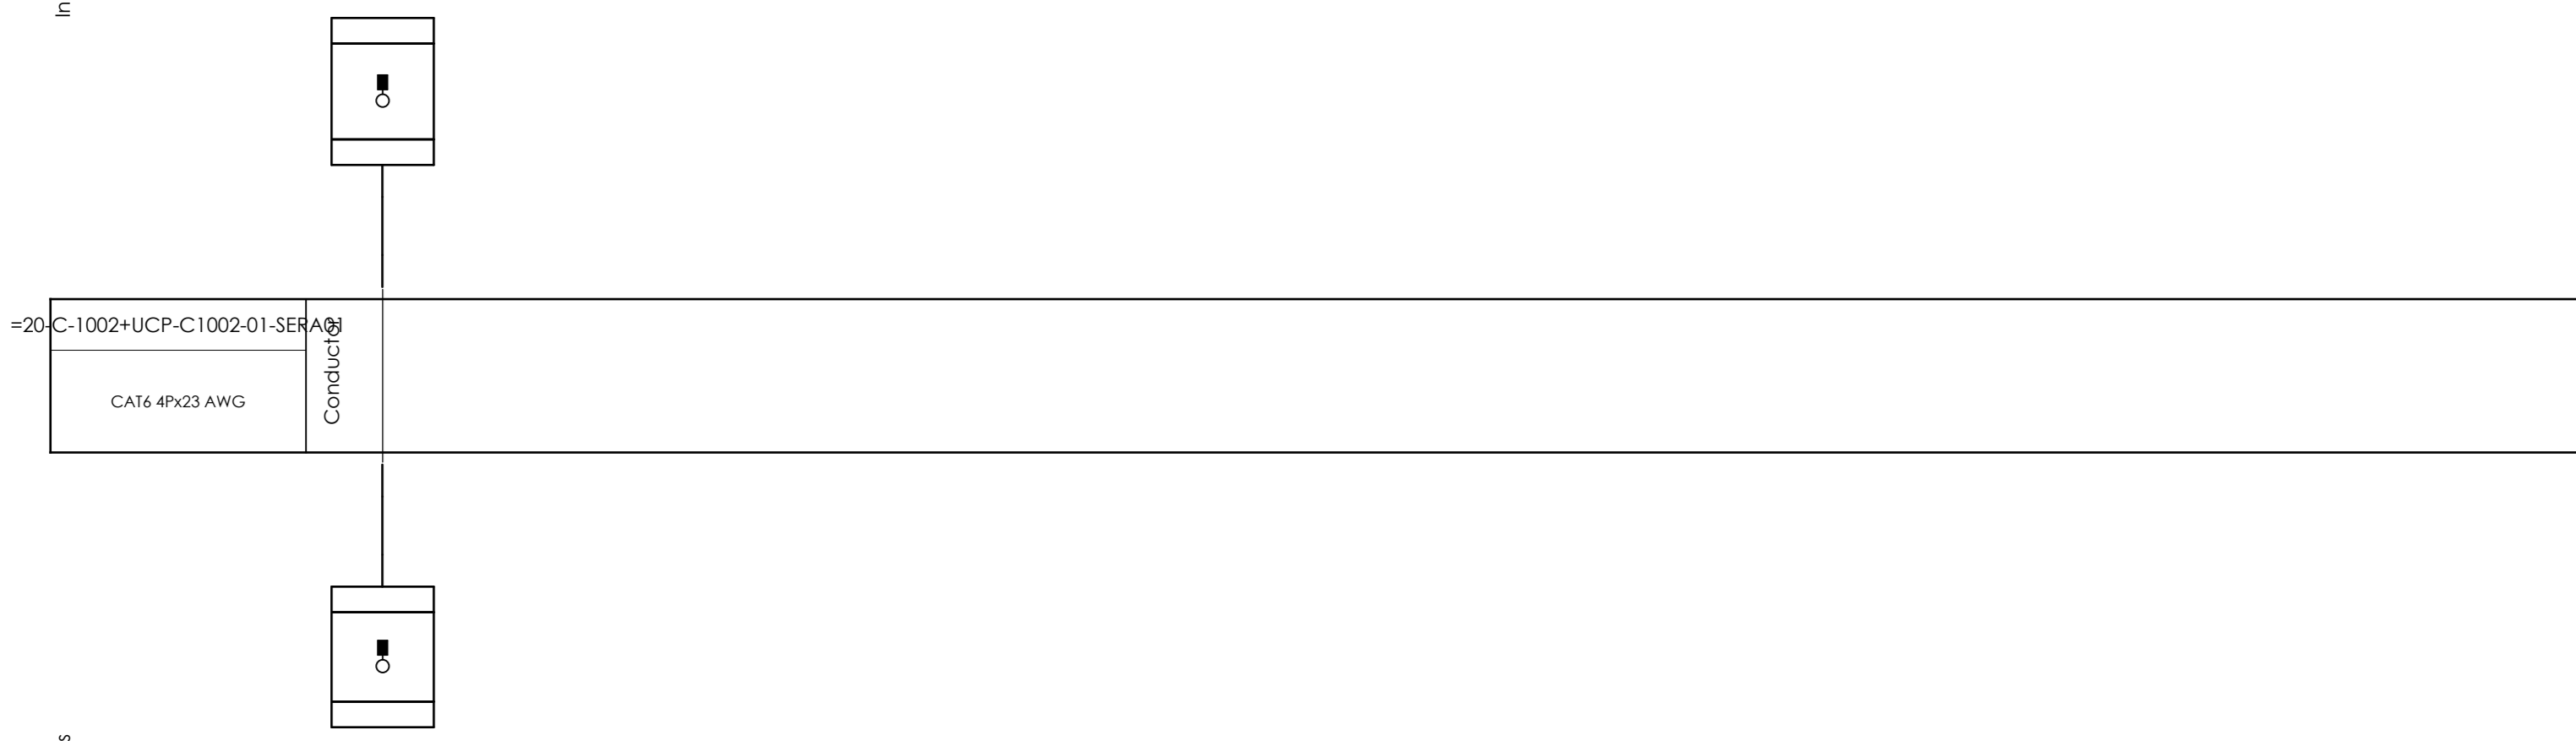

=20-C-1002+UCP-C1002-01-SERA01

CAT6 4Px23 AWG

Conductors

External targets




CLIENT DWG NO.	BU-20-VD-303-IN-DIG-0043
EQUIPMENT NO.	20-C-1002
EQUIPMENT LOCATION	Iran, Onshore
THIS DRAWING IS OWNED BY AIRPACK, AND SHALL NOT BE PRINTED OR COPIED IN ANY OTHER WAY THAN WITH AIRPACKS PERMISSION!	


SUBJECT		Cable-connection diagram =20-C-1002+UCP-C1002-01-SERA01	
ADAPTED TO P&ID REVISION	05	CLIENT	Bushehr Petrochemical Company (BUPC)
AIRPACK REF.	17811-30A	CLIENT REF.	Bushehr MEG Plant Project

DRAWN BY	MaGo	=
CHECKED BY	RBE	+
LAST MODIFICATION DATE		CURRENT PAGE
AIRPACK DWG NO.	17811-05	
REVISION	01	
TOTAL PAGE AMOUNT	12	

Internal targets

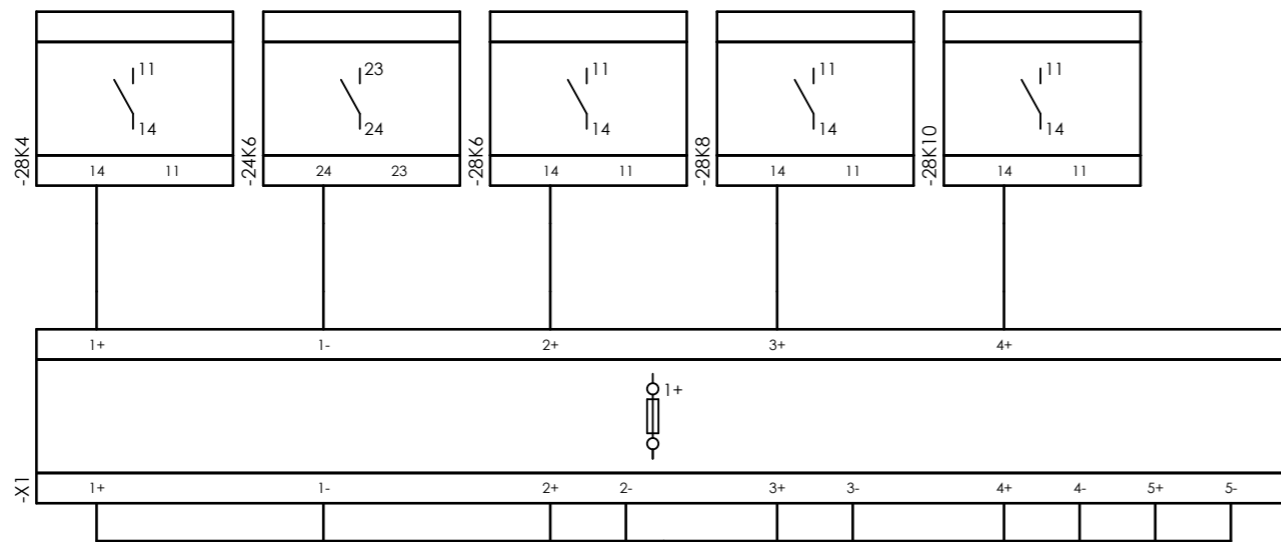

External targets

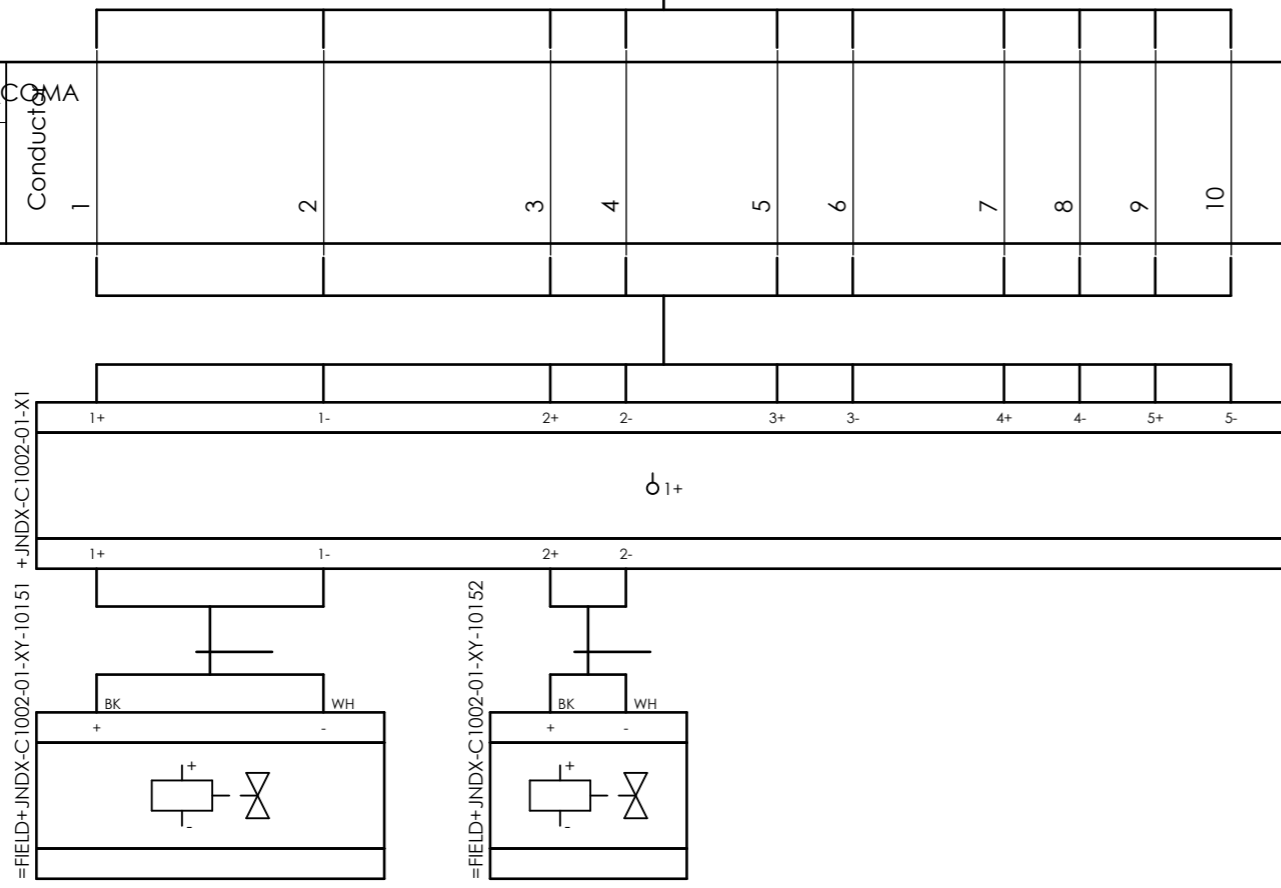


CLIENT DWG NO. BU-20-VD-303-IN-DIG-0043
 EQUIPMENT NO. 20-C-1002
 EQUIPMENT LOCATION Iran, Onshore
 THIS DRAWING IS OWNED BY AIRPACK, AND SHALL NOT BE PRINTED OR COPIED IN ANY OTHER WAY THAN WITH AIRPACKS PERMISSION!

SUBJECT Cable-connection diagram =20-C-1002+UCP-C1002-01-SOL_COMA
 ADAPTED TO P&ID REVISION 05
 CLIENT Bushehr Petrochemical Company (BUPC)
 CLIENT REF. Bushehr MEG Plant Project
 AIRPACK REF. 17811-30A


DRAWN BY MaGo
 CHECKED BY RBE
 LAST MODIFICATION DATE
 AIRPACK DWG NO. 17811-05
 REVISION 01
 TOTAL PAGE AMOUNT 13

=
 +
 CURRENT PAGE
 13


Internal targets

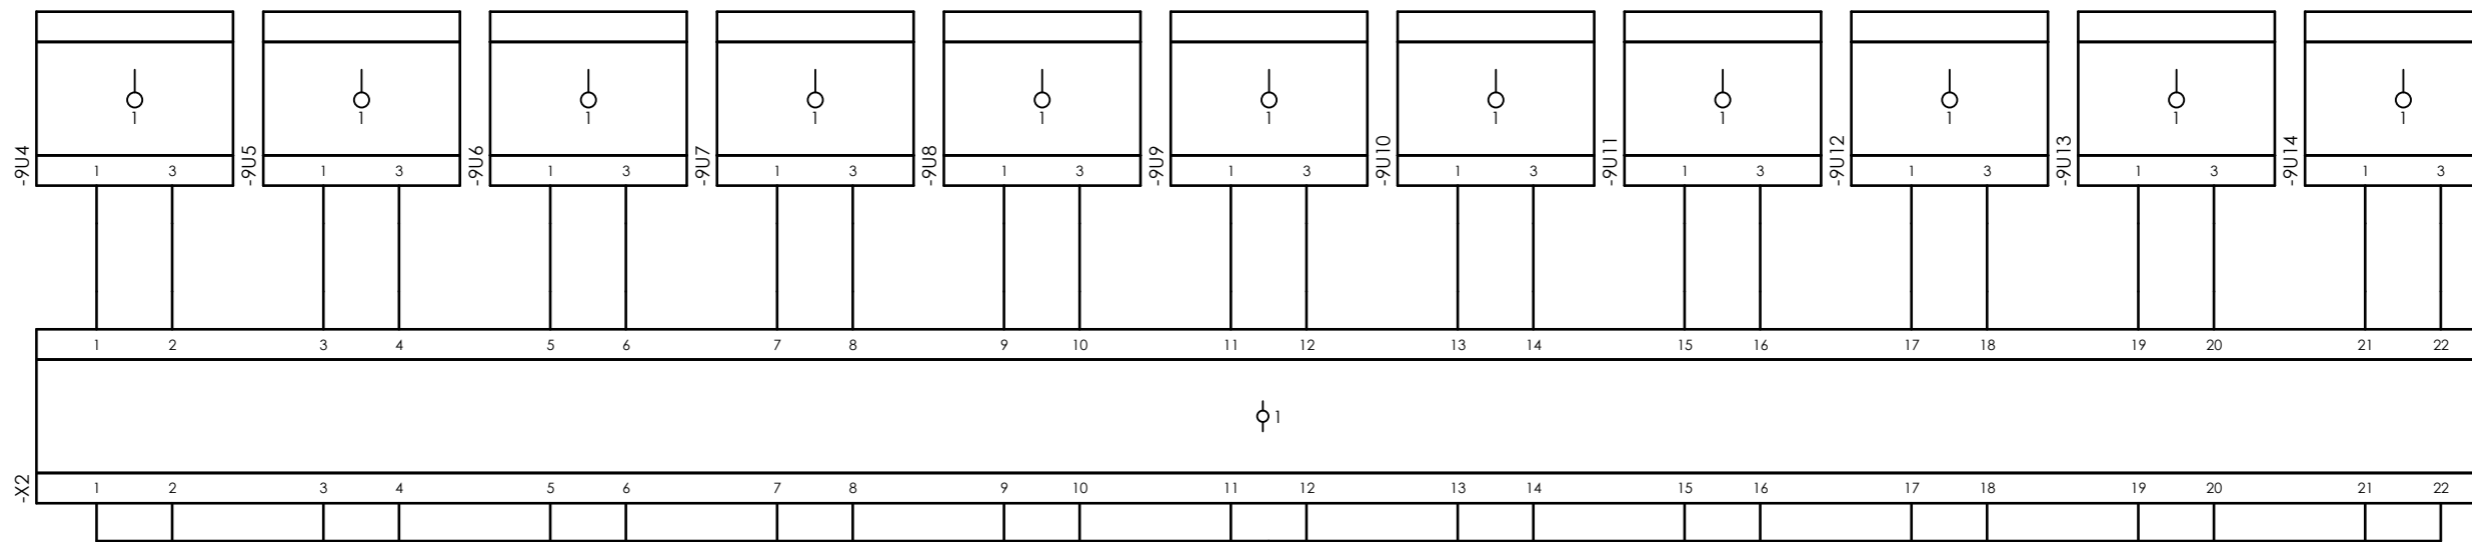

=20-C-1002+UCP-C1002-01-TR_COMA

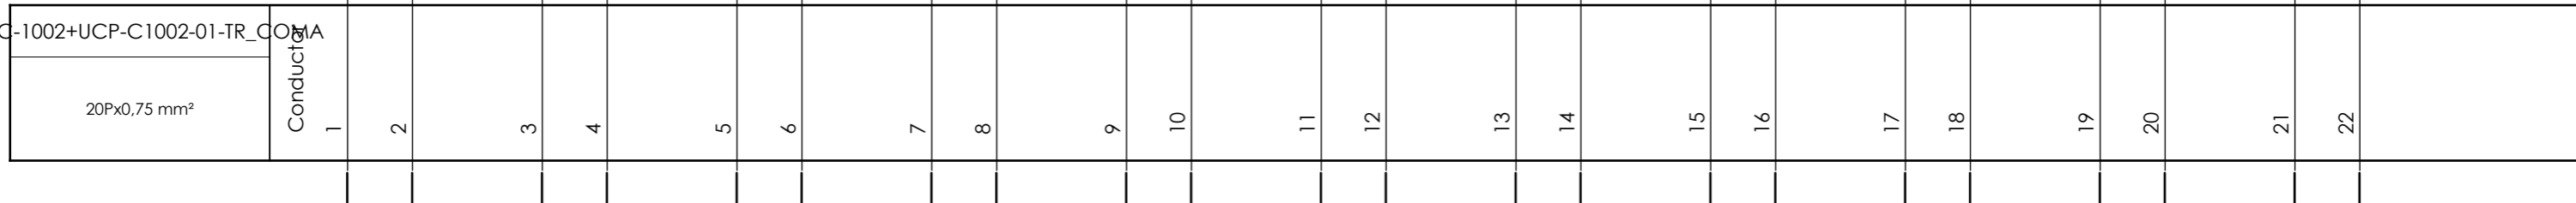

External targets

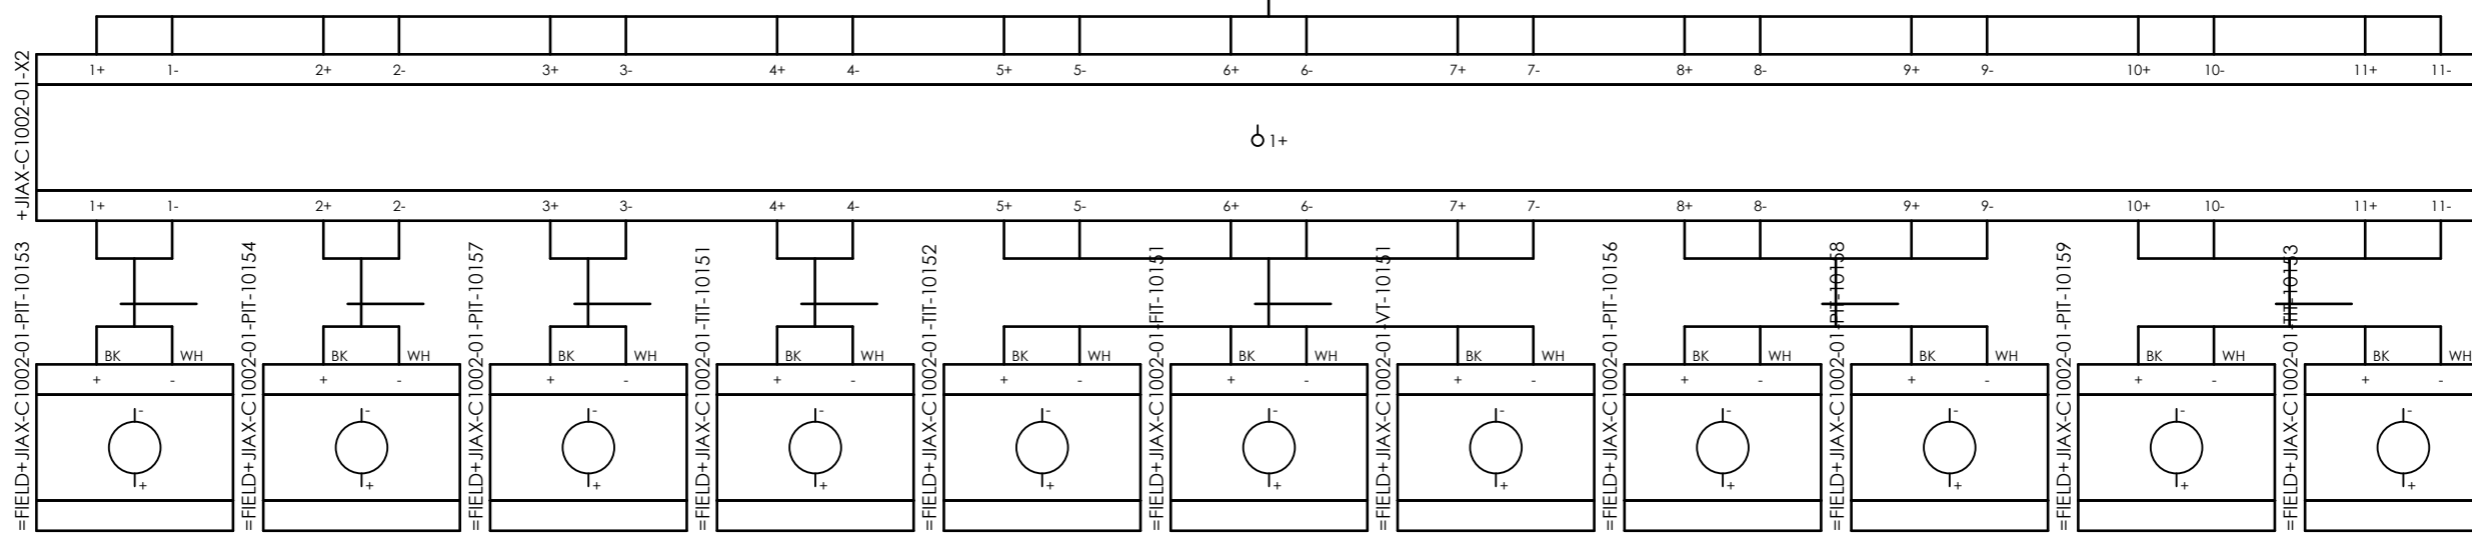


CLIENT DWG NO.	BU-20-VD-303-IN-DIG-0043
EQUIPMENT NO.	20-C-1002
EQUIPMENT LOCATION	Iran, Onshore
THIS DRAWING IS OWNED BY AIRPACK, AND SHALL NOT BE PRINTED OR COPIED IN ANY OTHER WAY THAN WITH AIRPACKS PERMISSION!	


SUBJECT		Cable-connection diagram =20-C-1002+UCP-C1002-01-TR_COMA	
ADAPTED TO P&ID REVISION	05		
CLIENT	Bushehr Petrochemical Company (BUPC)		
CLIENT REF.	Bushehr MEG Plant Project		
AIRPACK REF.	17811-30A		

DRAWN BY	MaGo	CURRENT PAGE
CHECKED BY	RBE	
LAST MODIFICATION DATE		
AIRPACK DWG NO.	17811-05	
REVISION	01	
TOTAL PAGE AMOUNT	14	


Internal targets

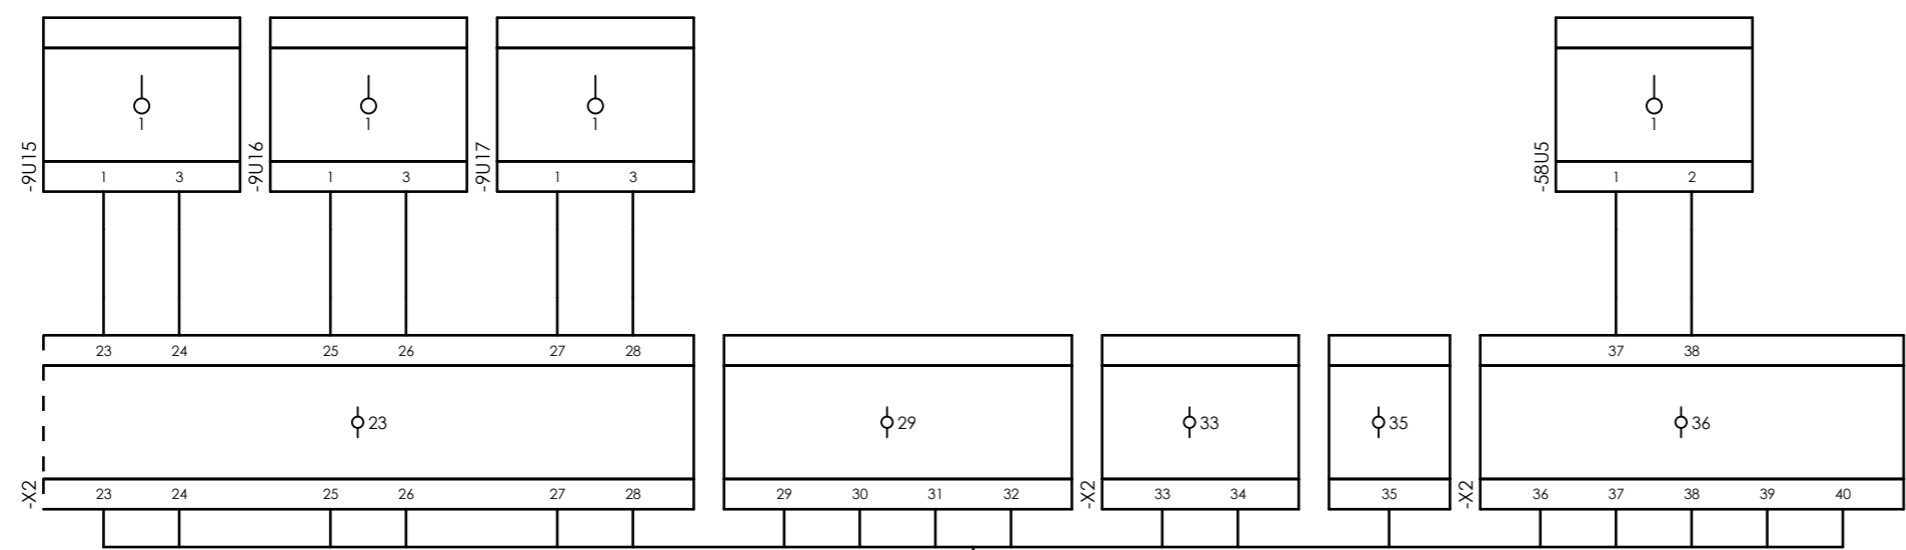

=20-C-1002+UCP-C1002-01-TR_COMA

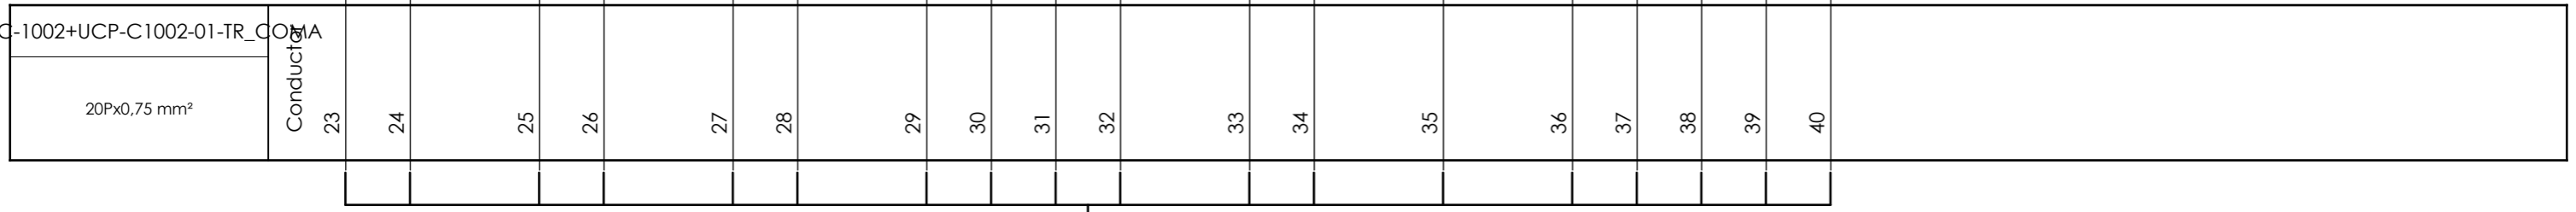

External targets

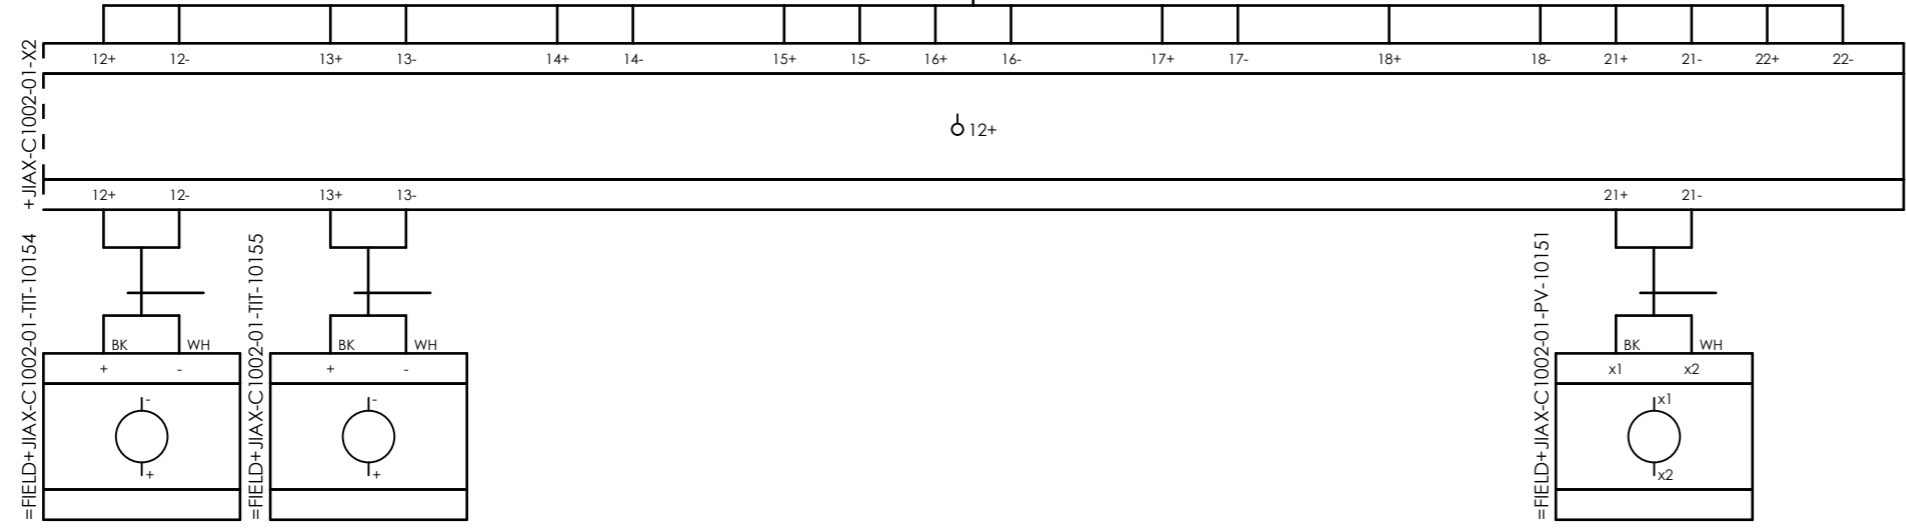


CLIENT DWG NO.	BU-20-VD-303-IN-DIG-0043
EQUIPMENT NO.	20-C-1002
EQUIPMENT LOCATION	Iran, Onshore
THIS DRAWING IS OWNED BY AIRPACK, AND SHALL NOT BE PRINTED OR COPIED IN ANY OTHER WAY THAN WITH AIRPACKS PERMISSION!	

SUBJECT	
Cable-connection diagram =20-C-1002+UCP-C1002-01-TR_COMA	
ADAPTED TO P&ID REVISION	05
CLIENT	Bushehr Petrochemical Company (BUPC)
CLIENT REF.	Bushehr MEG Plant Project
AIRPACK REF.	17811-30A

DRAWN BY	MaGo
CHECKED BY	RBE
LAST MODIFICATION DATE	
AIRPACK DWG NO.	17811-05
REVISION	01
TOTAL PAGE AMOUNT	15

=
+
CURRENT PAGE


Internal targets

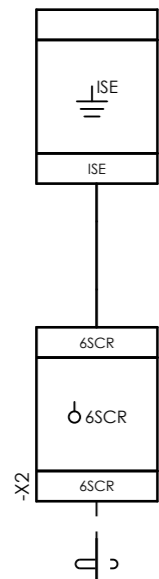

=20-C-1002+JIAX-C1002-01-FIT-10151



External targets

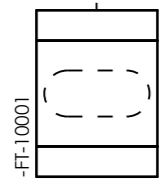


CLIENT DWG NO.	BU-20-VD-303-IN-DIG-0043
EQUIPMENT NO.	20-C-1002
EQUIPMENT LOCATION	Iran, Onshore
THIS DRAWING IS OWNED BY AIRPACK, AND SHALL NOT BE PRINTED OR COPIED IN ANY OTHER WAY THAN WITH AIRPACKS PERMISSION!	

SUBJECT		Cable-connection diagram =20-C-1002+JIAX-C1002-01-FIT-10151	
ADAPTED TO P&ID REVISION	05	CLIENT	Bushehr Petrochemical Company (BUPC)
CLIENT REF.	Bushehr MEG Plant Project	AIRPACK REF.	17811-30A

DRAWN BY	MaGo
CHECKED BY	RBE
LAST MODIFICATION DATE	
AIRPACK DWG NO.	17811-05
REVISION	01
TOTAL PAGE AMOUNT	16

=	
+	
CURRENT PAGE	

Internal targets

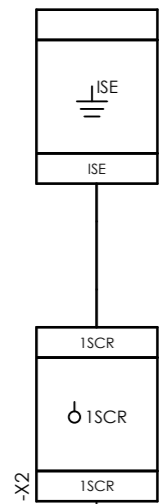


-X2

=20-C-1002+JIAX-C1002-01-PIT-10153



-

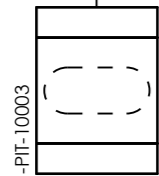

External targets



CLIENT DWG NO.	BU-20-VD-303-IN-DIG-0043
EQUIPMENT NO.	20-C-1002
EQUIPMENT LOCATION	Iran, Onshore

SUBJECT	
Cable-connection diagram =20-C-1002+JIAX-C1002-01-PIT-10153	
ADAPTED TO P&ID REVISION	05

DRAWN BY	MaGo
CHECKED BY	RBE
LAST MODIFICATION DATE	



THIS DRAWING IS OWNED BY AIRPACK, AND SHALL NOT BE PRINTED OR COPIED IN ANY OTHER WAY THAN WITH AIRPACKS PERMISSION!

CLIENT	Bushehr Petrochemical Company (BUPC)
CLIENT REF.	Bushehr MEG Plant Project
AIRPACK REF.	17811-30A




AIRPACK DWG NO.	17811-05
REVISION	01
TOTAL PAGE AMOUNT	17

=
+
CURRENT PAGE

 Internal targets

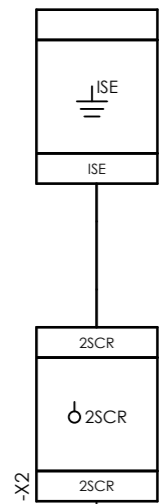

=20-C-1002+JIAX-C1002-01-PIT-10154

 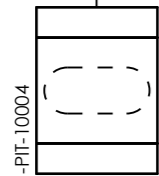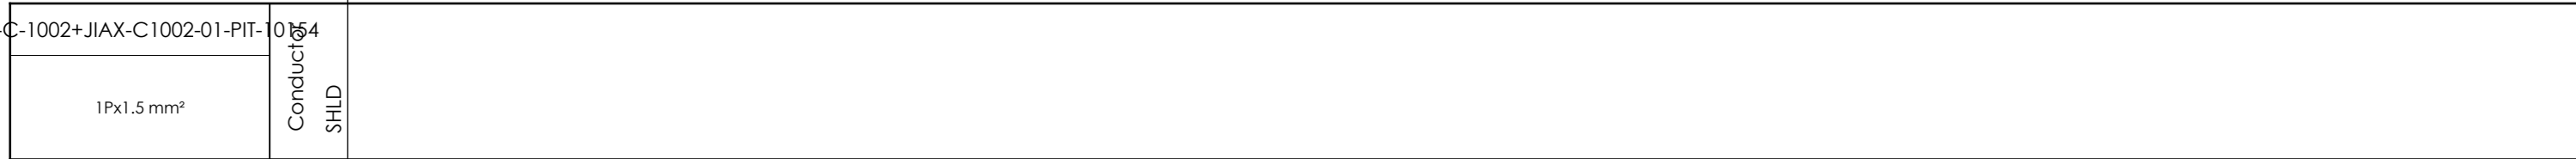

External targets





CLIENT DWG NO.	BU-20-VD-303-IN-DIG-0043
EQUIPMENT NO.	20-C-1002
EQUIPMENT LOCATION	Iran, Onshore
THIS DRAWING IS OWNED BY AIRPACK, AND SHALL NOT BE PRINTED OR COPIED IN ANY OTHER WAY THAN WITH AIRPACKS PERMISSION!	

SUBJECT		Cable-connection diagram =20-C-1002+JIAX-C1002-01-PIT-10154	
ADAPTED TO P&ID REVISION	05	CLIENT	Bushehr Petrochemical Company (BUPC)
CLIENT REF.	Bushehr MEG Plant Project	AIRPACK REF.	17811-30A


DRAWN BY	MaGo
CHECKED BY	RBE
LAST MODIFICATION DATE	
AIRPACK DWG NO.	17811-05
REVISION	01
TOTAL PAGE AMOUNT	18

=	
+	
CURRENT PAGE	

Internal targets

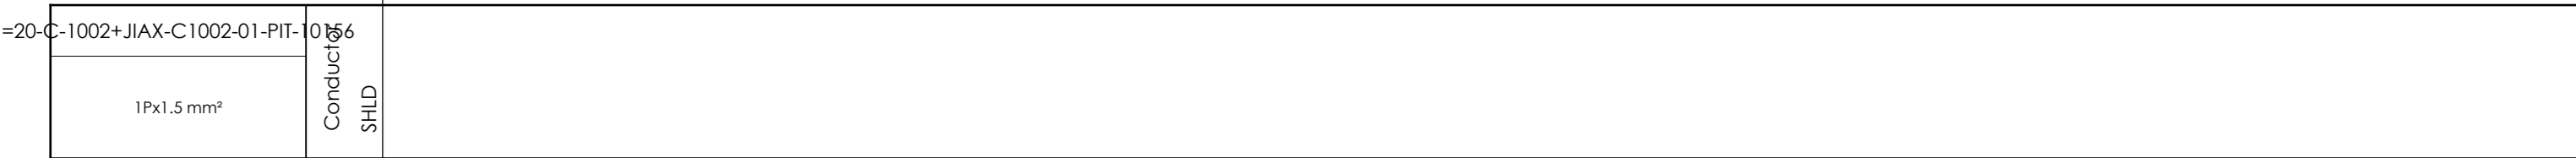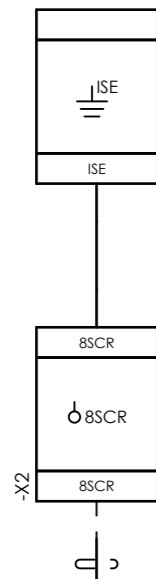

External targets

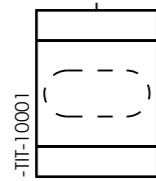

CLIENT DWG NO.	BU-20-VD-303-IN-DIG-0043
EQUIPMENT NO.	20-C-1002
EQUIPMENT LOCATION	Iran, Onshore



THIS DRAWING IS OWNED BY AIRPACK, AND SHALL NOT BE PRINTED OR COPIED IN ANY OTHER WAY THAN WITH AIRPACKS PERMISSION!

SUBJECT		Cable-connection diagram =20-C-1002+JIAX-C1002-01-PIT-10156	
ADAPTED TO P&ID REVISION	05	CLIENT	Bushehr Petrochemical Company (BUPC)
CLIENT REF.	Bushehr MEG Plant Project	AIRPACK REF.	17811-30A


DRAWN BY	MaGo
CHECKED BY	RBE
LAST MODIFICATION DATE	
AIRPACK DWG NO.	17811-05
REVISION	01
TOTAL PAGE AMOUNT	19

=	
+	
CURRENT PAGE	

Internal targets

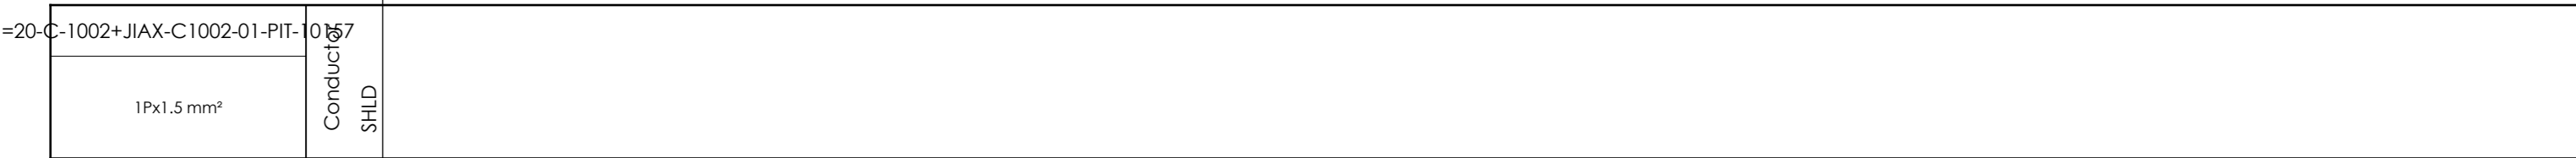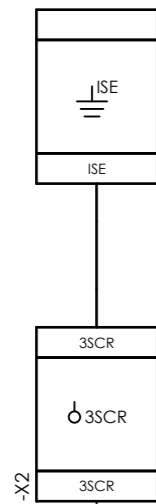

External targets

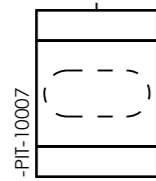


CLIENT DWG NO.	BU-20-VD-303-IN-DIG-0043
EQUIPMENT NO.	20-C-1002
EQUIPMENT LOCATION	Iran, Onshore
THIS DRAWING IS OWNED BY AIRPACK, AND SHALL NOT BE PRINTED OR COPIED IN ANY OTHER WAY THAN WITH AIRPACKS PERMISSION!	

SUBJECT		Cable-connection diagram =20-C-1002+JIAX-C1002-01-PIT-10157	
ADAPTED TO P&ID REVISION	05	CLIENT	Bushehr Petrochemical Company (BUPC)
CLIENT REF.	Bushehr MEG Plant Project	AIRPACK REF.	17811-30A


DRAWN BY	MaGo
CHECKED BY	RBE
LAST MODIFICATION DATE	
AIRPACK DWG NO.	17811-05
REVISION	01
TOTAL PAGE AMOUNT	20

=	
+	
CURRENT PAGE	


Internal targets

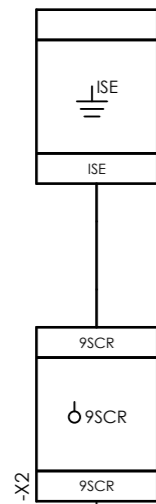

X2

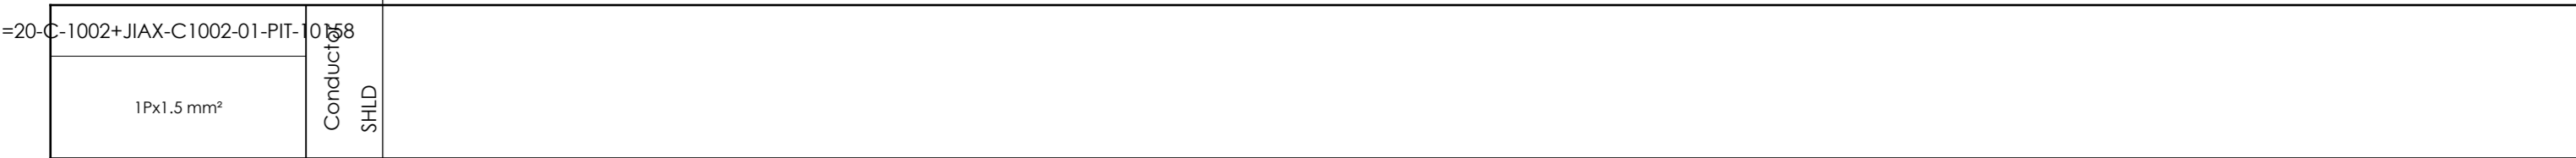

-TIT-10001

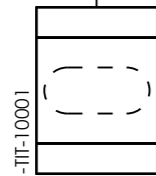

External targets




CLIENT DWG NO.	BU-20-VD-303-IN-DIG-0043
EQUIPMENT NO.	20-C-1002
EQUIPMENT LOCATION	Iran, Onshore
THIS DRAWING IS OWNED BY AIRPACK, AND SHALL NOT BE PRINTED OR COPIED IN ANY OTHER WAY THAN WITH AIRPACKS PERMISSION!	

SUBJECT		Cable-connection diagram =20-C-1002+JIAX-C1002-01-PIT-10158	
ADAPTED TO P&ID REVISION	05	CLIENT	Bushehr Petrochemical Company (BUPC)
		CLIENT REF.	Bushehr MEG Plant Project
		AIRPACK REF.	17811-30A


DRAWN BY	MaGo	=
CHECKED BY	RBE	+
LAST MODIFICATION DATE		CURRENT PAGE
AIRPACK DWG NO.	17811-05	
REVISION	01	
TOTAL PAGE AMOUNT	21	

Internal targets

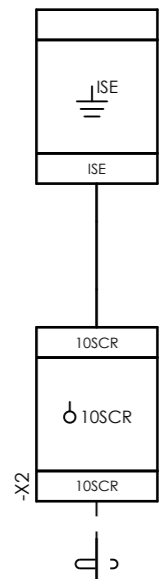


-X2

=20-C-1002+JIAX-C1002-01-PIT-10159

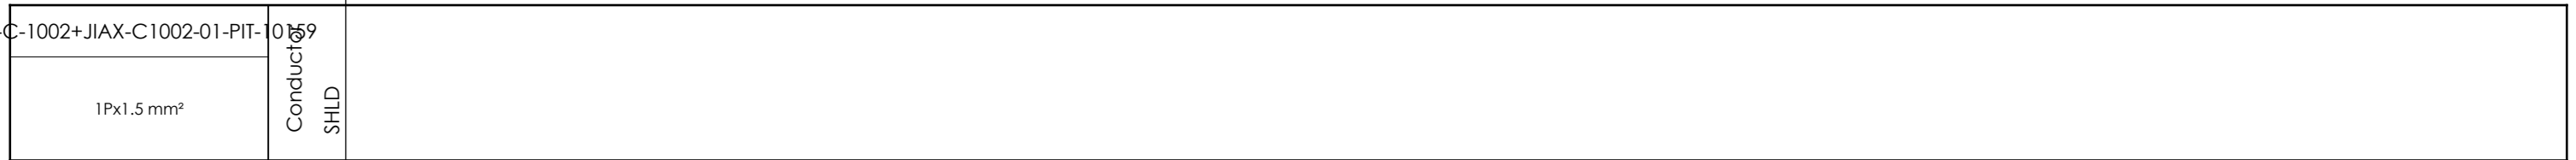

External targets

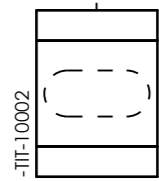


CLIENT DWG NO.	BU-20-VD-303-IN-DIG-0043
EQUIPMENT NO.	20-C-1002
EQUIPMENT LOCATION	Iran, Onshore
THIS DRAWING IS OWNED BY AIRPACK, AND SHALL NOT BE PRINTED OR COPIED IN ANY OTHER WAY THAN WITH AIRPACKS PERMISSION!	

SUBJECT		Cable-connection diagram =20-C-1002+JIAX-C1002-01-PIT-10159	
ADAPTED TO P&ID REVISION	05	CLIENT	Bushehr Petrochemical Company (BUPC)
CLIENT REF.	Bushehr MEG Plant Project	AIRPACK REF.	17811-30A


DRAWN BY	MaGo
CHECKED BY	RBE
LAST MODIFICATION DATE	
AIRPACK DWG NO.	17811-05
REVISION	01
TOTAL PAGE AMOUNT	22

=	
+	
CURRENT PAGE	

Internal targets

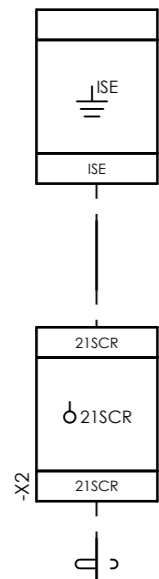

=20-C-1002+JIAX-C1002-01-PV-10151

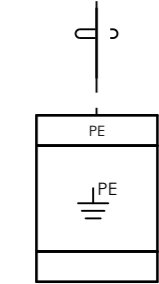

External targets





CLIENT DWG NO.	BU-20-VD-303-IN-DIG-0043
EQUIPMENT NO.	20-C-1002
EQUIPMENT LOCATION	Iran, Onshore
THIS DRAWING IS OWNED BY AIRPACK, AND SHALL NOT BE PRINTED OR COPIED IN ANY OTHER WAY THAN WITH AIRPACKS PERMISSION!	

SUBJECT Cable-connection diagram =20-C-1002+JIAX-C1002-01-PV-10151	
ADAPTED TO P&ID REVISION	05
CLIENT	Bushehr Petrochemical Company (BUPC)
CLIENT REF.	Bushehr MEG Plant Project
AIRPACK REF.	17811-30A




DRAWN BY	MaGo
CHECKED BY	RBE
LAST MODIFICATION DATE	
AIRPACK DWG NO.	17811-05
REVISION	01
TOTAL PAGE AMOUNT	23

=
+
CURRENT PAGE

 Internal targets

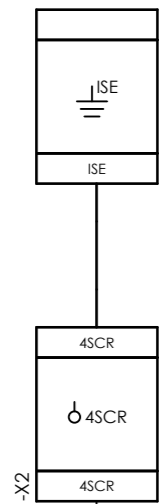

=20-C-1002+JIAX-C1002-01-TIT-10151

 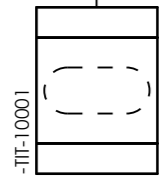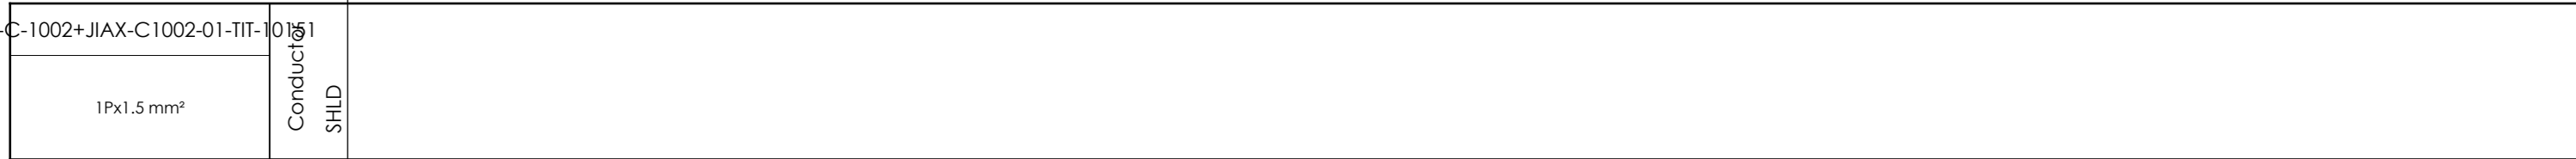

External targets



CLIENT DWG NO.	BU-20-VD-303-IN-DIG-0043
EQUIPMENT NO.	20-C-1002
EQUIPMENT LOCATION	Iran, Onshore


THIS DRAWING IS OWNED BY AIRPACK, AND SHALL NOT BE PRINTED OR COPIED IN ANY OTHER WAY THAN WITH AIRPACKS PERMISSION!

SUBJECT		Cable-connection diagram =20-C-1002+JIAX-C1002-01-TIT-10151	
ADAPTED TO P&ID REVISION	05	CLIENT	Bushehr Petrochemical Company (BUPC)
CLIENT REF.	Bushehr MEG Plant Project	AIRPACK REF.	17811-30A

DRAWN BY	MaGo
CHECKED BY	RBE
LAST MODIFICATION DATE	
AIRPACK DWG NO.	17811-05
REVISION	01
TOTAL PAGE AMOUNT	24


=	
+	
CURRENT PAGE	

Internal targets

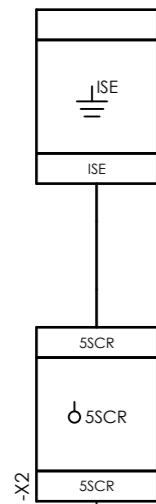


-X2

=20-C-1002+JIAX-C1002-01-TIT-10152

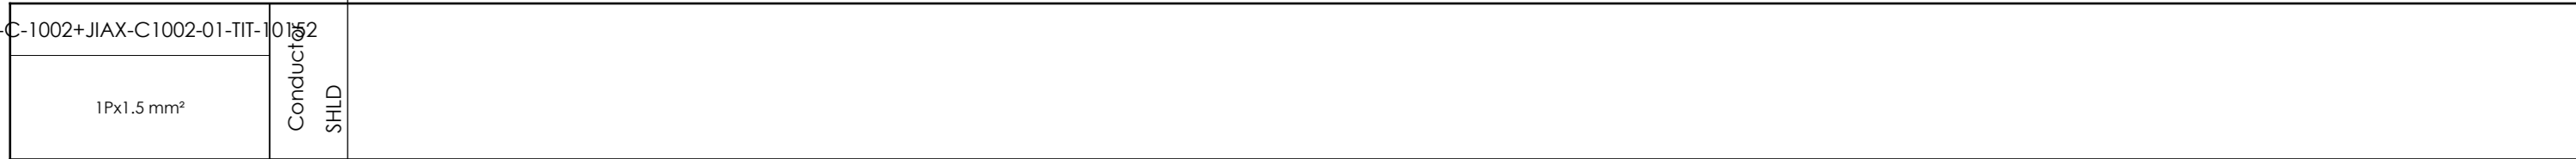

-X2

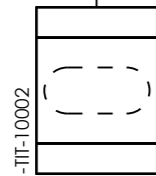

External targets



CLIENT DWG NO.	BU-20-VD-303-IN-DIG-0043
EQUIPMENT NO.	20-C-1002
EQUIPMENT LOCATION	Iran, Onshore


THIS DRAWING IS OWNED BY AIRPACK, AND SHALL NOT BE PRINTED OR COPIED IN ANY OTHER WAY THAN WITH AIRPACKS PERMISSION!

SUBJECT		Cable-connection diagram =20-C-1002+JIAX-C1002-01-TIT-10152	
ADAPTED TO P&ID REVISION	05	CLIENT	Bushehr Petrochemical Company (BUPC)
CLIENT REF.	Bushehr MEG Plant Project	AIRPACK REF.	17811-30A



DRAWN BY	MaGo
CHECKED BY	RBE
LAST MODIFICATION DATE	
AIRPACK DWG NO.	17811-05
REVISION	01
TOTAL PAGE AMOUNT	25

=
+
CURRENT PAGE

Internal targets

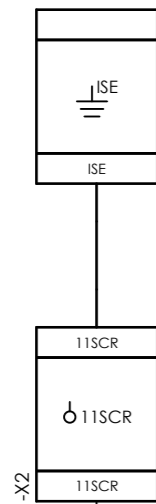

-X2

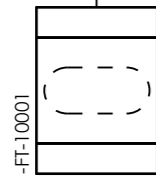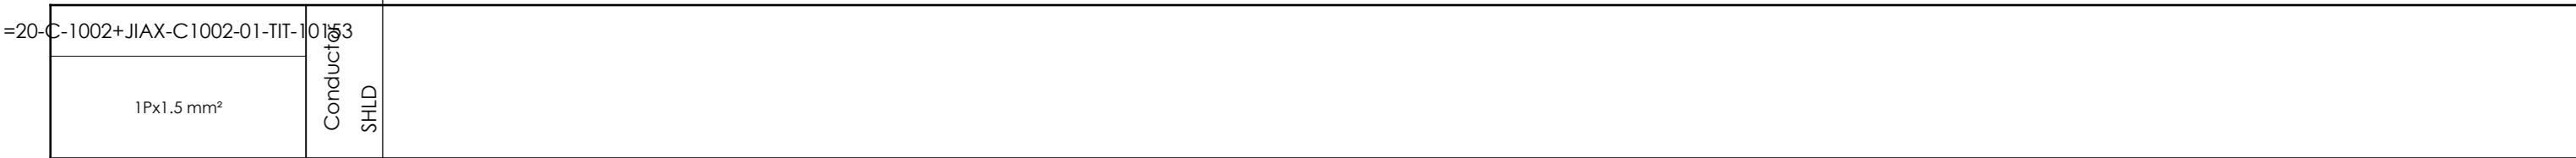

External targets



CLIENT DWG NO.	BU-20-VD-303-IN-DIG-0043
EQUIPMENT NO.	20-C-1002
EQUIPMENT LOCATION	Iran, Onshore



THIS DRAWING IS OWNED BY AIRPACK, AND SHALL NOT BE PRINTED OR COPIED IN ANY OTHER WAY THAN WITH AIRPACKS PERMISSION!

SUBJECT		Cable-connection diagram =20-C-1002+JIAX-C1002-01-TIT-10153	
ADAPTED TO P&ID REVISION	05	CLIENT	Bushehr Petrochemical Company (BUPC)
CLIENT REF.	Bushehr MEG Plant Project	AIRPACK REF.	17811-30A



DRAWN BY	MaGo
CHECKED BY	RBE
LAST MODIFICATION DATE	
AIRPACK DWG NO.	17811-05
REVISION	01
TOTAL PAGE AMOUNT	26

=	
+	
CURRENT PAGE	

 Internal targets

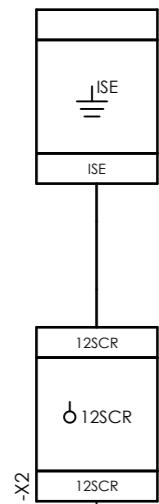

=20-C-1002+JIAX-C1002-01-TIT-10154

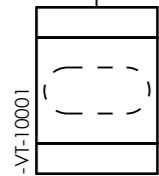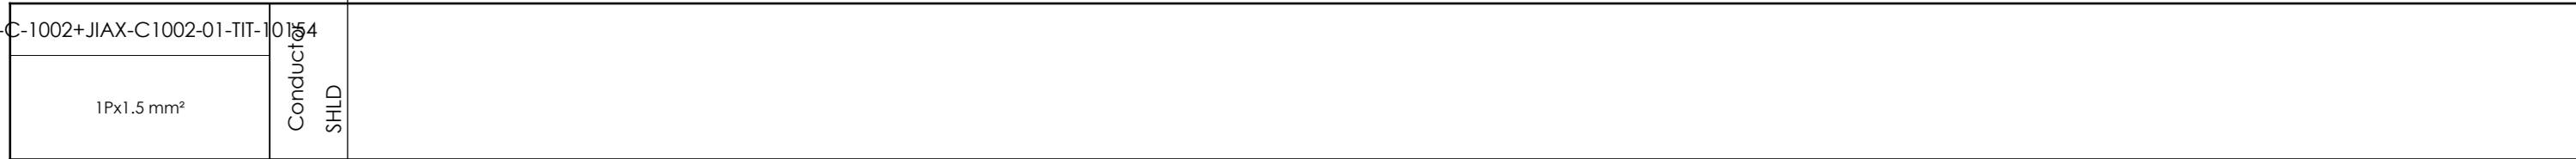

External targets





CLIENT DWG NO.	BU-20-VD-303-IN-DIG-0043
EQUIPMENT NO.	20-C-1002
EQUIPMENT LOCATION	Iran, Onshore
THIS DRAWING IS OWNED BY AIRPACK, AND SHALL NOT BE PRINTED OR COPIED IN ANY OTHER WAY THAN WITH AIRPACKS PERMISSION!	

SUBJECT Cable-connection diagram =20-C-1002+JIAX-C1002-01-TIT-10154	
ADAPTED TO P&ID REVISION	05
CLIENT	Bushehr Petrochemical Company (BUPC)
CLIENT REF.	Bushehr MEG Plant Project
AIRPACK REF.	17811-30A



DRAWN BY	MaGo
CHECKED BY	RBE
LAST MODIFICATION DATE	
AIRPACK DWG NO.	17811-05
REVISION	01
TOTAL PAGE AMOUNT	27

=
+
CURRENT PAGE

 Internal targets

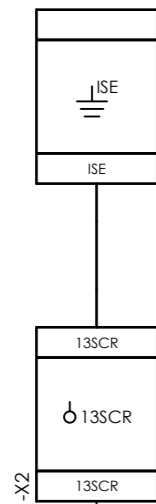

=20-C-1002+JIAX-C1002-01-TIT-10155

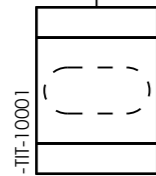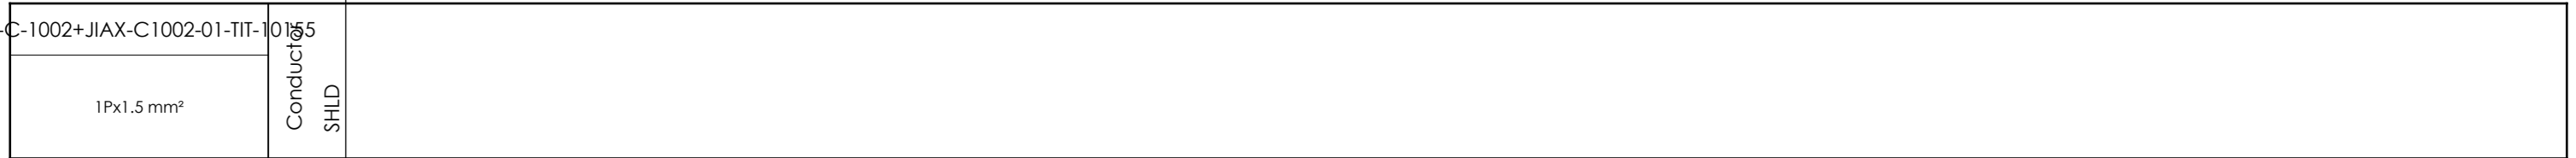

External targets




CLIENT DWG NO.	BU-20-VD-303-IN-DIG-0043
EQUIPMENT NO.	20-C-1002
EQUIPMENT LOCATION	Iran, Onshore
THIS DRAWING IS OWNED BY AIRPACK, AND SHALL NOT BE PRINTED OR COPIED IN ANY OTHER WAY THAN WITH AIRPACKS PERMISSION!	

SUBJECT		Cable-connection diagram =20-C-1002+JIAX-C1002-01-TIT-10155	
ADAPTED TO P&ID REVISION	05	CLIENT	Bushehr Petrochemical Company (BUPC)
CLIENT REF.	Bushehr MEG Plant Project	AIRPACK REF.	17811-30A

DRAWN BY	MaGo
CHECKED BY	RBE
LAST MODIFICATION DATE	
AIRPACK DWG NO.	17811-05
REVISION	01
TOTAL PAGE AMOUNT	28


=
+
CURRENT PAGE

Internal targets

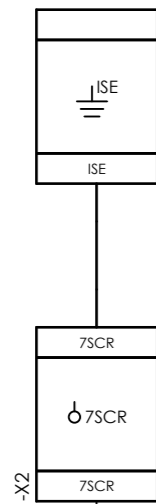


X2

=20-C-1002+JIAX-C1002-01-VT-10151

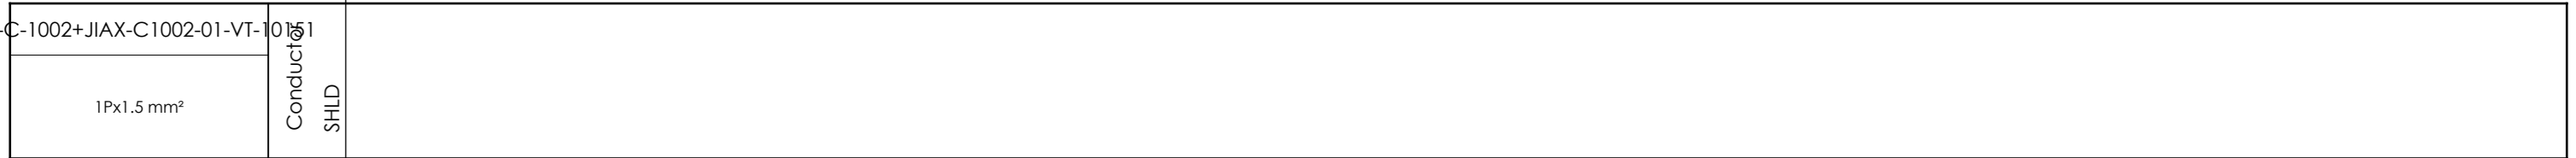

X2

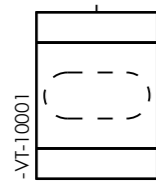

External targets




CLIENT DWG NO.	BU-20-VD-303-IN-DIG-0043
EQUIPMENT NO.	20-C-1002
EQUIPMENT LOCATION	Iran, Onshore
THIS DRAWING IS OWNED BY AIRPACK, AND SHALL NOT BE PRINTED OR COPIED IN ANY OTHER WAY THAN WITH AIRPACKS PERMISSION!	

SUBJECT Cable-connection diagram =20-C-1002+JIAX-C1002-01-VT-10151	
ADAPTED TO P&ID REVISION	05
CLIENT	Bushehr Petrochemical Company (BUPC)
CLIENT REF.	Bushehr MEG Plant Project
AIRPACK REF.	17811-30A


DRAWN BY	MaGo
CHECKED BY	RBE
LAST MODIFICATION DATE	
AIRPACK DWG NO.	17811-05
REVISION	01
TOTAL PAGE AMOUNT	29

=
+
CURRENT PAGE

Internal targets

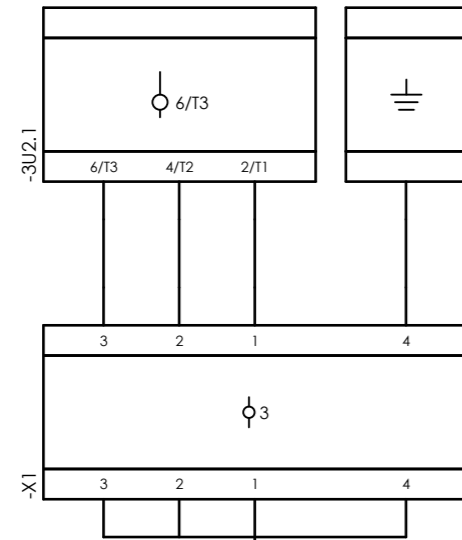


External targets

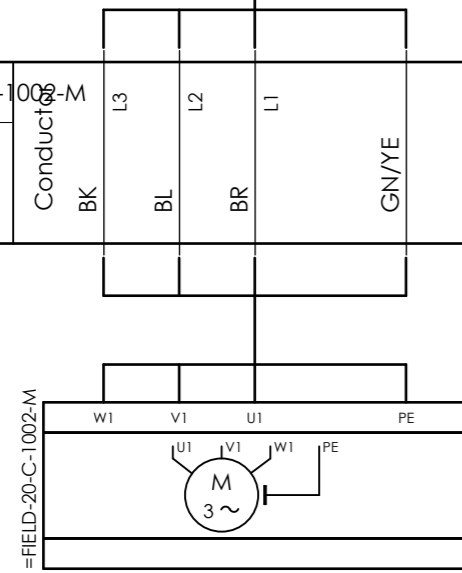


CLIENT DWG NO.	BU-20-VD-303-IN-DIG-0043
EQUIPMENT NO.	20-C-1002
EQUIPMENT LOCATION	Iran, Onshore
THIS DRAWING IS OWNED BY AIRPACK, AND SHALL NOT BE PRINTED OR COPIED IN ANY OTHER WAY THAN WITH AIRPACKS PERMISSION!	

SUBJECT		DRAWN BY	MaGo	=
Cable-connection diagram =20-C-1002+PD-C-1002-01-20-C-1002-M		CHECKED BY	RBE	+
ADAPTED TO P&ID REVISION	05	LAST MODIFICATION DATE		CURRENT PAGE
CLIENT	Bushehr Petrochemical Company (BUPC)	AIRPACK DWG NO.	17811-05	
CLIENT REF.	Bushehr MEG Plant Project	REVISION	01	
AIRPACK REF.	17811-30A	TOTAL PAGE AMOUNT	30	

Internal targets

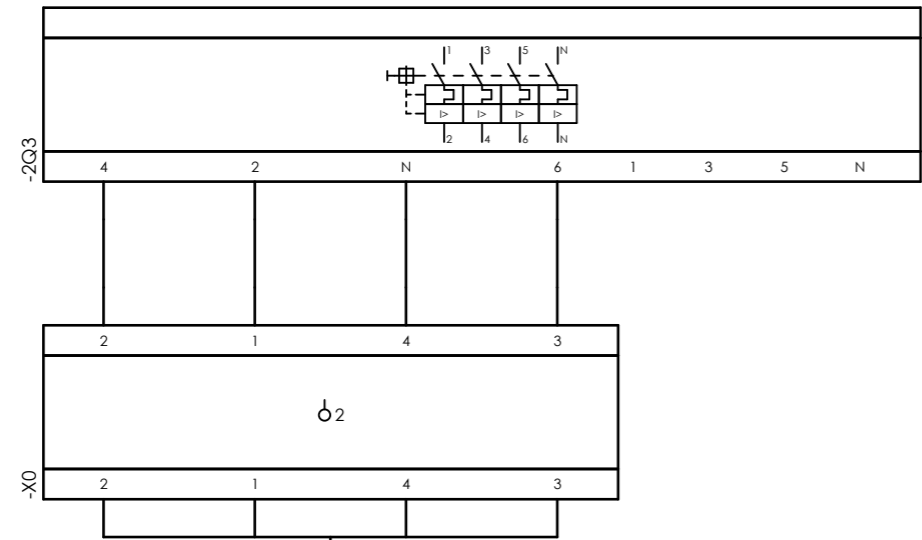

External targets

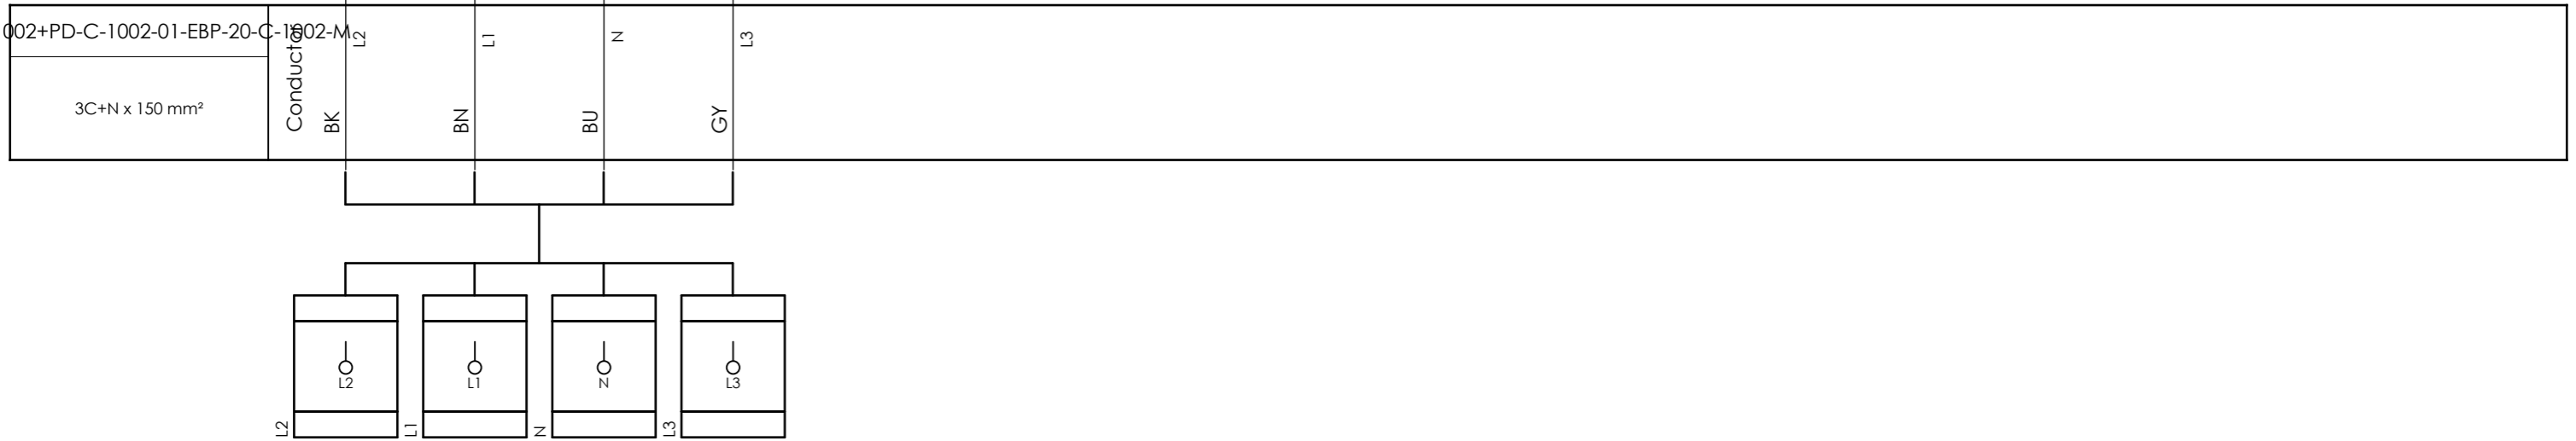


CLIENT DWG NO.	BU-20-VD-303-IN-DIG-0043
EQUIPMENT NO.	20-C-1002
EQUIPMENT LOCATION	Iran, Onshore
THIS DRAWING IS OWNED BY AIRPACK, AND SHALL NOT BE PRINTED OR COPIED IN ANY OTHER WAY THAN WITH AIRPACKS PERMISSION!	


SUBJECT		Cable-connection diagram =20-C-1002+PD-C-1002-01-EBP-20-C-1002-M	
ADAPTED TO P&ID REVISION	05	CLIENT	Bushehr Petrochemical Company (BUPC)
CLIENT REF.	Bushehr MEG Plant Project	AIRPACK REF.	17811-30A

DRAWN BY	MaGo	=
CHECKED BY	RBE	+
LAST MODIFICATION DATE		CURRENT PAGE
AIRPACK DWG NO.	17811-05	
REVISION	01	
TOTAL PAGE AMOUNT	31	


Internal targets

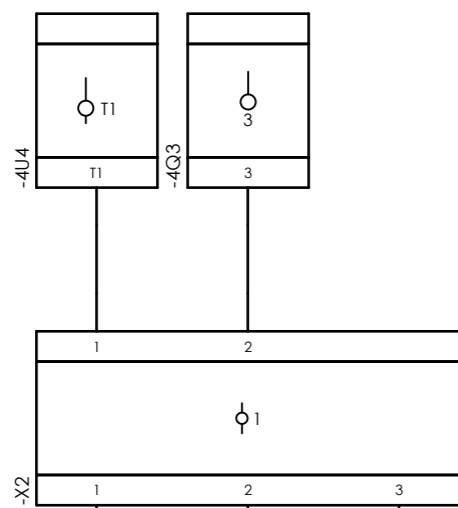

=20-C-1002+PD-C-1002-01-LG-10151

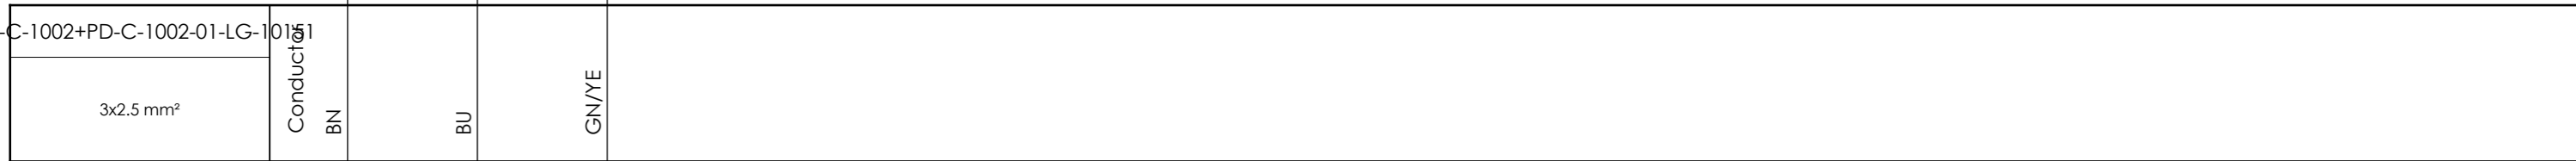


External targets

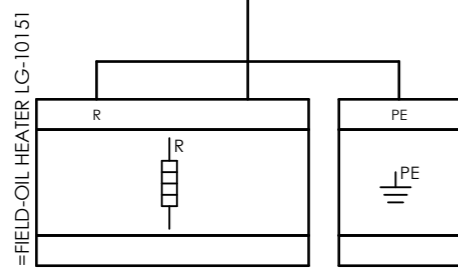

CLIENT DWG NO.	BU-20-VD-303-IN-DIG-0043
EQUIPMENT NO.	20-C-1002
EQUIPMENT LOCATION	Iran, Onshore
THIS DRAWING IS OWNED BY AIRPACK, AND SHALL NOT BE PRINTED OR COPIED IN ANY OTHER WAY THAN WITH AIRPACKS PERMISSION!	

SUBJECT		Cable-connection diagram =20-C-1002+PD-C-1002-01-LG-10151	
ADAPTED TO P&ID REVISION	05	CLIENT	Bushehr Petrochemical Company (BUPC)
CLIENT REF.	Bushehr MEG Plant Project	AIRPACK REF.	17811-30A

DRAWN BY	MaGo	=
CHECKED BY	RBE	+
LAST MODIFICATION DATE		CURRENT PAGE
AIRPACK DWG NO.	17811-05	
REVISION	01	
TOTAL PAGE AMOUNT	32	

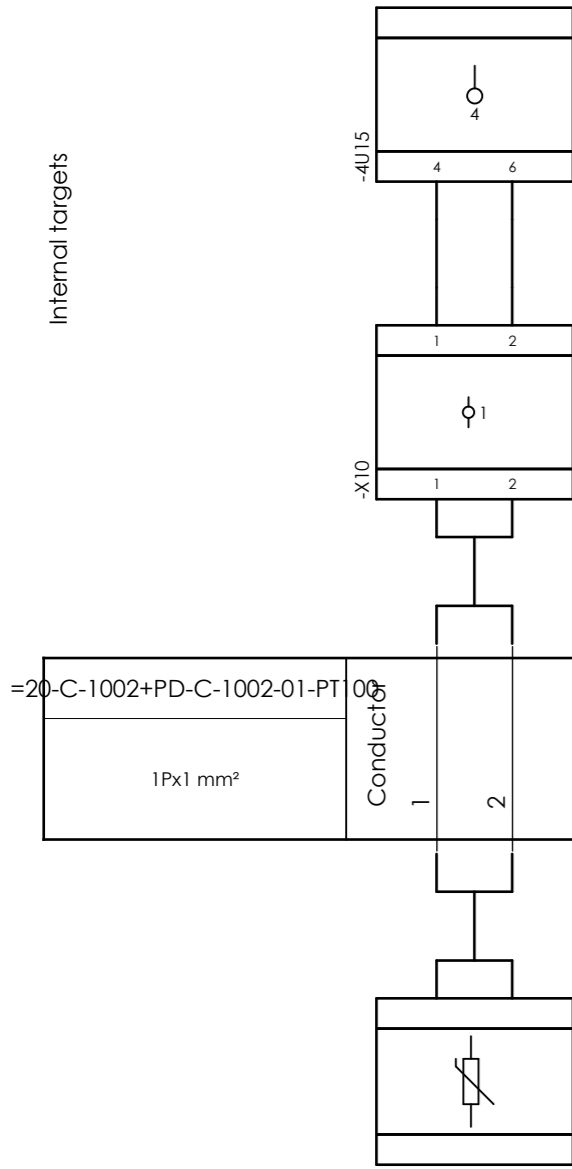

=20-C-1002+PD-C-1002-01-PT100
 1Px1 mm²
 Conductors
 1 2



CLIENT DWG NO.	BU-20-VD-303-IN-DIG-0043
EQUIPMENT NO.	20-C-1002
EQUIPMENT LOCATION	Iran, Onshore
THIS DRAWING IS OWNED BY AIRPACK, AND SHALL NOT BE PRINTED OR COPIED IN ANY OTHER WAY THAN WITH AIRPACKS PERMISSION!	

SUBJECT		Cable-connection diagram =20-C-1002+PD-C-1002-01-PT100	
ADAPTED TO P&ID REVISION	05	CLIENT	Bushehr Petrochemical Company (BUPC)
AIRPACK REF.	17811-30A	CLIENT REF.	Bushehr MEG Plant Project

DRAWN BY	MaGo	=
CHECKED BY	RBE	+
LAST MODIFICATION DATE		CURRENT PAGE
AIRPACK DWG NO.	17811-05	
REVISION	01	
TOTAL PAGE AMOUNT	33	