





OWNER:  شرکت سست و سوهی آوند ایرانیان (سهایی نغصی)	BUSHEHR PETROCHEMICAL COMPANY MEG PLANT						EPC CONTRACTOR:  Chagalesh-Enerchimi-Steam Joint Venture BUPC-MEG PLANT PROJECT		
MC : 	LOOP DIAGRAM FOR EMERGENCY INSTRUMENT AIR COMPRESSOR								
Owner Document Number: 17811-30B							Project BU	Area 20	Phase VD
								Rev.: 02	Page 1 of 24

LOOP DIAGRAM FOR EMERGENCY INSTRUMENT AIR COMPRESSOR

02	05/09/2022	Approved for Construction	RT	KP	JR	
01	15/07/2022	For approval	MG	RB	KP	
00	18/10/2021	For approval	HT	KP	JR	
Rev.	Date	Purpose of Issue	Prepared	Checked	Approved	AC Code
					Class: 1	Phase: P



Airpack B.V.

4301 RN Zierikzee
The Netherlands

PHONE: (31) (0) 111 - 415455

FAX: (31) (0) 111 - 413338

E-MAIL : AIRPACK@AIRPACK.NL

WEBPAGE : WWW.AIRPACK.NL

Client	:	Bushehr Petrochemical Company (BUPC)		
Equipment location	:	Iran, Onshore		
Client reference	:	Bushehr MEG Plant Project		
Client dwg. no.	:	BU-20-VD-303-IN-DIG-0093		
Airpack reference	:	17811-30B		
Airpack dwg. no.	:	17811-30B		
Generation date	:	30-Jun-21		
E & I manager	:	RBE	Revision no.	: 02
Last modifications	:	24-Aug-22		
Last modifications by	:	RTR		




CLIENT DWG NO.	BU-20-VD-303-IN-DIG-0093
EQUIPMENT NO.	20-C-7080
EQUIPMENT LOCATION	Iran, Onshore
THIS DRAWING IS OWNED BY AIRPACK, AND SHALL NOT BE PRINTED OR COPIED IN ANY OTHER WAY THAN WITH AIRPACKS PERMISSION!	


SUBJECT Title page / cover sheet	
ADAPTED TO P&ID REVISION	03
CLIENT	Bushehr Petrochemical Company (BUPC)
CLIENT REF.	Bushehr MEG Plant Project
AIRPACK REF.	17811-30B

DRAWN BY	RTR	=
CHECKED BY	RBE	+
LAST MODIFICATION DATE		CURRENT PAGE
AIRPACK DWG NO.	17811-30B	
REVISION	02	
TOTAL PAGE AMOUNT	1	


Internal targets

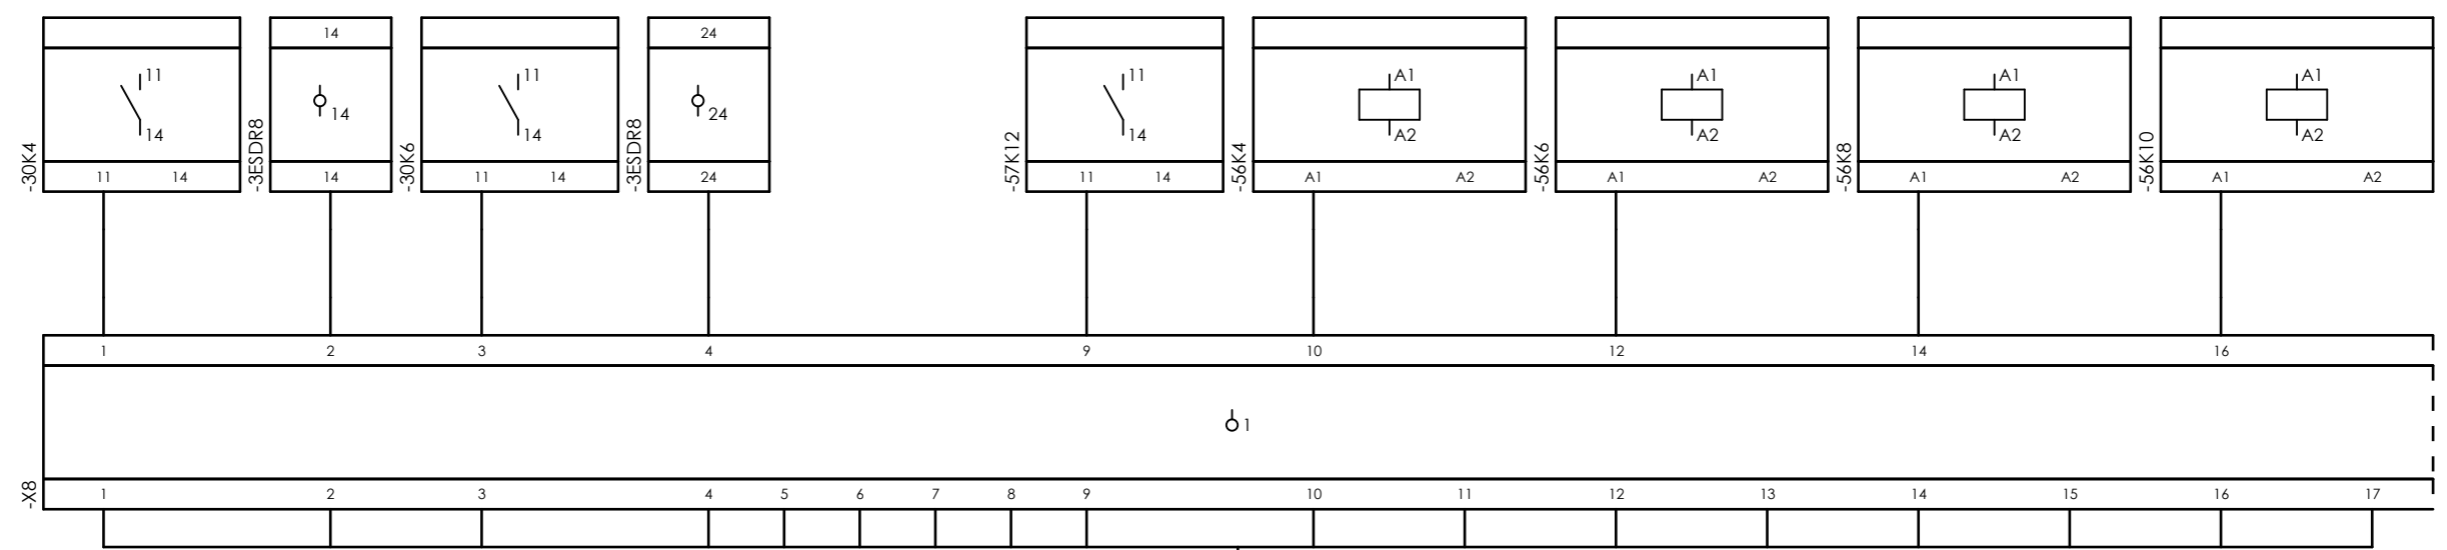

=20-C-7080+UCP-C7080-01-DB_COMB

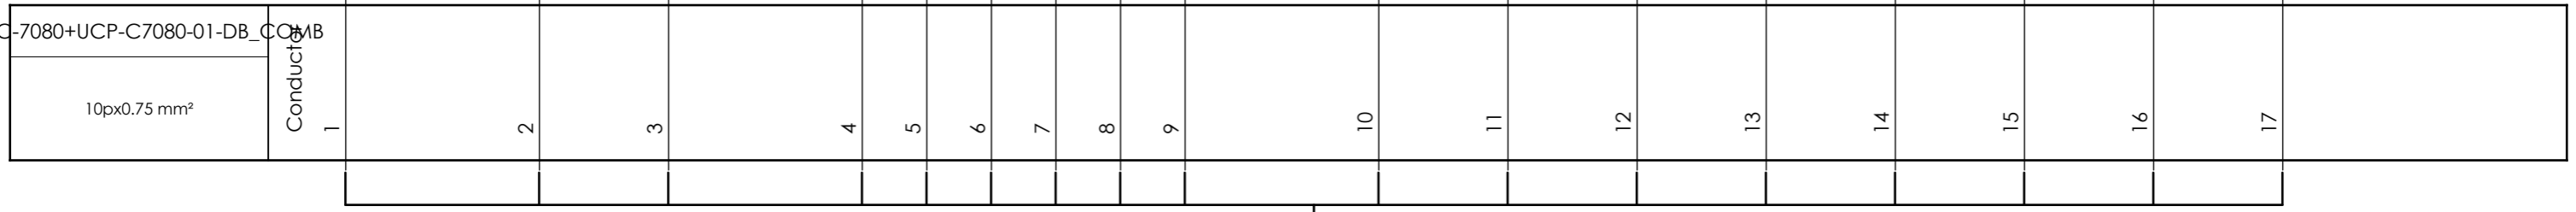

External targets




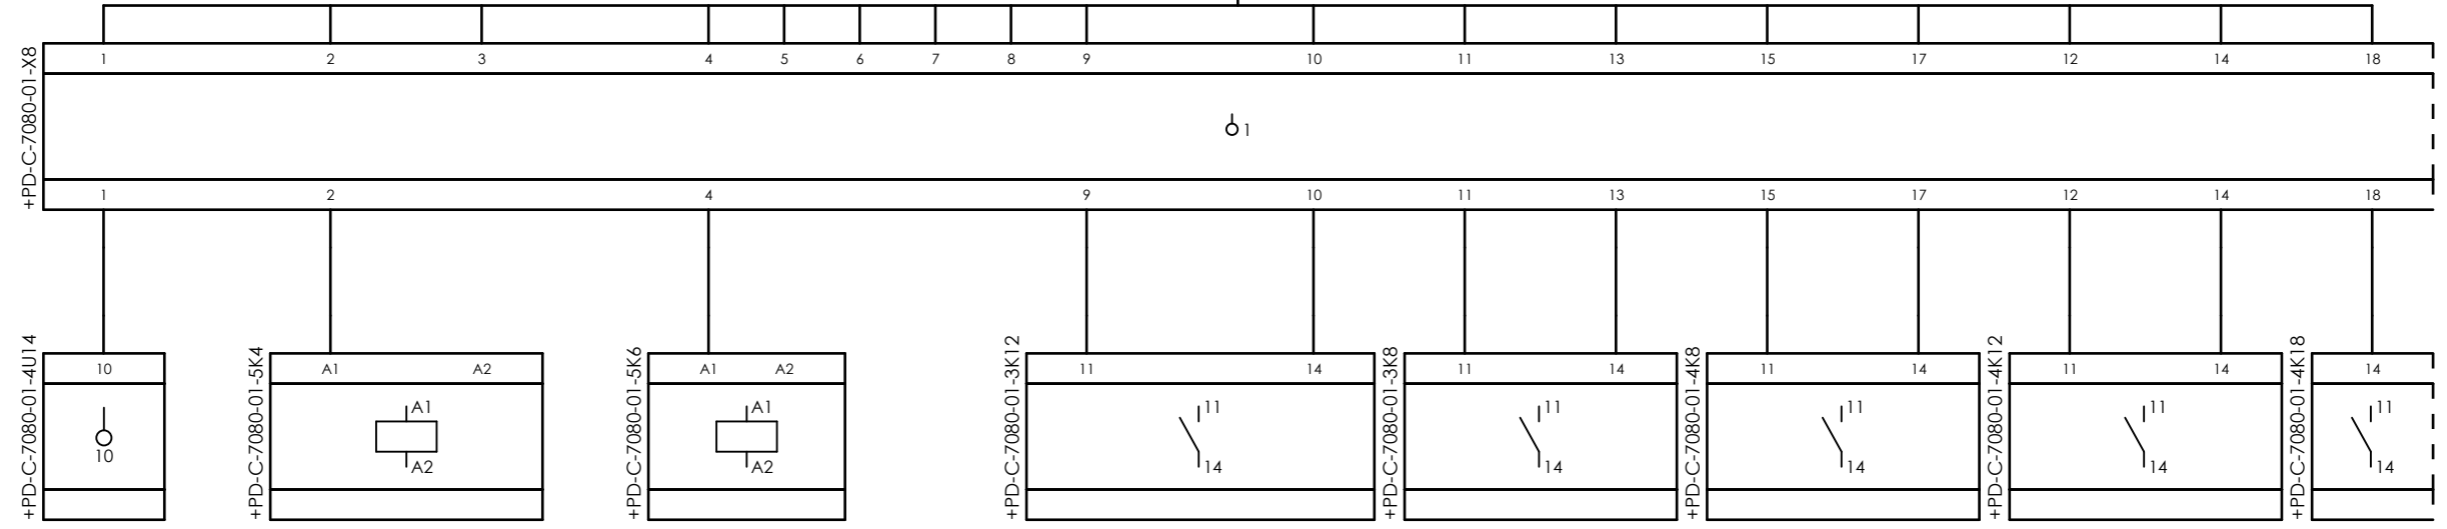


CLIENT DWG NO.	BU-20-VD-303-IN-DIG-0093
EQUIPMENT NO.	20-C-7080
EQUIPMENT LOCATION	Iran, Onshore
THIS DRAWING IS OWNED BY AIRPACK, AND SHALL NOT BE PRINTED OR COPIED IN ANY OTHER WAY THAN WITH AIRPACKS PERMISSION!	

SUBJECT		Cable-connection diagram =20-C-7080+UCP-C7080-01-DB_COMB	
ADAPTED TO P&ID REVISION	03		
CLIENT	Bushehr Petrochemical Company (BUPC)		
CLIENT REF.	Bushehr MEG Plant Project		
AIRPACK REF.	17811-30B		

DRAWN BY	RTR	=
CHECKED BY	RBE	+
LAST MODIFICATION DATE		CURRENT PAGE
AIRPACK DWG NO.	17811-30B	
REVISION	02	
TOTAL PAGE AMOUNT	2	

Internal targets

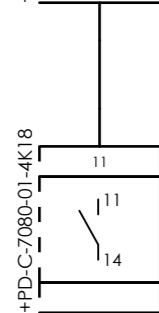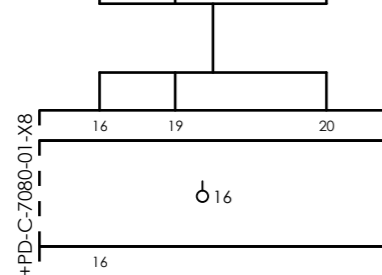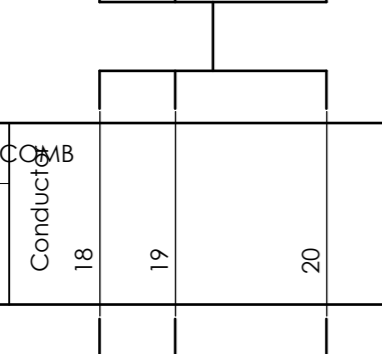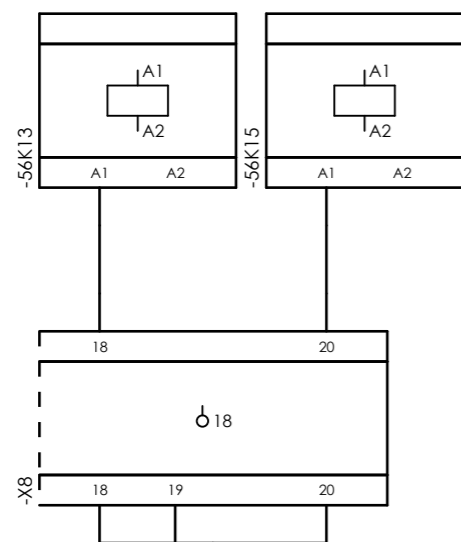

External targets




CLIENT DWG NO.	BU-20-VD-303-IN-DIG-0093
EQUIPMENT NO.	20-C-7080
EQUIPMENT LOCATION	Iran, Onshore
THIS DRAWING IS OWNED BY AIRPACK, AND SHALL NOT BE PRINTED OR COPIED IN ANY OTHER WAY THAN WITH AIRPACKS PERMISSION!	


SUBJECT Cable-connection diagram =20-C-7080+UCP-C7080-01-DB_COMB	
ADAPTED TO P&ID REVISION	03
CLIENT	Bushehr Petrochemical Company (BUPC)
CLIENT REF.	Bushehr MEG Plant Project
AIRPACK REF.	17811-30B

DRAWN BY	RTR	=
CHECKED BY	RBE	+
LAST MODIFICATION DATE		CURRENT PAGE
AIRPACK DWG NO.	17811-30B	
REVISION	02	
TOTAL PAGE AMOUNT	3	


Internal targets

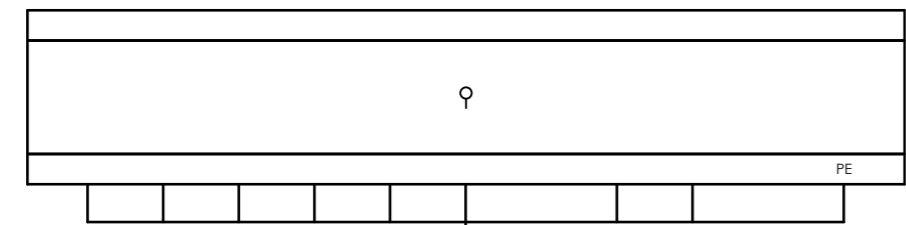

=20-C-7080+UCP-C7080-01-ESD

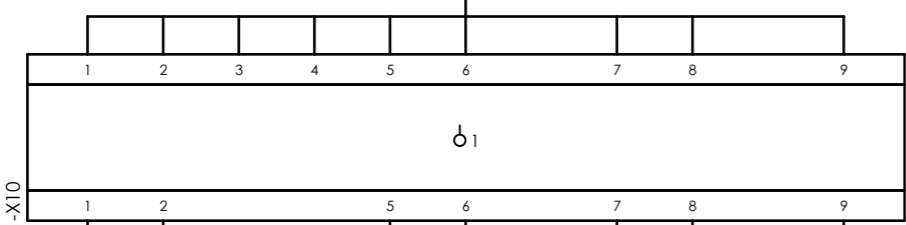

External targets

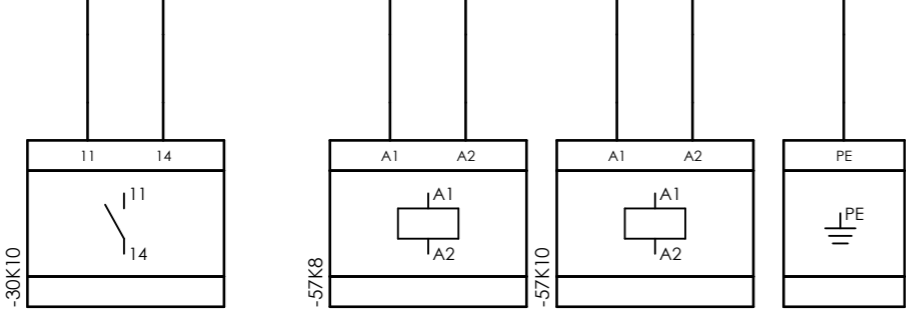


CLIENT DWG NO. BU-20-VD-303-IN-DIG-0093
 EQUIPMENT NO. 20-C-7080
 EQUIPMENT LOCATION Iran, Onshore
 THIS DRAWING IS OWNED BY AIRPACK, AND SHALL NOT BE PRINTED OR COPIED IN ANY OTHER WAY THAN WITH AIRPACKS PERMISSION!

SUBJECT Cable-connection diagram =20-C-7080+UCP-C7080-01-ESD
 ADAPTED TO P&ID REVISION 03
 CLIENT Bushehr Petrochemical Company (BUPC)
 CLIENT REF. Bushehr MEG Plant Project
 AIRPACK REF. 17811-30B

DRAWN BY RTR
 CHECKED BY RBE
 LAST MODIFICATION DATE
 AIRPACK DWG NO. 17811-30B
 REVISION 02
 TOTAL PAGE AMOUNT 4

=
 +
 CURRENT PAGE


Internal targets

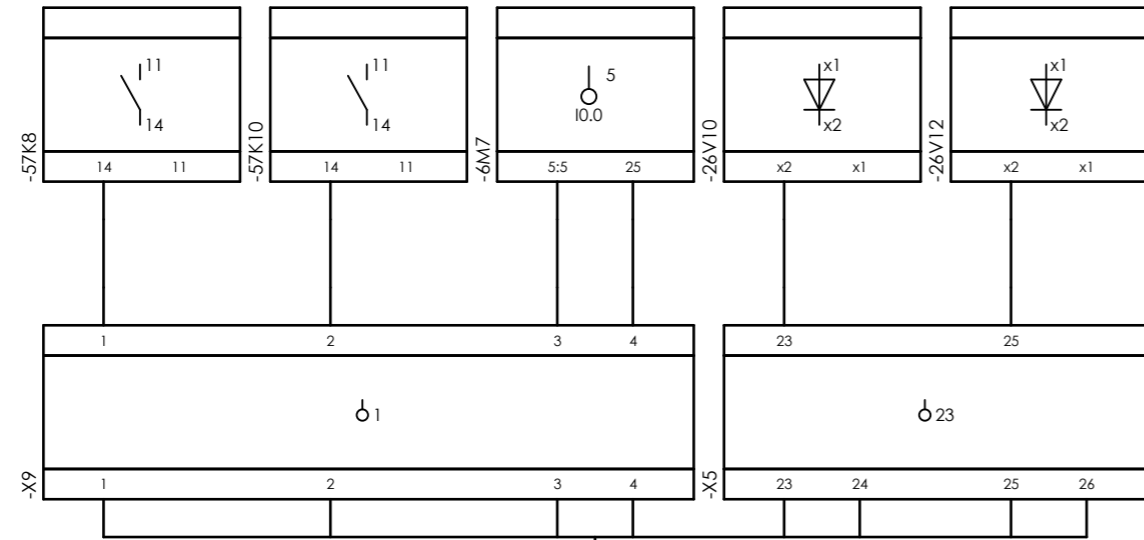

=20-C-7080+UCP-C7080-01-ESD_LCP_B



External targets

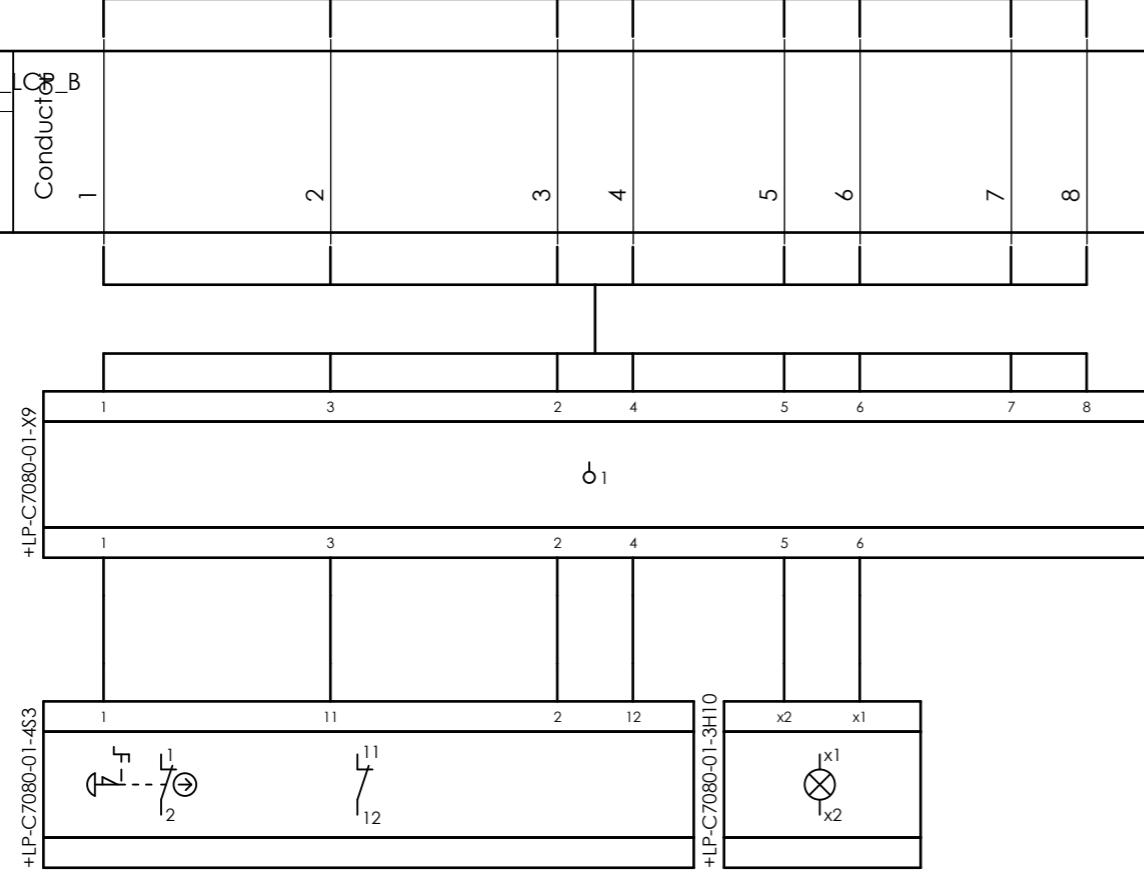


CLIENT DWG NO. BU-20-VD-303-IN-DIG-0093
 EQUIPMENT NO. 20-C-7080
 EQUIPMENT LOCATION Iran, Onshore
 THIS DRAWING IS OWNED BY AIRPACK, AND SHALL NOT BE PRINTED OR COPIED IN ANY OTHER WAY THAN WITH AIRPACKS PERMISSION!

SUBJECT Cable-connection diagram =20-C-7080+UCP-C7080-01-ESD_LCP_B
 ADAPTED TO P&ID REVISION 03
 CLIENT Bushehr Petrochemical Company (BUPC)
 CLIENT REF. Bushehr MEG Plant Project
 AIRPACK REF. 17811-30B




DRAWN BY RTR
 CHECKED BY RBE
 LAST MODIFICATION DATE
 AIRPACK DWG NO. 17811-30B
 REVISION 02
 TOTAL PAGE AMOUNT 5

=
 +
 CURRENT PAGE
 5

Internal targets

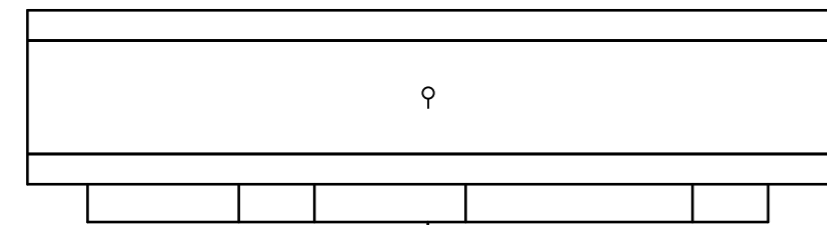

=20-C-7080+UCP-C7080-01-FCS
10Px0,75 mm²
Conductors

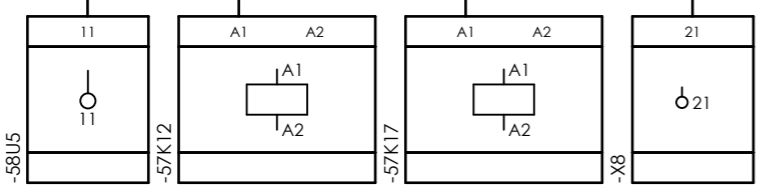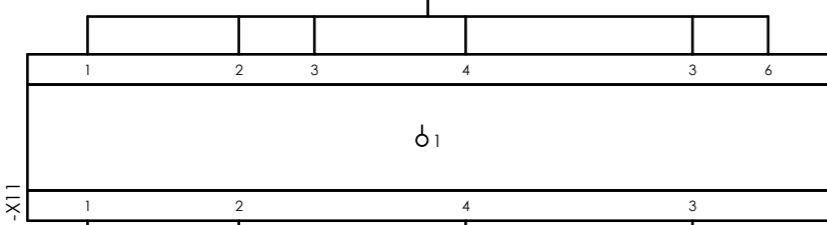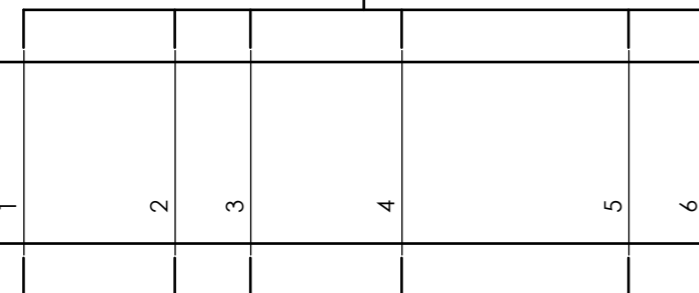

External targets




CLIENT DWG NO. BU-20-VD-303-IN-DIG-0093
EQUIPMENT NO. 20-C-7080
EQUIPMENT LOCATION Iran, Onshore
THIS DRAWING IS OWNED BY AIRPACK, AND SHALL NOT BE PRINTED OR COPIED IN ANY OTHER WAY THAN WITH AIRPACKS PERMISSION!

SUBJECT Cable-connection diagram =20-C-7080+UCP-C7080-01-FCS
ADAPTED TO P&ID REVISION 03
CLIENT Bushehr Petrochemical Company (BUPC)
CLIENT REF. Bushehr MEG Plant Project
AIRPACK REF. 17811-30B


DRAWN BY RTR
CHECKED BY RBE
LAST MODIFICATION DATE
AIRPACK DWG NO. 17811-30B
REVISION 02
TOTAL PAGE AMOUNT 6

=
+
CURRENT PAGE

Internal targets

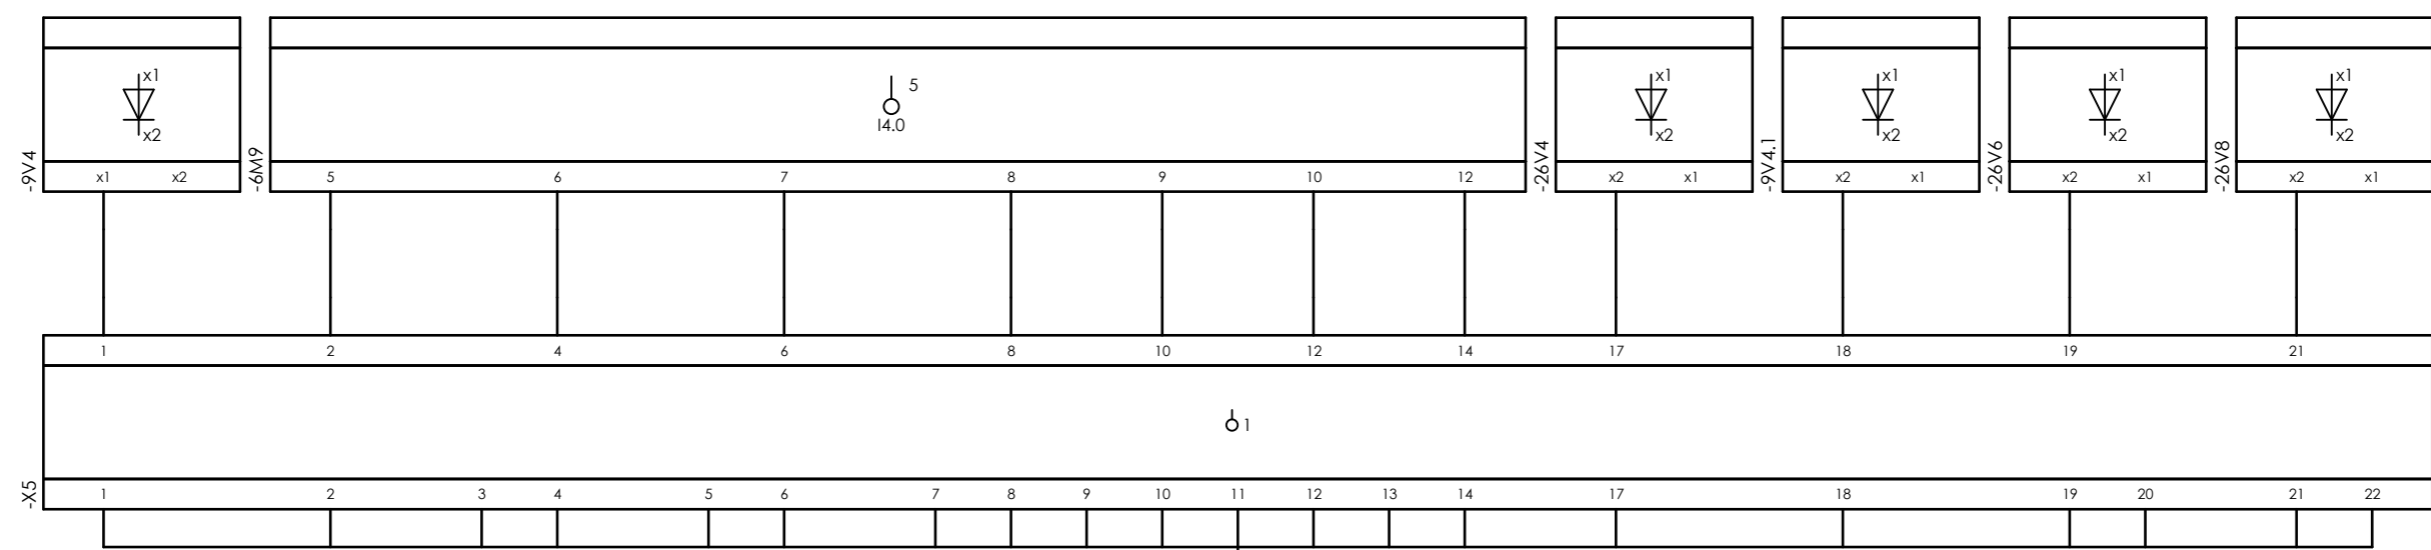

External targets

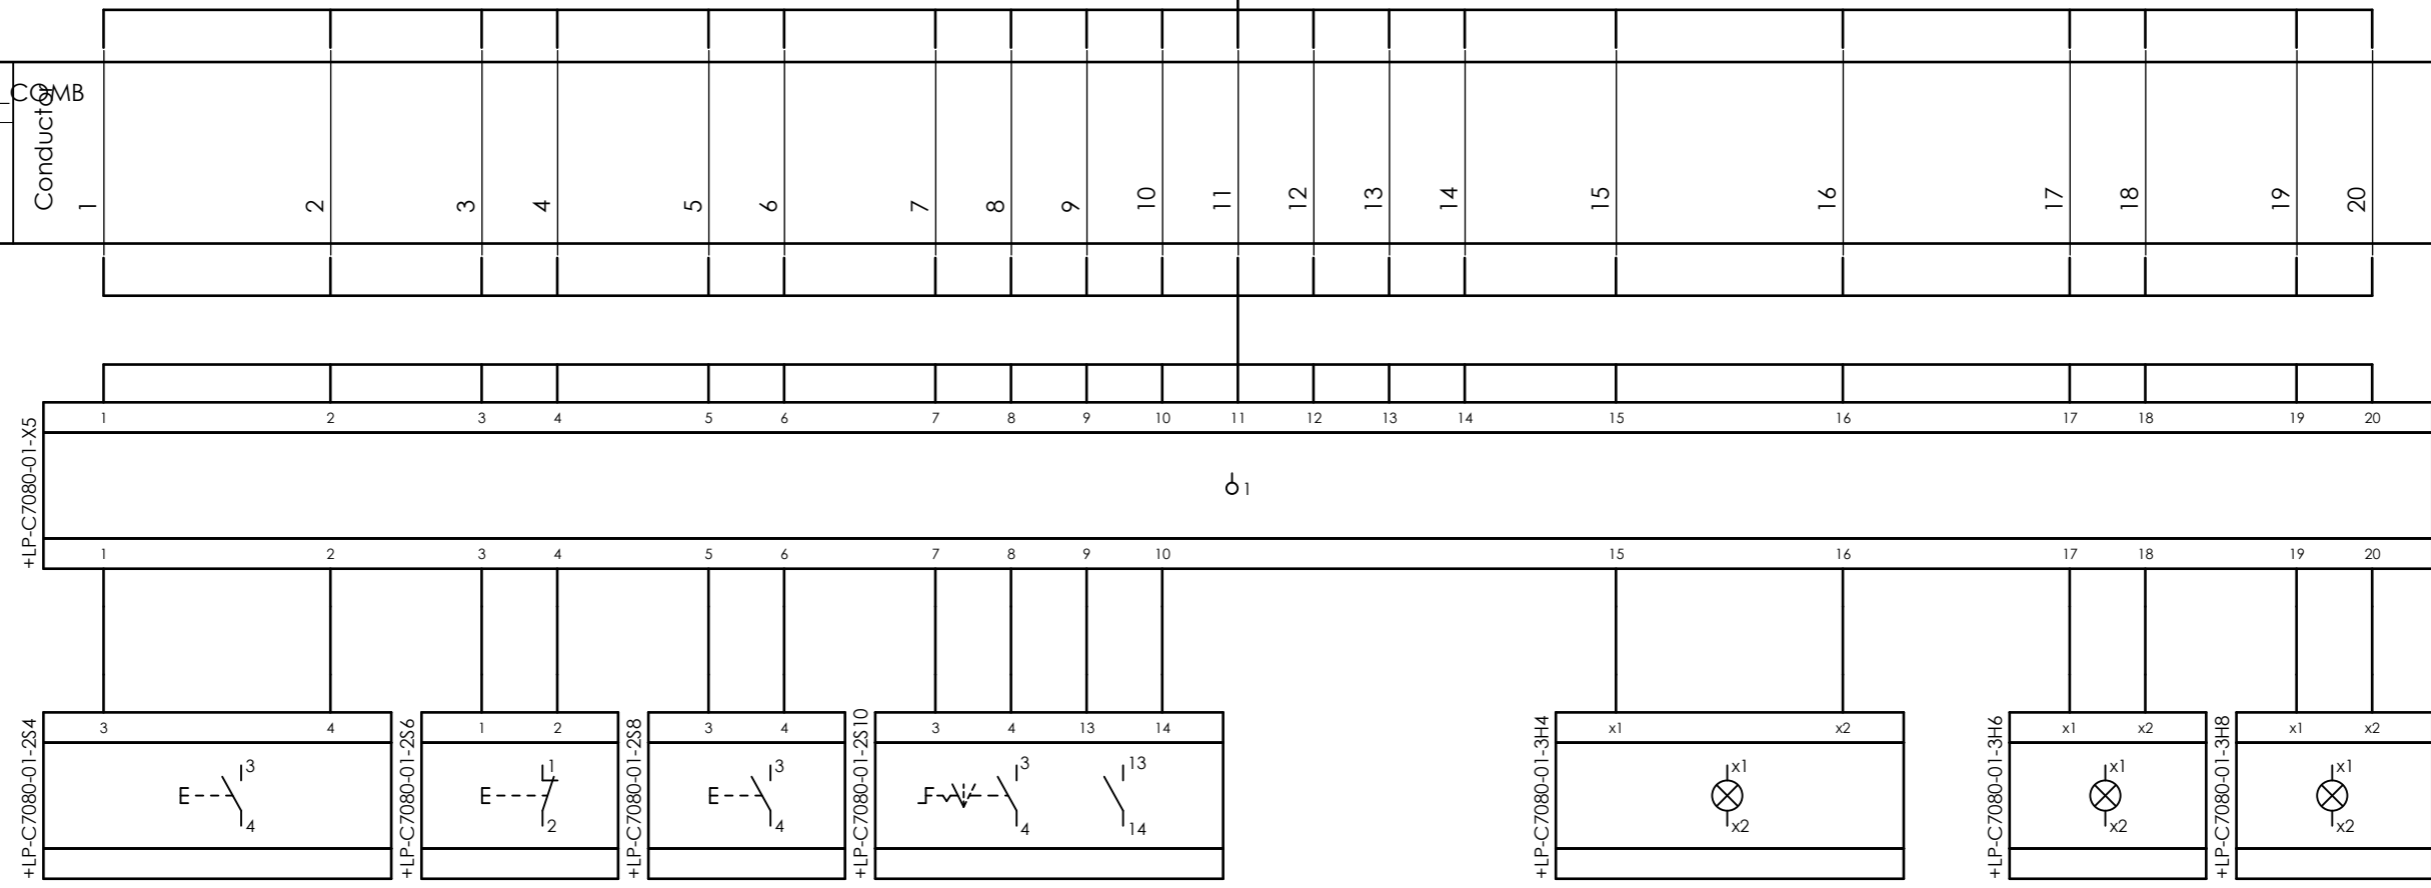

=20-C-7080+UCP-C7080-01-LCP_COMB
 Conductors
 10px0,75 mm²




CLIENT DWG NO. BU-20-VD-303-IN-DIG-0093
 EQUIPMENT NO. 20-C-7080
 EQUIPMENT LOCATION Iran, Onshore
 THIS DRAWING IS OWNED BY AIRPACK, AND SHALL NOT BE PRINTED OR COPIED IN ANY OTHER WAY THAN WITH AIRPACKS PERMISSION!

SUBJECT Cable-connection diagram =20-C-7080+UCP-C7080-01-LCP_COMB
 ADAPTED TO P&ID REVISION 03
 CLIENT Bushehr Petrochemical Company (BUPC)
 CLIENT REF. Bushehr MEG Plant Project
 AIRPACK REF. 17811-30B


DRAWN BY RTR
 CHECKED BY RBE
 LAST MODIFICATION DATE
 AIRPACK DWG NO. 17811-30B
 REVISION 02
 TOTAL PAGE AMOUNT 7

=
 +
 CURRENT PAGE
 7


Internal targets

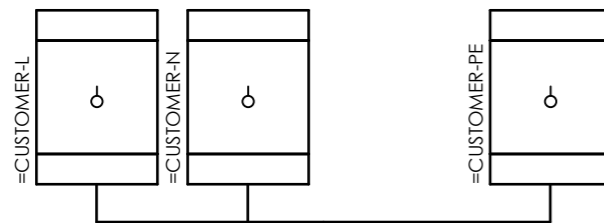

=20-C-7080+UCP-C7080-01-PS_00
3x2.5 sqmm

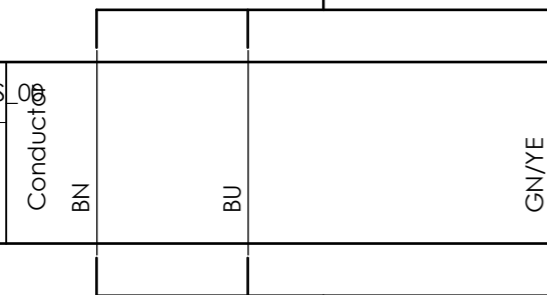

External targets

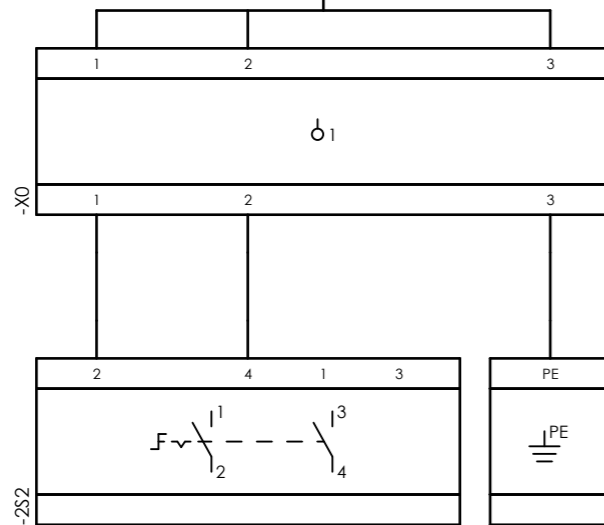


CLIENT DWG NO.	BU-20-VD-303-IN-DIG-0093
EQUIPMENT NO.	20-C-7080
EQUIPMENT LOCATION	Iran, Onshore
THIS DRAWING IS OWNED BY AIRPACK, AND SHALL NOT BE PRINTED OR COPIED IN ANY OTHER WAY THAN WITH AIRPACKS PERMISSION!	

SUBJECT		Cable-connection diagram =20-C-7080+UCP-C7080-01-PS_00	
ADAPTED TO P&ID REVISION	03	CLIENT	Bushehr Petrochemical Company (BUPC)
CLIENT REF.	Bushehr MEG Plant Project	AIRPACK REF.	17811-30B

DRAWN BY	RTR	=
CHECKED BY	RBE	+
LAST MODIFICATION DATE		CURRENT PAGE
AIRPACK DWG NO.	17811-30B	
REVISION	02	
TOTAL PAGE AMOUNT	8	


Internal targets

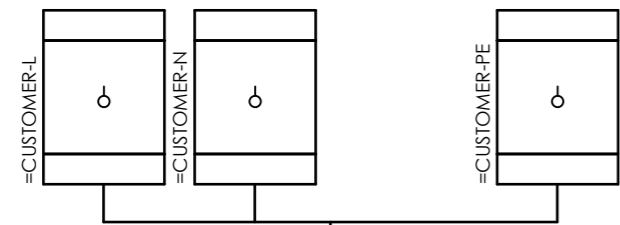

=20-C-7080+UCP-C7080-01-PS_01




External targets

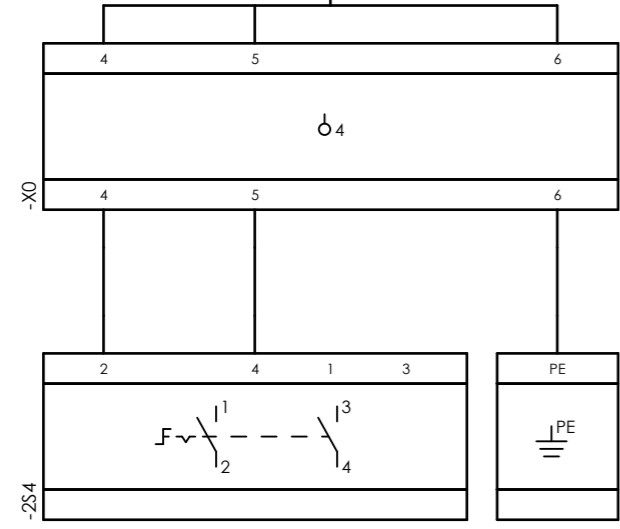


CLIENT DWG NO.	BU-20-VD-303-IN-DIG-0093
EQUIPMENT NO.	20-C-7080
EQUIPMENT LOCATION	Iran, Onshore
THIS DRAWING IS OWNED BY AIRPACK, AND SHALL NOT BE PRINTED OR COPIED IN ANY OTHER WAY THAN WITH AIRPACKS PERMISSION!	

SUBJECT		DRAWN BY	RTR	=
Cable-connection diagram =20-C-7080+UCP-C7080-01-PS_01		CHECKED BY	RBE	+
ADAPTED TO P&ID REVISION	03	LAST MODIFICATION DATE		CURRENT PAGE
CLIENT	Bushehr Petrochemical Company (BUPC)	AIRPACK DWG NO.	17811-30B	
CLIENT REF.	Bushehr MEG Plant Project	REVISION	02	
AIRPACK REF.	17811-30B	TOTAL PAGE AMOUNT	9	


Internal targets

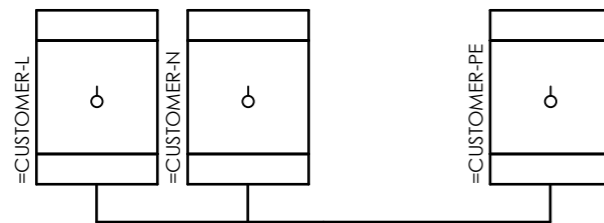

=20-C-7080+UCP-C7080-01-PS_02
3x2.5 sqmm

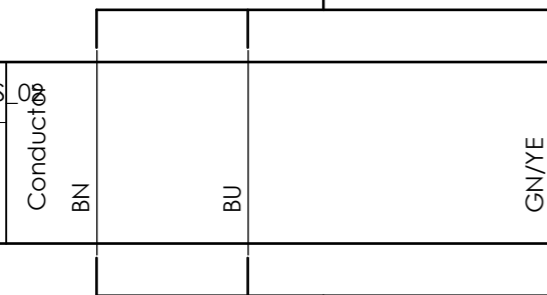

External targets


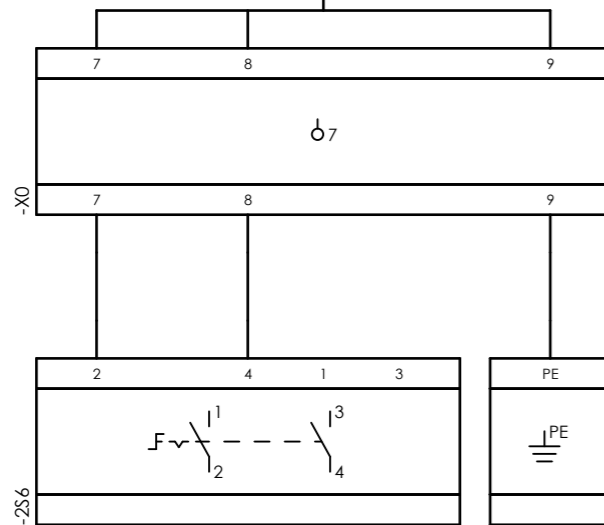


CLIENT DWG NO.	BU-20-VD-303-IN-DIG-0093
EQUIPMENT NO.	20-C-7080
EQUIPMENT LOCATION	Iran, Onshore
THIS DRAWING IS OWNED BY AIRPACK, AND SHALL NOT BE PRINTED OR COPIED IN ANY OTHER WAY THAN WITH AIRPACKS PERMISSION!	


SUBJECT		Cable-connection diagram =20-C-7080+UCP-C7080-01-PS_02	
ADAPTED TO P&ID REVISION	03	CLIENT	Bushehr Petrochemical Company (BUPC)
CLIENT REF.	Bushehr MEG Plant Project	AIRPACK REF.	17811-30B

DRAWN BY	RTR	=
CHECKED BY	RBE	+
LAST MODIFICATION DATE		CURRENT PAGE
AIRPACK DWG NO.	17811-30B	
REVISION	02	
TOTAL PAGE AMOUNT	10	

Internal targets

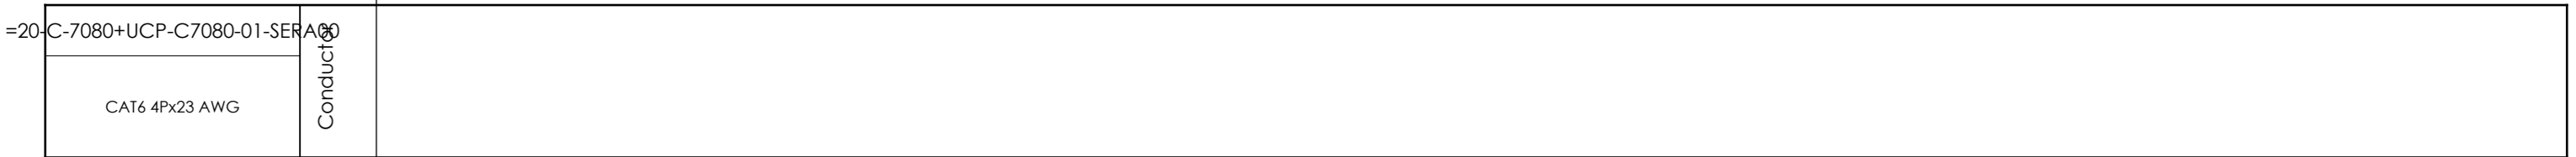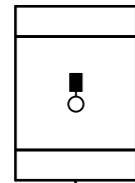

External targets


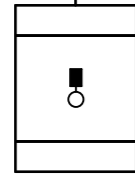


CLIENT DWG NO.	BU-20-VD-303-IN-DIG-0093
EQUIPMENT NO.	20-C-7080
EQUIPMENT LOCATION	Iran, Onshore
THIS DRAWING IS OWNED BY AIRPACK, AND SHALL NOT BE PRINTED OR COPIED IN ANY OTHER WAY THAN WITH AIRPACKS PERMISSION!	


SUBJECT Cable-connection diagram =20-C-7080+UCP-C7080-01-SERA00	
ADAPTED TO P&ID REVISION	03
CLIENT	Bushehr Petrochemical Company (BUPC)
CLIENT REF.	Bushehr MEG Plant Project
AIRPACK REF.	17811-30B

DRAWN BY	RTR	=
CHECKED BY	RBE	+
LAST MODIFICATION DATE		CURRENT PAGE
AIRPACK DWG NO.	17811-30B	
REVISION	02	
TOTAL PAGE AMOUNT	11	

Internal targets

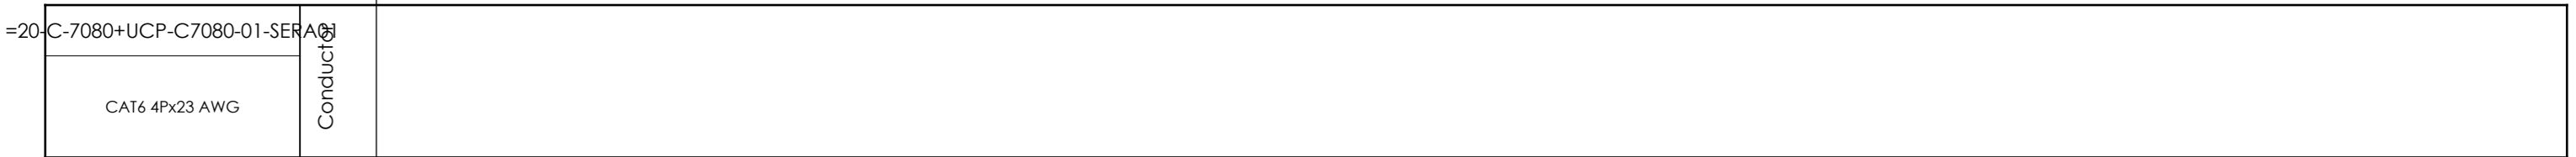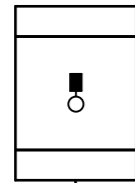

External targets

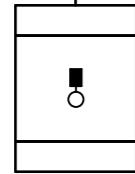


CLIENT DWG NO.	BU-20-VD-303-IN-DIG-0093
EQUIPMENT NO.	20-C-7080
EQUIPMENT LOCATION	Iran, Onshore
THIS DRAWING IS OWNED BY AIRPACK, AND SHALL NOT BE PRINTED OR COPIED IN ANY OTHER WAY THAN WITH AIRPACKS PERMISSION!	

SUBJECT Cable-connection diagram =20-C-7080+UCP-C7080-01-SERA01	
ADAPTED TO P&ID REVISION	03
CLIENT	Bushehr Petrochemical Company (BUPC)
CLIENT REF.	Bushehr MEG Plant Project
AIRPACK REF.	17811-30B


DRAWN BY	RTR
CHECKED BY	RBE
LAST MODIFICATION DATE	
AIRPACK DWG NO.	17811-30B
REVISION	02
TOTAL PAGE AMOUNT	12

=
+
CURRENT PAGE

Internal targets

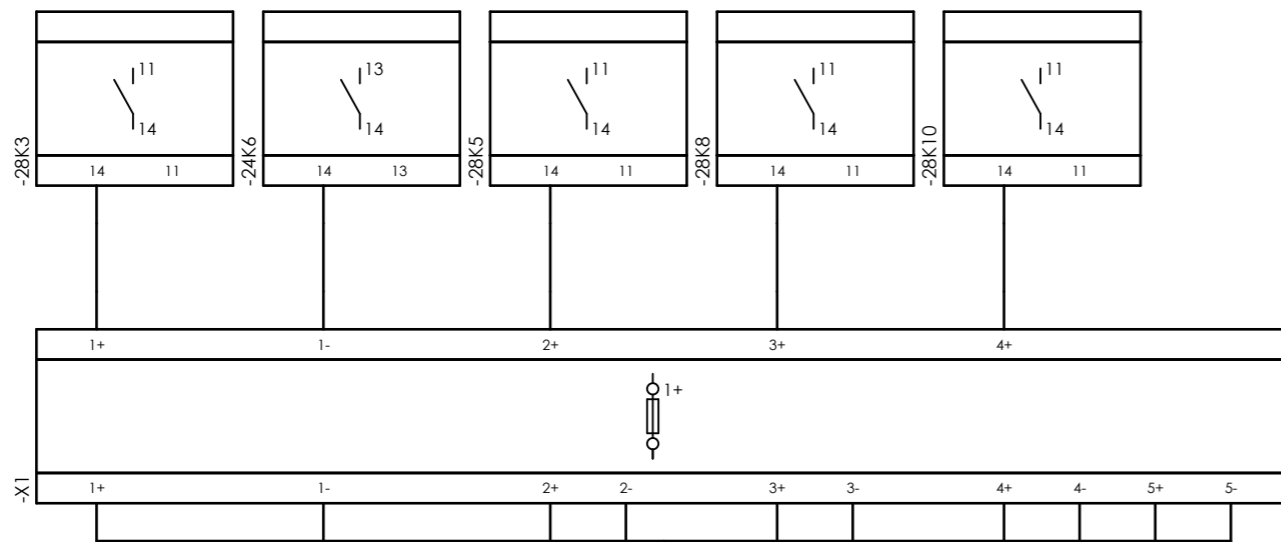

External targets

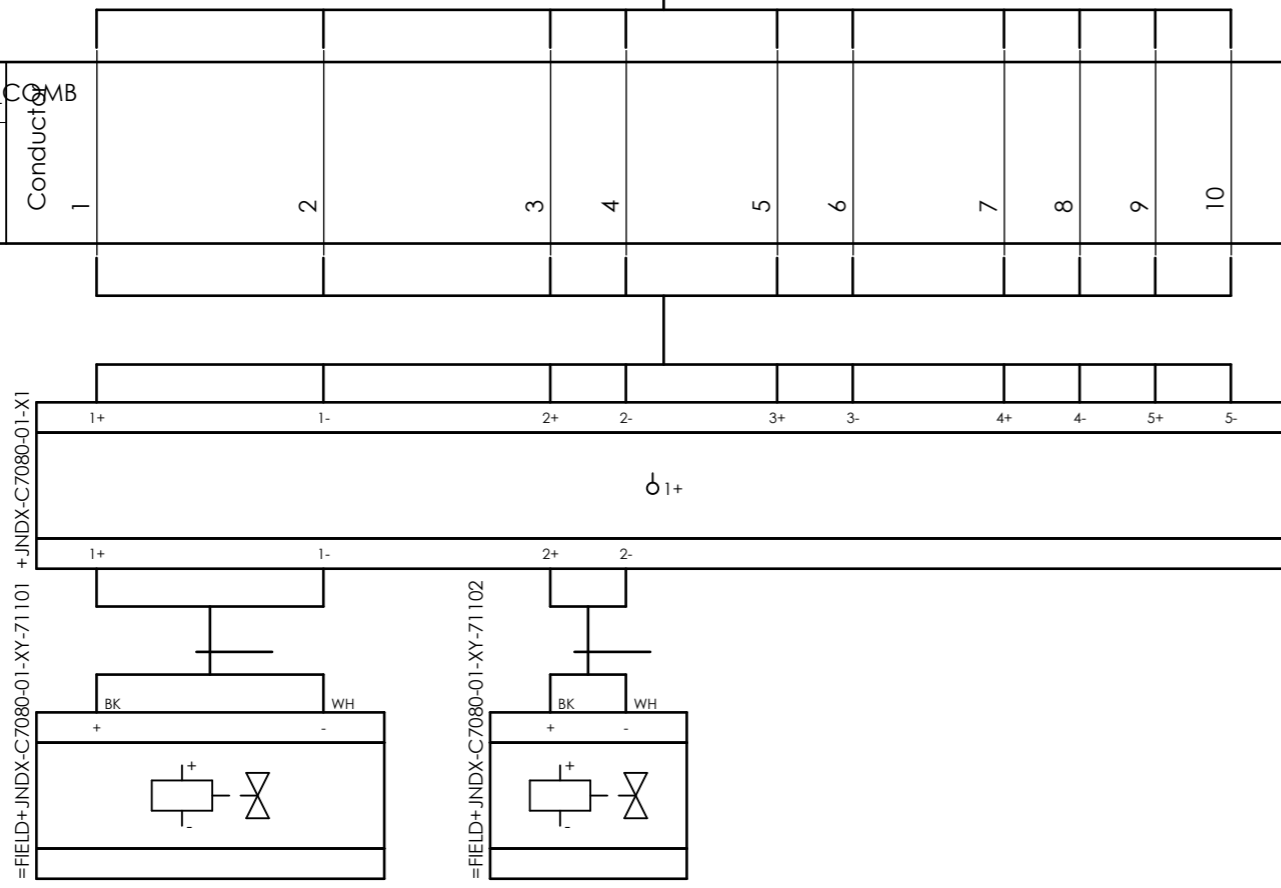


CLIENT DWG NO. BU-20-VD-303-IN-DIG-0093
 EQUIPMENT NO. 20-C-7080
 EQUIPMENT LOCATION Iran, Onshore
 THIS DRAWING IS OWNED BY AIRPACK, AND SHALL NOT BE PRINTED OR COPIED IN ANY OTHER WAY THAN WITH AIRPACKS PERMISSION!

SUBJECT Cable-connection diagram =20-C-7080+UCP-C7080-01-SOL_COMB
 ADAPTED TO P&ID REVISION 03
 CLIENT Bushehr Petrochemical Company (BUPC)
 CLIENT REF. Bushehr MEG Plant Project
 AIRPACK REF. 17811-30B


DRAWN BY RTR
 CHECKED BY RBE
 LAST MODIFICATION DATE
 AIRPACK DWG NO. 17811-30B
 REVISION 02
 TOTAL PAGE AMOUNT 13

=
 +
 CURRENT PAGE
 13


Internal targets

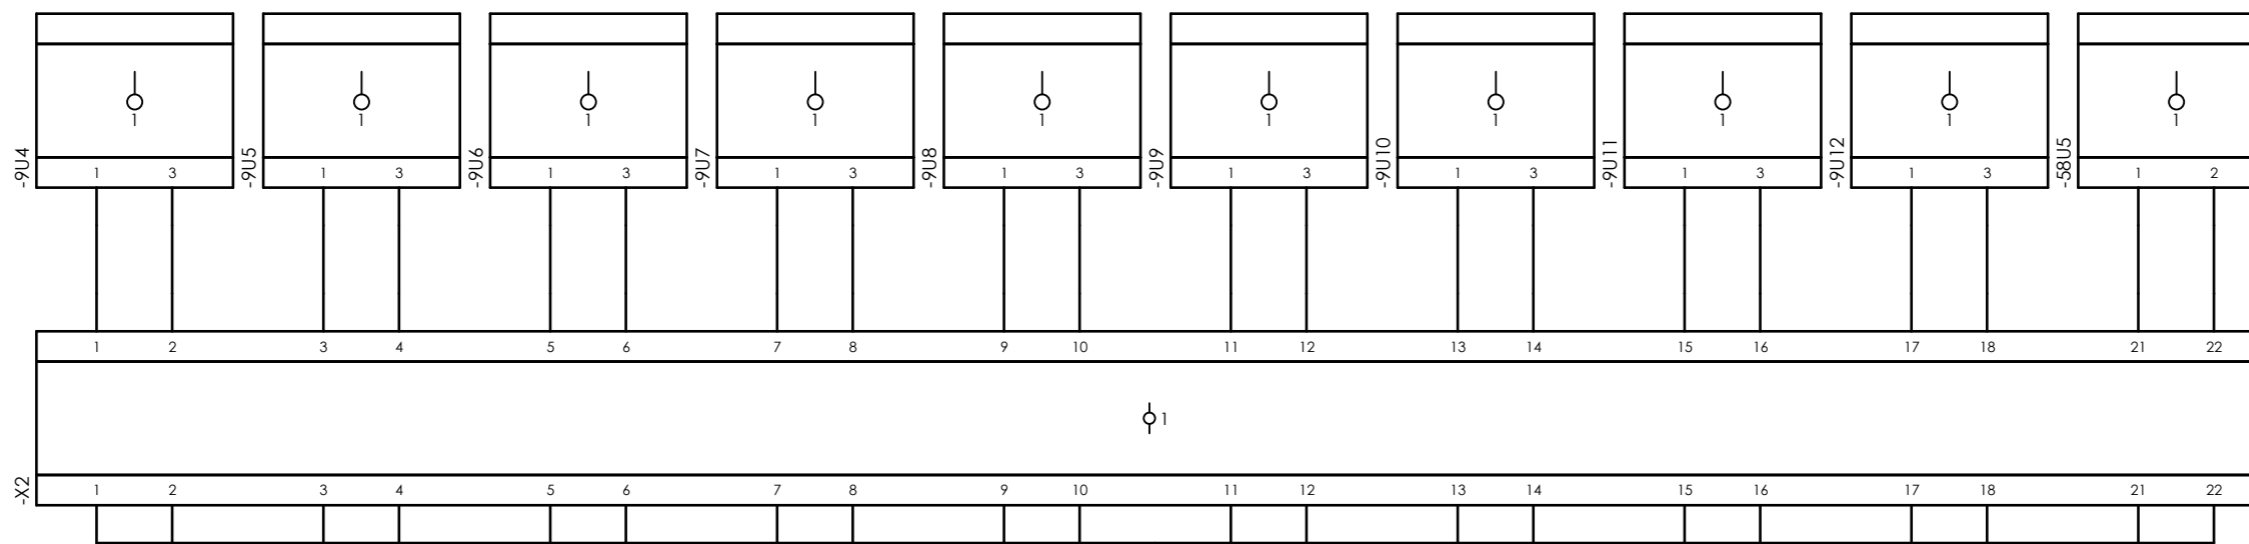

=20-C-7080+UCP-C7080-01-TR_COMB

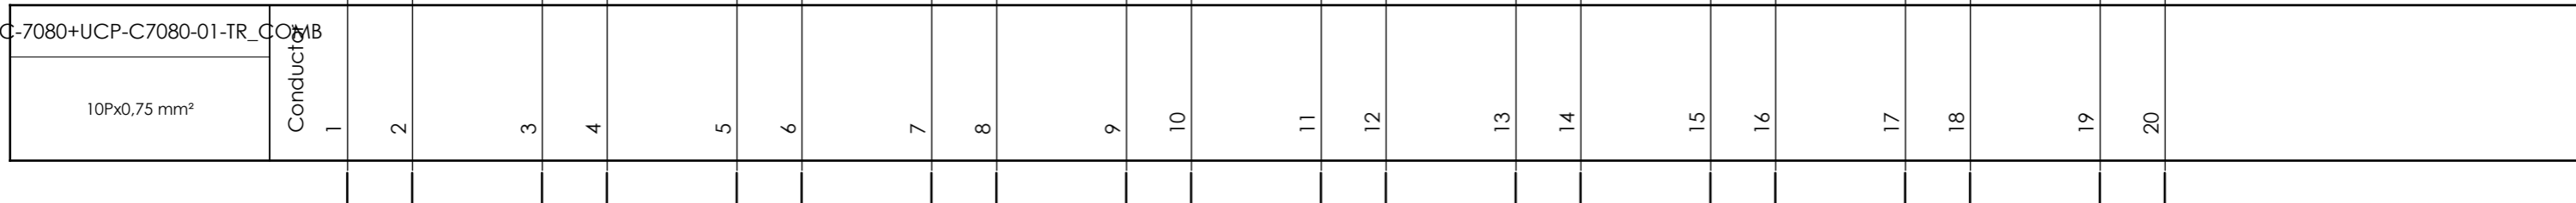

External targets




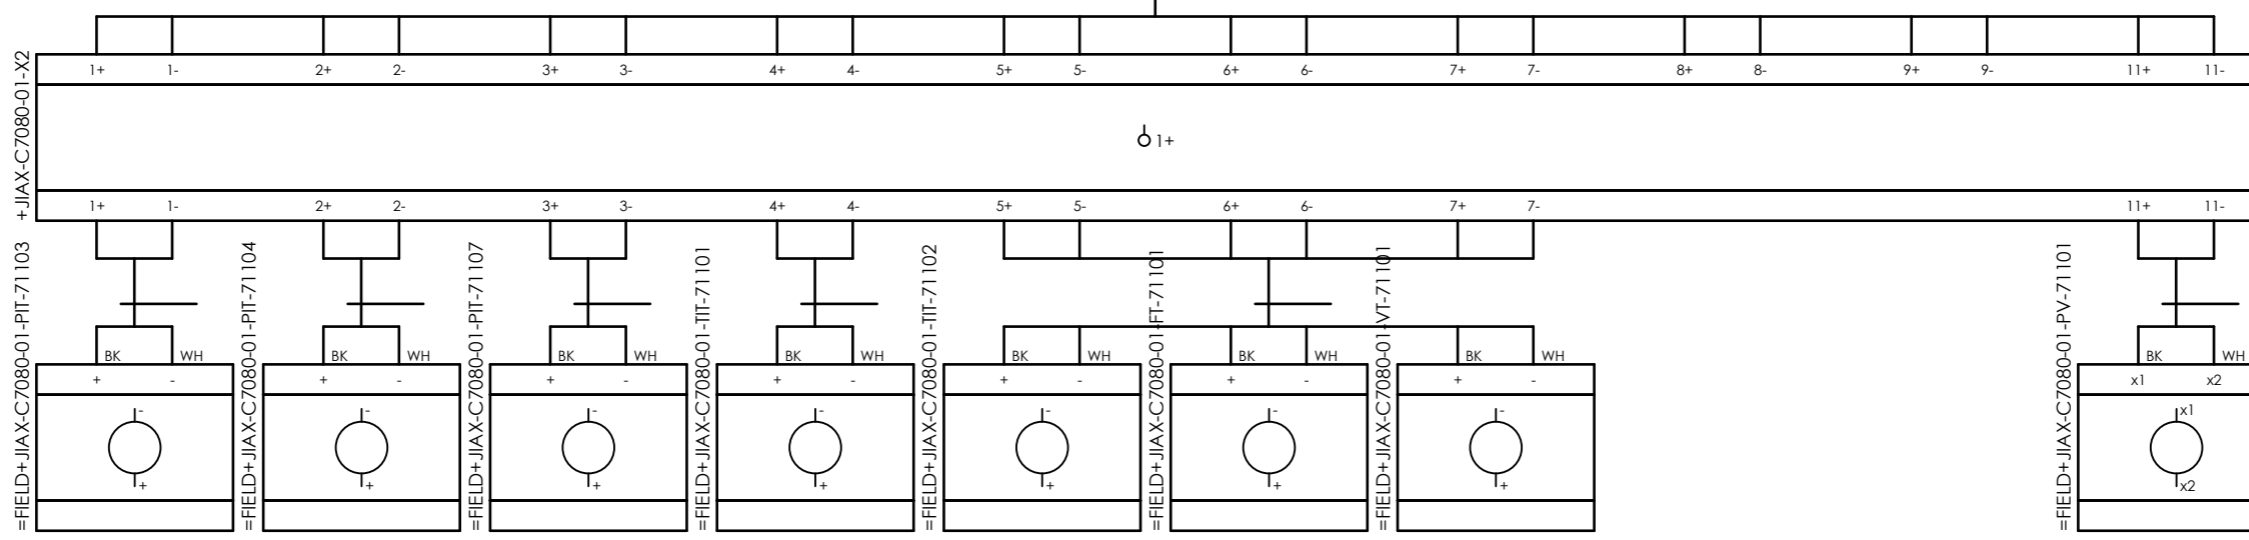


CLIENT DWG NO.	BU-20-VD-303-IN-DIG-0093
EQUIPMENT NO.	20-C-7080
EQUIPMENT LOCATION	Iran, Onshore
THIS DRAWING IS OWNED BY AIRPACK, AND SHALL NOT BE PRINTED OR COPIED IN ANY OTHER WAY THAN WITH AIRPACKS PERMISSION!	

SUBJECT		Cable-connection diagram =20-C-7080+UCP-C7080-01-TR_COMB	
ADAPTED TO P&ID REVISION	03		
CLIENT	Bushehr Petrochemical Company (BUPC)		
CLIENT REF.	Bushehr MEG Plant Project		
AIRPACK REF.	17811-30B		

DRAWN BY	RTR	=
CHECKED BY	RBE	+
LAST MODIFICATION DATE		CURRENT PAGE
AIRPACK DWG NO.	17811-30B	
REVISION	02	
TOTAL PAGE AMOUNT	14	

 Internal targets

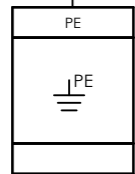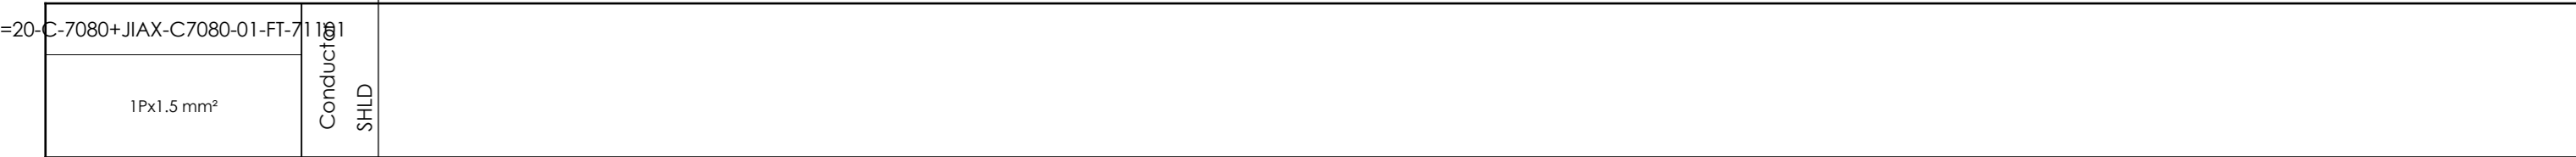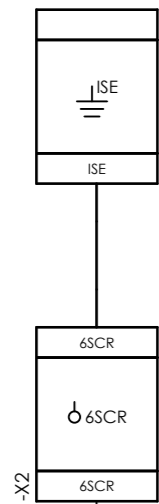

External targets



CLIENT DWG NO.	BU-20-VD-303-IN-DIG-0093
EQUIPMENT NO.	20-C-7080
EQUIPMENT LOCATION	Iran, Onshore

SUBJECT	
Cable-connection diagram =20-C-7080+JIAX-C7080-01-FT-71101	
ADAPTED TO P&ID REVISION	03



DRAWN BY	RTR	=
CHECKED BY	RBE	+
LAST MODIFICATION DATE		CURRENT PAGE

THIS DRAWING IS OWNED BY AIRPACK, AND SHALL NOT BE PRINTED OR COPIED IN ANY OTHER WAY THAN WITH AIRPACKS PERMISSION!



CLIENT	Bushehr Petrochemical Company (BUPC)
CLIENT REF.	Bushehr MEG Plant Project
AIRPACK REF.	17811-30B

AIRPACK DWG NO.	17811-30B
REVISION	02
TOTAL PAGE AMOUNT	15

 Internal targets

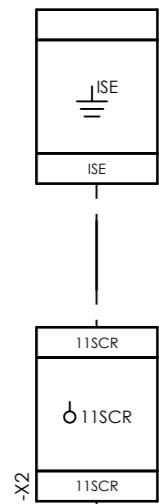

=20-C-7080+JIAX-C7080-01-PV-71101

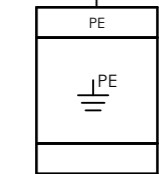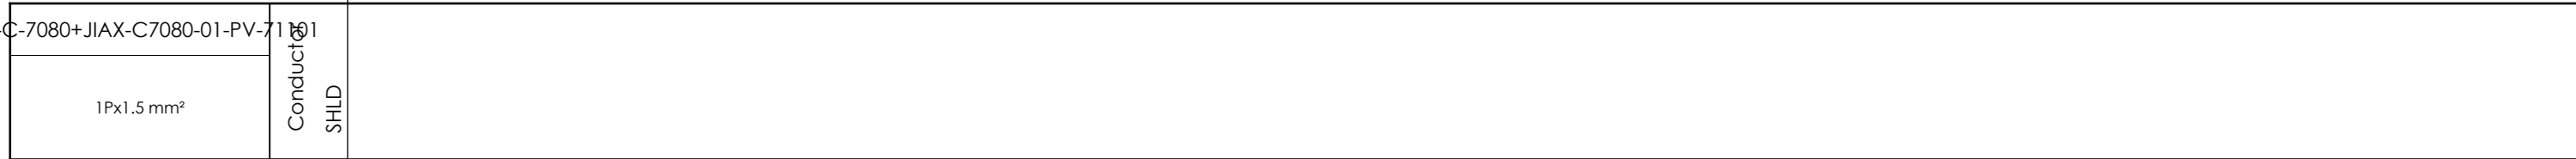

External targets





CLIENT DWG NO.	BU-20-VD-303-IN-DIG-0093
EQUIPMENT NO.	20-C-7080
EQUIPMENT LOCATION	Iran, Onshore
THIS DRAWING IS OWNED BY AIRPACK, AND SHALL NOT BE PRINTED OR COPIED IN ANY OTHER WAY THAN WITH AIRPACKS PERMISSION!	



SUBJECT		Cable-connection diagram =20-C-7080+JIAX-C7080-01-PV-71101	
ADAPTED TO P&ID REVISION	03	CLIENT	Bushehr Petrochemical Company (BUPC)
CLIENT REF.	Bushehr MEG Plant Project	AIRPACK REF.	17811-30B

DRAWN BY	RTR	=
CHECKED BY	RBE	+
LAST MODIFICATION DATE		CURRENT PAGE
AIRPACK DWG NO.	17811-30B	
REVISION	02	
TOTAL PAGE AMOUNT	16	

 Internal targets

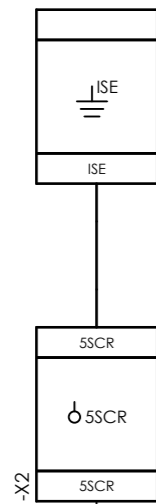

=20-C-7080+JIAX-C7080-01-TIT-71102

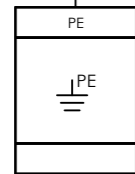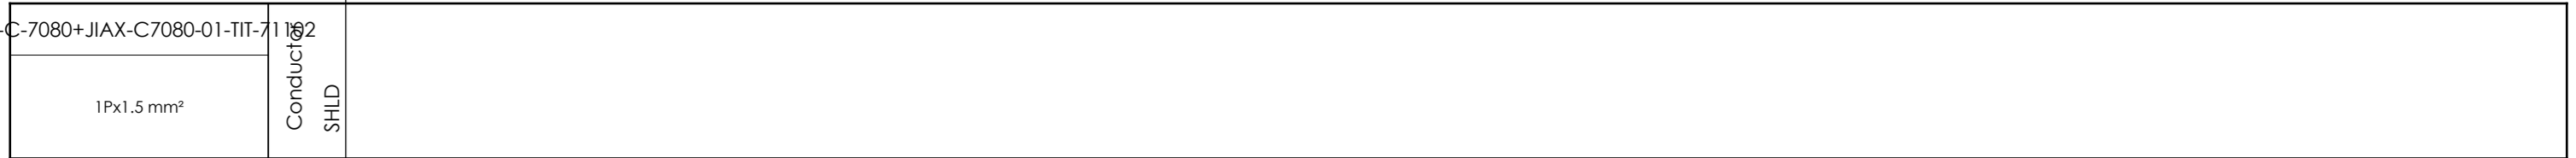

External targets





CLIENT DWG NO.	BU-20-VD-303-IN-DIG-0093
EQUIPMENT NO.	20-C-7080
EQUIPMENT LOCATION	Iran, Onshore
THIS DRAWING IS OWNED BY AIRPACK, AND SHALL NOT BE PRINTED OR COPIED IN ANY OTHER WAY THAN WITH AIRPACKS PERMISSION!	




SUBJECT		Cable-connection diagram =20-C-7080+JIAX-C7080-01-TIT-71102	
ADAPTED TO P&ID REVISION	03	CLIENT	Bushehr Petrochemical Company (BUPC)
CLIENT REF.	Bushehr MEG Plant Project	AIRPACK REF.	17811-30B

DRAWN BY	RTR	=
CHECKED BY	RBE	+
LAST MODIFICATION DATE		CURRENT PAGE
AIRPACK DWG NO.	17811-30B	
REVISION	02	
TOTAL PAGE AMOUNT	17	

 Internal targets

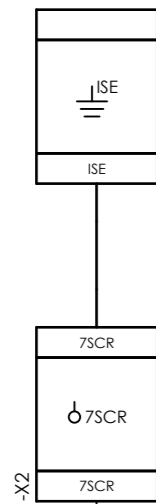

=20-C-7080+JIAX-C7080-01-VT-71101

 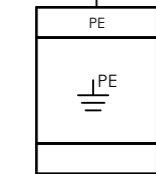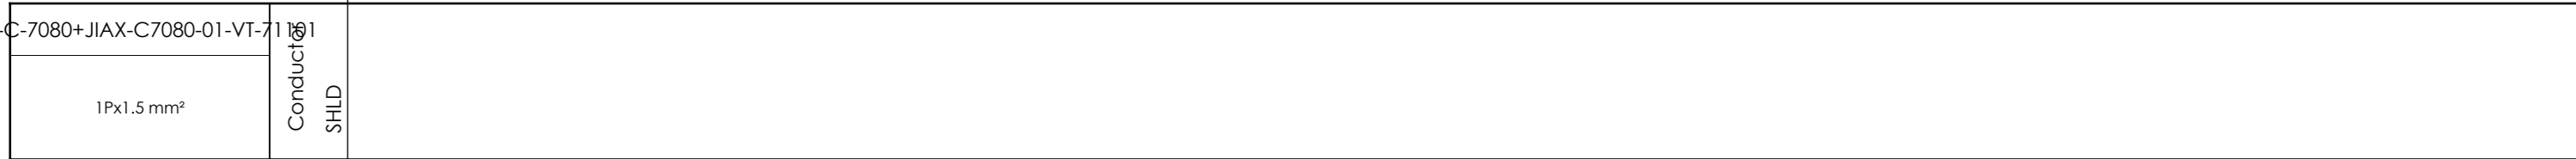

External targets




CLIENT DWG NO.	BU-20-VD-303-IN-DIG-0093
EQUIPMENT NO.	20-C-7080
EQUIPMENT LOCATION	Iran, Onshore
THIS DRAWING IS OWNED BY AIRPACK, AND SHALL NOT BE PRINTED OR COPIED IN ANY OTHER WAY THAN WITH AIRPACKS PERMISSION!	


SUBJECT		Cable-connection diagram =20-C-7080+JIAX-C7080-01-VT-71101	
ADAPTED TO P&ID REVISION	03	CLIENT	Bushehr Petrochemical Company (BUPC)
CLIENT REF.	Bushehr MEG Plant Project	AIRPACK REF.	17811-30B

DRAWN BY	RTR	=
CHECKED BY	RBE	+
LAST MODIFICATION DATE		CURRENT PAGE
AIRPACK DWG NO.	17811-30B	
REVISION	02	
TOTAL PAGE AMOUNT	18	

Internal targets

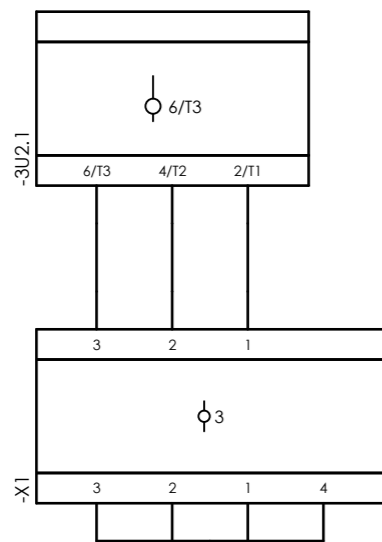


External targets

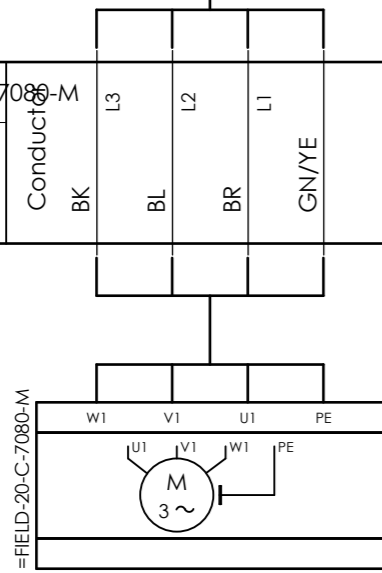


CLIENT DWG NO.	BU-20-VD-303-IN-DIG-0093
EQUIPMENT NO.	20-C-7080
EQUIPMENT LOCATION	Iran, Onshore
THIS DRAWING IS OWNED BY AIRPACK, AND SHALL NOT BE PRINTED OR COPIED IN ANY OTHER WAY THAN WITH AIRPACKS PERMISSION!	

SUBJECT		DRAWN BY	RTR	=
Cable-connection diagram =20-C-7080+PD-C-7080-01-20-C-7080-M		CHECKED BY	RBE	+
ADAPTED TO P&ID REVISION	03	LAST MODIFICATION DATE		CURRENT PAGE
CLIENT	Bushehr Petrochemical Company (BUPC)	AIRPACK DWG NO.	17811-30B	
CLIENT REF.	Bushehr MEG Plant Project	REVISION	02	
AIRPACK REF.	17811-30B	TOTAL PAGE AMOUNT	19	

Internal targets

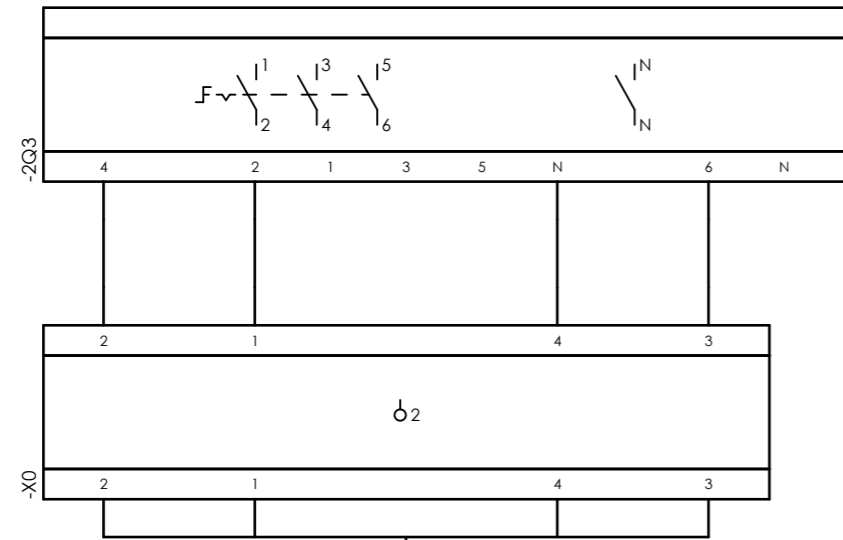

External targets

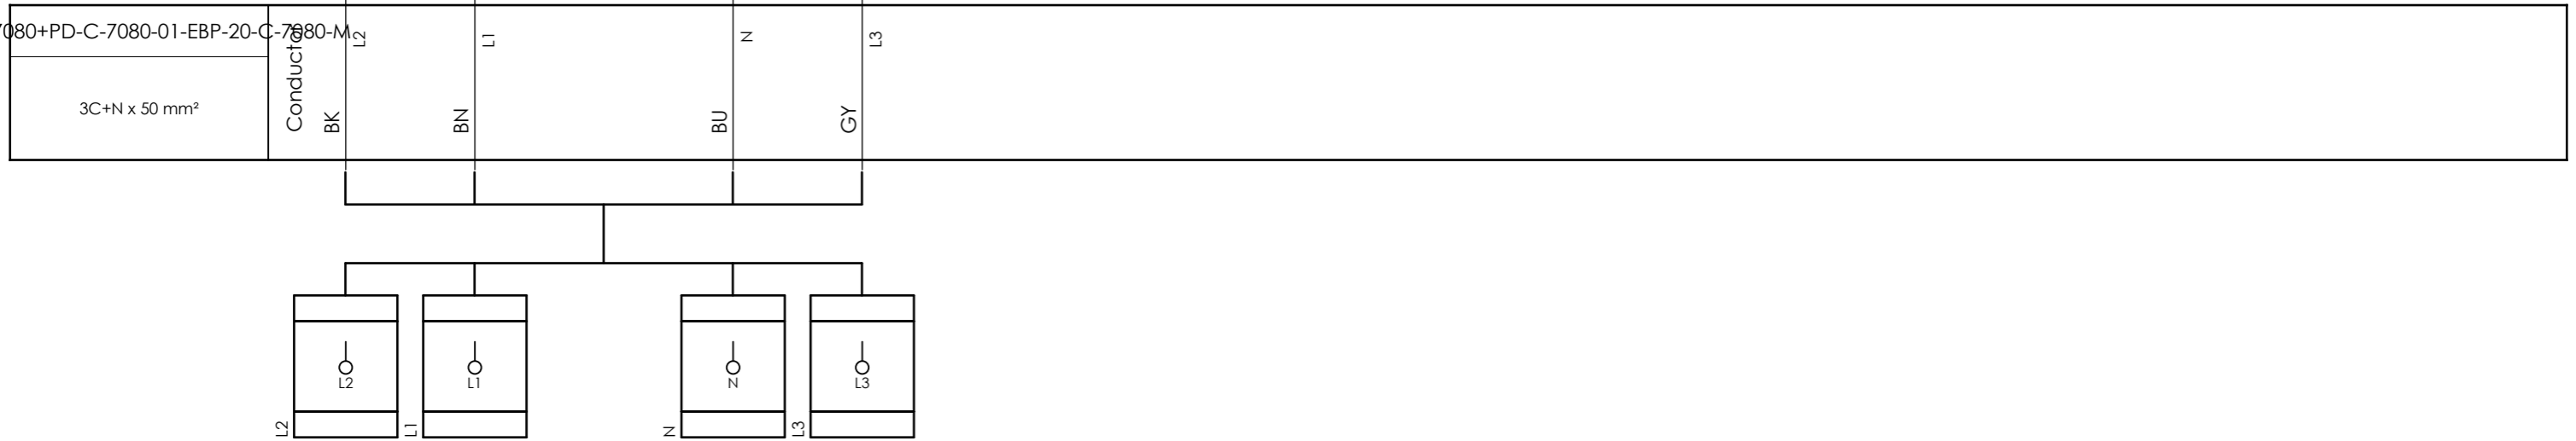


CLIENT DWG NO.	BU-20-VD-303-IN-DIG-0093
EQUIPMENT NO.	20-C-7080
EQUIPMENT LOCATION	Iran, Onshore
THIS DRAWING IS OWNED BY AIRPACK, AND SHALL NOT BE PRINTED OR COPIED IN ANY OTHER WAY THAN WITH AIRPACKS PERMISSION!	

SUBJECT		DRAWN BY	RTR	=
Cable-connection diagram =20-C-7080+PD-C-7080-01-EBP-20-C-7080-M		CHECKED BY	RBE	+
ADAPTED TO P&ID REVISION	03	LAST MODIFICATION DATE		CURRENT PAGE
CLIENT	Bushehr Petrochemical Company (BUPC)	AIRPACK DWG NO.	17811-30B	
CLIENT REF.	Bushehr MEG Plant Project	REVISION	02	
AIRPACK REF.	17811-30B	TOTAL PAGE AMOUNT	20	

DRAWN BY	RTR	=
CHECKED BY	RBE	+
LAST MODIFICATION DATE		CURRENT PAGE
AIRPACK DWG NO.	17811-30B	
REVISION	02	
TOTAL PAGE AMOUNT	20	


Internal targets

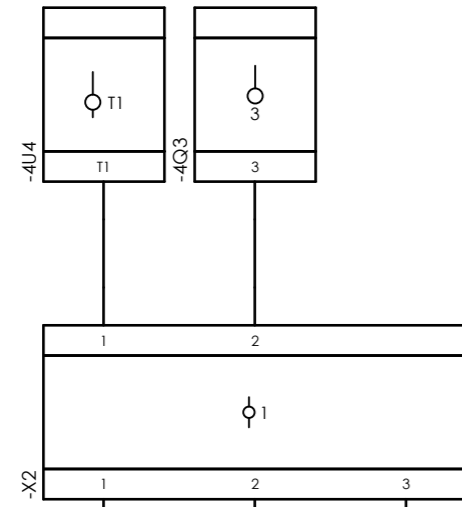

=20-C-7080+PD-C-7080-01-LG-71101



External targets

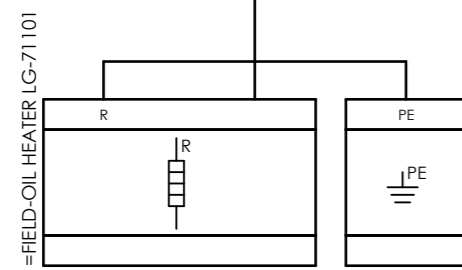

CLIENT DWG NO.	BU-20-VD-303-IN-DIG-0093
EQUIPMENT NO.	20-C-7080
EQUIPMENT LOCATION	Iran, Onshore
THIS DRAWING IS OWNED BY AIRPACK, AND SHALL NOT BE PRINTED OR COPIED IN ANY OTHER WAY THAN WITH AIRPACKS PERMISSION!	

SUBJECT		Cable-connection diagram =20-C-7080+PD-C-7080-01-LG-71101	
ADAPTED TO P&ID REVISION	03	CLIENT	Bushehr Petrochemical Company (BUPC)
		CLIENT REF.	Bushehr MEG Plant Project
		AIRPACK REF.	17811-30B

DRAWN BY	RTR	=
CHECKED BY	RBE	+
LAST MODIFICATION DATE		CURRENT PAGE
AIRPACK DWG NO.	17811-30B	
REVISION	02	
TOTAL PAGE AMOUNT	21	

